

ARCHITECTURAL ABBREVIATIONS

A	A/C AIR CONDITIONING ABV ABOVE ACST ACOUSTIC, ACOUSTICAL ADA AMERICANS WITH DISABILITIES ACT ADJ ADJUSTABLE ADJT ADJACENT AFF ABOVE FINISH FLOOR ALT ALTERNATE ALUM ALUMINUM ANOD ANODIZED ARCH ARCHITECT, ARCHITECTURAL ASPH ASPHALT ASSY ASSEMBLY AUTO AUTOMATIC	F	F/F FACE TO FACE FA FIRE ALARM FAAP FIRE ALARM ANNUNCIATOR PANEL GLAZ GLAZING FCO FLOOR CLEAN OUT FD FLOOR DRAIN FDC FIRE DEPARTMENT CONNECTION FDTN FOUNDATION FE FIRE EXTINGUISHER FEC FIRE EXTINGUISHER CABINET FF FINISH FACE FFE FINISH FLOOR ELEVATION FH FIRE HYDRANT FHC FIRE HOSE CABINET FIN FINISH FINT FUTURE FLR FLOOR FOF FACE OF FINISH FOS FACE OF STUD FR FRAME FRP FIBERGLASS REINFORCED PLASTIC FTW FIRE RETARDANT TREATED WOOD FT FOOT FUR FURRING	P	PBD PARTICLEBOARD PCF POUNDS PER CUBIC FOOT PCP PORTLAND CEMENT PLASTER PLAM PLASTIC LAMINATE PLBG PLUMBING PLWID PLYWOOD PREFAB PREFABRICATED PREFINPREFINISHED PRKG PARKING PSF POUNDS PER SQUARE FOOT PSI POUNDS PER SQUARE INCH PT PAINT PTD PAPER TOWEL DISPENSER PTN PARTITION PVC POLYVINYL CHLORIDE
B	BATT BATT INSULATION BKR BACKER ROD BD BOARD BF BOTH FACES BLDG BUILDING BLKG BLOCKING BLW BELOW BM BEAM BN BULLNOSE BOD BASIS OF DESIGN BOS BOTTOM OF STEEL BOT BOTTOM BRG BEARING BS BOTH SIDES BSMT BASEMENT BTWN BETWEEN BUR BUILT UP ROOFING BW BOTH WAYS BYND BEYOND	G	GA GAGE GALV GALVANIZED GB GRAB BAR GL GLASS GLU LAM GLUED LAMINATED WOOD GLAZ GLAZING GYP GYPSUM	Q	QT QUARRY TILE QTB QUARRY TILE BASE QTY QUANTITY
C	CG CORNER GUARD CIP CAST IN PLACE CJ CONTROL JOINT CL CENTER LINE CLG CEILING CLST CLOSET CLR CLEAR CLRM CLASSROOM CMU CONCRETE MASONRY UNIT CO COMPANY COL COLUMN CONC CONCRETE CONT CONTINUE CONTR CONTRACTOR COORDCOORDINATE CORR CORRIDOR CPT CARPET CRS COURSE(S) CSWK CASEWORK CT CERAMIC TILE CTR CENTER CTV CABLE TELEVISION CU CUBIC CUH CABINET UNIT HEATER CW COLD WATER PIPING	H	HB HOSE BIB HDR HEADER HDW HARDWARE HWD HARDWOOD HM HOLLOW METAL HDLR HANDRAIL HORZ HORIZONTAL HP HORSEPOWER HT HEIGHT HVAC HEATING VENTILATING & AIR CONDITIONING HW HOT WATER HYD HYDRANT	R	R RADIUS, RISER R- THERMAL RESISTANCE RA RETURN AIR RB RUBBER BASE RD ROOF DRAIN RDL ROOF DRAIN LEADER REF REFER TO REIN REINFORCE REQD REQUIRED REV REVISION RM ROOM RO ROUGH OPENING RPM REVOLUTIONS PER MINUTE RTU ROOF TOP UNIT
D	DBL DOUBLE DEPT DEPARTMENT DTL DETAIL DF DRINKING FOUNTAIN DIA DIAMETER DIM DIMENSION DISP DISPENSER DL DEAD LOAD DMPF DAMPROOFING DN DOWN DR DOOR DS DOWNSPOUT DW DISHWASHER DWG DRAWING	I	ID INSIDE DIAMETER INCL INCLUDED INSUL INSULATION INT INTERIOR	S	SECT SECTION SF SQUARE FOOT, FEET SA SUPPLY AIR SAT SUSPENDED ACOUSTICAL TILE SB SPLASH BLOCK SCHD SCHEDULE SCP SCUPPER SD SOAP DISPENSER SOG SLAB ON GRADE SGFT STRUCTURAL GLAZED FACED TILE SHT SHEET SHTG SHEATHING SIM SIMILAR SJ SLIP JOINT SLDG SLIDING SLNT SEALANT SND SANITARY NAPKIN DISPENSER SNDU SANITARY NAPKIN DISPOSAL UNIT SPEC SPECIFICATION SQ SQUARE SST STAINLESS STEEL STC SOUND TRANSMISSION CLASS STD STANDARD STL STEEL STOR STORAGE STRUCT STRUCTURAL SUSP SUSPENDED SYMM SYMMETRICAL SYS SYSTEM
E	EA EAST ED EACH EJ EXPANSION JOINT EL ELEVATION ELEC ELECTRICAL ELEV ELEVATOR ENCL ENCLOSURE ENGR ENGINEER EPDM ETHYLENE PROPYLENE DIENE MONOMER EQ EQUAL EQUIP EQUIPMENT EWC ELECTRIC WATER COOLER EWH ELECTRIC WATER HEATER EXC EXCAVATE EXIST EXISTING EF EXHAUST FAN EXP EXPANSION EXT EXTERIOR	J	JST JOIST	T	T&G TONGUE & GROOVE TD TOWEL DISPENSER TEL TELEPHONE THK THICKNESS TO TOP OF TOC TOP OF CONCRETE TOM TOP OF MASONRY TOS TOP OF STEEL TOW TOP OF WALL TPD TOILET PAPER DISPENSER TYP TYPICAL
		K	K KELVIN KW KILOWATT	U	UNFIN UNFINISHED UNOT UNLESS OTHERWISE NOTED UR URINAL
		L	L ANGLE LAV LAVATORY LBR LUMBER LF LIBRARY LINO LINOLEUM LKR LOCKER LL LIVE LOAD LLH LONG LEG HORIZONTAL LLV LONG LEG VERTICAL LT LIGHT LVR LOUVER	V	VAR VARIES, VARIABLE VCT VINYL COMPOSITION TILE VERT VERTICAL VEST VESTIBULE VIF VERIFY IN FIELD VTR VENT THROUGH ROOF VWC VINYL WALL COVERING
		M	MAX MAXIMUM MECH MECHANICAL MEMB MEMBRANE MFD MANUFACTURED MFR MANUFACTURER MIN MINIMUM MIRR MIRROR MISC MISCELLANEOUS MLDG MOLDING MO MASONRY OPENING MTD MOUNTED MTL METAL	W	W WEST W/ WITH W/O WITHOUT WB WOOD BASE WBL WOOD BLOCKING WC WATER CLOSET WCO WALL CLEAN OUT WD WOOD WF WIDE FLANGE WP WORKING POINT WSC WAINSCOT WWF WELDED WIRE FABRIC WNDW WINDOW
		N	NA NOT APPLICABLE NONCOM NONCOMBUSTIBLE NIC NOT IN CONTRACT NO NUMBER NOM NOMINAL NRC NOISE REDUCTION COEFFICIENT NTS NOT TO SCALE	Y	YD YARD
		O	OA OVERALL OC ON CENTER OD OUTSIDE DIAMETER OF/CI OWNER FURNISHED/CONTRACTOR INSTALLED OF/OI OWNER FURNISHED/OWNER INSTALLED OH OVERHEAD OPP OPPOSITE OPNG OPENING ORD OVERFLOW ROOF DRAIN		

PROJECT TEAM

ARCHITECT:

Hord Coplan Macht
1800 Wazee Street, Suite 450
Denver, CO 80202
Ph: 303-607-0977
URL: www.hcm2.com

INTERIORS:

Hord Coplan Macht
1800 Wazee Street, Suite 450
Denver, CO 80202
Ph: 303-607-0977
URL: www.hcm2.com

MECHANICAL:

Cator, Ruma and Associates, Co.
896 Tabor Street
Lakewood, CO 80401
Ph: 303-232-6200
URL: www.catoruma.com

ELECTRICAL:

Cator, Ruma and Associates, Co.
896 Tabor Street
Lakewood, CO 80401
Ph: 303-232-6200
URL: www.catoruma.com

PLUMBING:

Cator, Ruma and Associates, Co.
896 Tabor Street
Lakewood, CO 80401
Ph: 303-232-6200
URL: www.catoruma.com

AV / IT:

NVS
2650 18th St #202
Denver, CO 80211
Ph: 303-220-6400
URL: www.nv5.com

ARCHITECTURAL LEGEND

	CONCRETE		BRICK
	CMU		ROUGH LUMBER
	PLYWOOD		FINISH LUMBER
	GYPSUM		RIGID INSULATION
	STEEL		BATT INSULATION
	DETAIL NUMBER		WINDOW TAG
	EXTERIOR ELEVATION		DOOR TAG
	BUILDING SECTION		KEYNOTE TAG
	WALL SECTION		PARTITION TAG
	DETAIL NUMBER		REVISION TAG
	DETAIL NUMBER		DETAIL CALLOUT
	INTERIOR ELEVATION		SHEET NUMBER

VICINITY MAP



SCAN FOR GOOGLE MAP LOCATION



COLORADO MOUNTAIN COLLEGE SPRING VALLEY CAMPUS NURSING SIMULATION LAB

3000 Co Rd 114
Glenwood Springs, CO 81601

CONTRACT DOCUMENTS



SHEET INDEX

INDEX GENERAL SHEETS

G-001	COVER SHEET
G-101	LIFE SAFETY PLAN AND CODE ANALYSIS

INDEX ARCHITECTURAL SHEETS

A-001	TYPICAL MOUNTING HEIGHTS
A-010	PARTITION TYPES
A-101	OVERALL FLOOR PLAN - BASE SCOPE
A-101.1	OVERALL DIMENSION PLAN
A-101A	OVERALL FLOOR PLAN - ALTERNATES
A-141	FINISH PLAN
A-142	FURNITURE PLAN
A-151	REFLECTED CEILING PLAN
A-301	BUILDING SECTIONS
A-401	ENLARGED PLANS
A-402	ENLARGED PLANS
A-421	INTERIOR ELEVATIONS
A-422	INTERIOR ELEVATIONS
A-423	INTERIOR ELEVATIONS
A-511	INTERIOR DETAILS
A-531	CASEWORK DETAILS
A-611	DOORS AND WINDOWS SCHEDULE & TYPES
AD111	DEMOLITION FLOOR PLAN
AD151	DEMOLITION CEILING PLAN

INDEX MECHANICAL SHEETS

M-001	MECHANICAL LEGENDS AND NOTES
M-002	MECHANICAL SCHEDULES
M-101	FIRST LEVEL HVAC PLAN
M-111	FIRST LEVEL HVAC PIPING PLAN
M-401	MECHANICAL DETAILS
MD-101	FIRST LEVEL HVAC DEMOLITION PLAN
MD-111	FIRST LEVEL HVAC PIPING DEMOLITION PLAN

INDEX ELECTRICAL SHEETS

E-001	ELECTRICAL LEGENDS AND NOTES
E-002	ELECTRICAL SCHEDULES
E-011	ELECTRICAL ONE-LINE DIAGRAM
E-101	FIRST LEVEL LIGHTING PLAN
E-111	FIRST LEVEL POWER PLAN
E-121	FIRST LEVEL FIRE ALARM PLAN
ED-101	FIRST LEVEL LIGHTING DEMOLITION PLAN
ED-111	FIRST LEVEL POWER DEMOLITION PLAN
ED-121	FIRST LEVEL FIRE ALARM DEMOLITION PLAN

INDEX PLUMBING SHEETS

F-001	FIRE PROTECTION LEGENDS AND NOTES
F-101	FIRST LEVEL FIRE PROTECTION PLAN
P-001	PLUMBING LEGENDS AND NOTES
P-101	FIRST LEVEL DOMESTIC WATER PLAN
P-110	FOUNDATION WASTE AND VENT PLAN
P-111	FIRST LEVEL WASTE AND VENT PLAN
PD-110	FOUNDATION WASTE AND VENT DEMOLITION PLAN
PD-111	FIRST LEVEL WASTE AND VENT DEMOLITION PLAN

INDEX AV / IT SHEETS

T-001	TECHNOLOGY INFRASTRUCTURE LEGENDS AND NOTES
T-002	TECHNOLOGY INFRASTRUCTURE LEGENDS AND LEGEND NOTES
T-003	TECHNOLOGY INFRASTRUCTURE LEGENDS AND SCHEDULES
T-101	OVERALL TECHNOLOGY INFRASTRUCTURE PLAN
T-121	OVERALL TECHNOLOGY INFRASTRUCTURE REFLECTED CEILING PLAN
T-131	OVERALL TELECOM PLAN
T-200	TELECOM ENLARGED PLANS AND ELEVATIONS
T-300	AUDIOVISUAL INFRASTRUCTURE ROOM RISERS
T-301	AUDIOVISUAL INFRASTRUCTURE ROOM RISERS
T-302	AUDIOVISUAL INFRASTRUCTURE ROOM RISERS
T-402	TYPICAL TELECOM RISER
T-500	TECHNOLOGY INFRASTRUCTURE ELEVATIONS
T-501	TECHNOLOGY INFRASTRUCTURE ELEVATIONS
T-601	TECHNOLOGY INFRASTRUCTURE DETAILS
T-701	TELECOM DETAILS
TD-111	OVERALL TECHNOLOGY INFRASTRUCTURE DEMO PLANS
Y-001	SECURITY SYMBOLS LEGEND, NOTES AND SCHEDULES
Y-003	OVERALL SECURITY PLAN
Y-001	SECURITY DETAILS

ARCHITECT
Hord Coplan Macht, Inc.
1800 Wazee Street, Suite 450
Denver, CO 80202
ph: 303.607.0977
URL: www.hcm2.com


ME/P ENGINEER
Cator, Ruma and Associates, Co.
896 Tabor Street
Lakewood, CO 80401
p. 303-232-6200
URL: www.catoruma.com

AV / IT
NVS
2650 18th St #202
Denver, CO 80211
ph: 303-220-6400
URL: www.nv5.com

COLORADO MOUNTAIN COLLEGE
NURSING RENOVATION
3000 Co Rd 114, Glenwood Springs, CO 81601

hord | coplan | macht

ARCHITECTURE
LANDSCAPE ARCHITECTURE
PLANNING
INTERIOR DESIGN

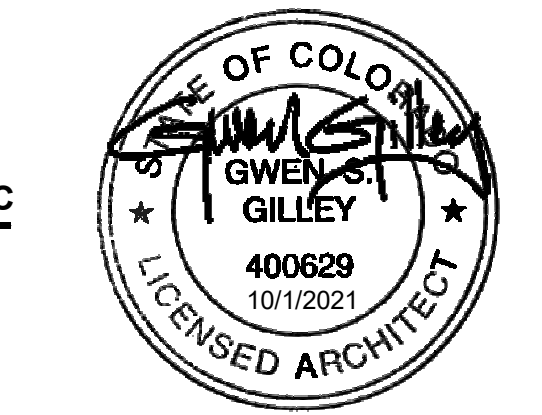

No. Date Revision

Project Name
NURSING RENOVATION

Project Number
22172.00

Date (YYYY/MM/DD)
10-01-2021

Drawn By
SPD

Checked By
HRM

Drawing
COVER SHEET

G-001

CONTRACT DOCUMENTS

© Hord Coplan Macht, Inc.

EXISTING BUILDING: LEVEL 2 ALTERATION -

STANDARDS:
 NFPA 170 STANDARDS FOR FIRE SAFETY AND EMERGENCY SYMBOLS - 2021 EDITION
 NFPA 3 STANDARD FOR COMMISSIONING OF FIRE PROTECTION AND LIFE SAFETY SYSTEMS - 2021 EDITION
 NFPA 4 STANDARD FOR INTEGRATED FIRE PROTECTION AND LIFE SAFETY SYSTEM TESTING - 2021 EDITION
 NFPA 101 LIFE SAFETY CODE - 2012 EDITION
 NFPA 101A GUIDE ON ALTERNATIVE APPROACHES TO LIFE SAFETY - 2013 EDITION

CODE SUMMARY:
CMC SPRING VALLEY - STUDENT COMMONS
3000 CO RD 114, GLENWOOD SPRINGS, CO 81601

USE & OCCUPANCY:
OCCUPANCY CLASSIFICATION: BUSINESS, ASSEMBLY
INCIDENTAL USE AREAS: MECHANICAL ROOMS & STORAGE ROOMS (PER IBC TABLE509)

HEIGHT AND AREA ALLOWABLE:
CONSTRUCTION TYPE: IIB, NON-SEPARATED MIXED USE (PER IBC TABLE 601)
ALLOWABLE HEIGHT: 75 FT (PER IBC TABLE 504.3)
ALLOWABLE STORIES ABOVE GRADE: 3-STORIES (PER IBC TABLE 504.4)
ACTUAL HEIGHT: 28FT
ACTUAL NUMBER OF STORIES ABOVE GRADE: 2-STORIES
ALLOWABLE AREA PER FLOOR: 28500 SF + 35.625 SF = 64,125 SF (PER IBC 506.2.2)

BUILDING AREA:
LEVEL 01: 19,765
LEVEL 02 20,930
TOTAL: 40,695

FIRE PROTECTION SYSTEMS:
 SPRINKLER SYSTEM: THROUGHOUT PER NFPA 13 (PER IBC 903)
 *ALL SPACES WITHIN THE EXISTING BUILDING IS EQUIPPED WITH A SPRINKLER SYSTEM
 FIRE ALARM SYSTEM: EXISTING (PER IBC 907.2.1)
 PORTABLE FIRE EXTINGUISHERS: YES (PER IBC 906.1 & IFC)

<u>FIRE RESISTANCE RATED CONSTRUCTION:</u>	
PRIMARY STRUCTURAL FRAME	0 HRS
EXTERIOR	0 HRS
INTERIOR	0 HRS
NONBEARING WALLS AND PARTITIONS (EXTERIOR)	0 HRS
NONBEARING WALLS AND PARTITIONS (INTERIOR)	0 HRS
FLOOR CONSTRUCTION	0 HRS
ROOF CONSTRUCTION	0 HRS
SHAFTS	1 HRS

MEANS OF EGRESS:
OCCUPANT LOAD FACTOR
ASSEMBLY WITHOUT FIXED SEATS: 1:15 NET
CLASSROOM: 1:20 NET
OFFICE (B): 1:150 GROSS
EDUCATIONAL SHOPS AND OTHER VOCATIONAL ROOM AREAS: 1:50 NET
ACCESSORY STORAGE AREAS, MECHANICAL EQUIPMENT ROOM: 1:300 GROSS

OCCUPANTS:	
EXISTING LEVEL 1 (EXISTING TO REMAIN):	255
EXISTING LEVEL 1 (EXISTING TO BE REVISED):	173
TOTAL EXISTING LEVEL 1:	428

NEW LEVEL 1 OCCUPANTS:	151
*NEW OCCUPANTS ARE LESS THAN THE EXISTING LEVEL 1 OCCUPANT LOAD OF 173	
TOTAL EXISTING LEVEL 2:	613
TOTAL EXISTING	1,041
TOTAL WITH REDUCED LEVEL 1	1,030

- ONE HOUR FIRE BARRIER
- TWO HOUR FIRE BARRIER
- COMMON PATH OF TRAVEL DISTANCE
- EGRESS PATH
- NOT PART OF PROJECT SCOPE

OCCUPANT LOAD FACTOR LEGEND

- | | |
|--|---|
| | ACCESSORY STORAGE AREAS, MECHANICAL EQUIPMENT ROOM |
| | ASSEMBLY WITHOUT FIXED SEATS UNCONCENTRATED (TABLES AND CHAIRS) |
| | BUSINESS AREAS |
| | EDUCATIONAL CLASSROOM |
| | EDUCATIONAL SHOPS AND OTHER VOCATIONAL ROOM AREAS |

No.	Date	Revision
-----	------	----------

Project Name _____

NURSING RENOVATION

Project Number
2172.00

to (YYYY/MM/DD)

0-01-2021

Drawn By _____

RM

Drawing

MODE ANALYSIS

0101


5.101

CONCLUSIONS


CONCLUSIONS

CONTRACT DOCUMENT

© Hard Coplan

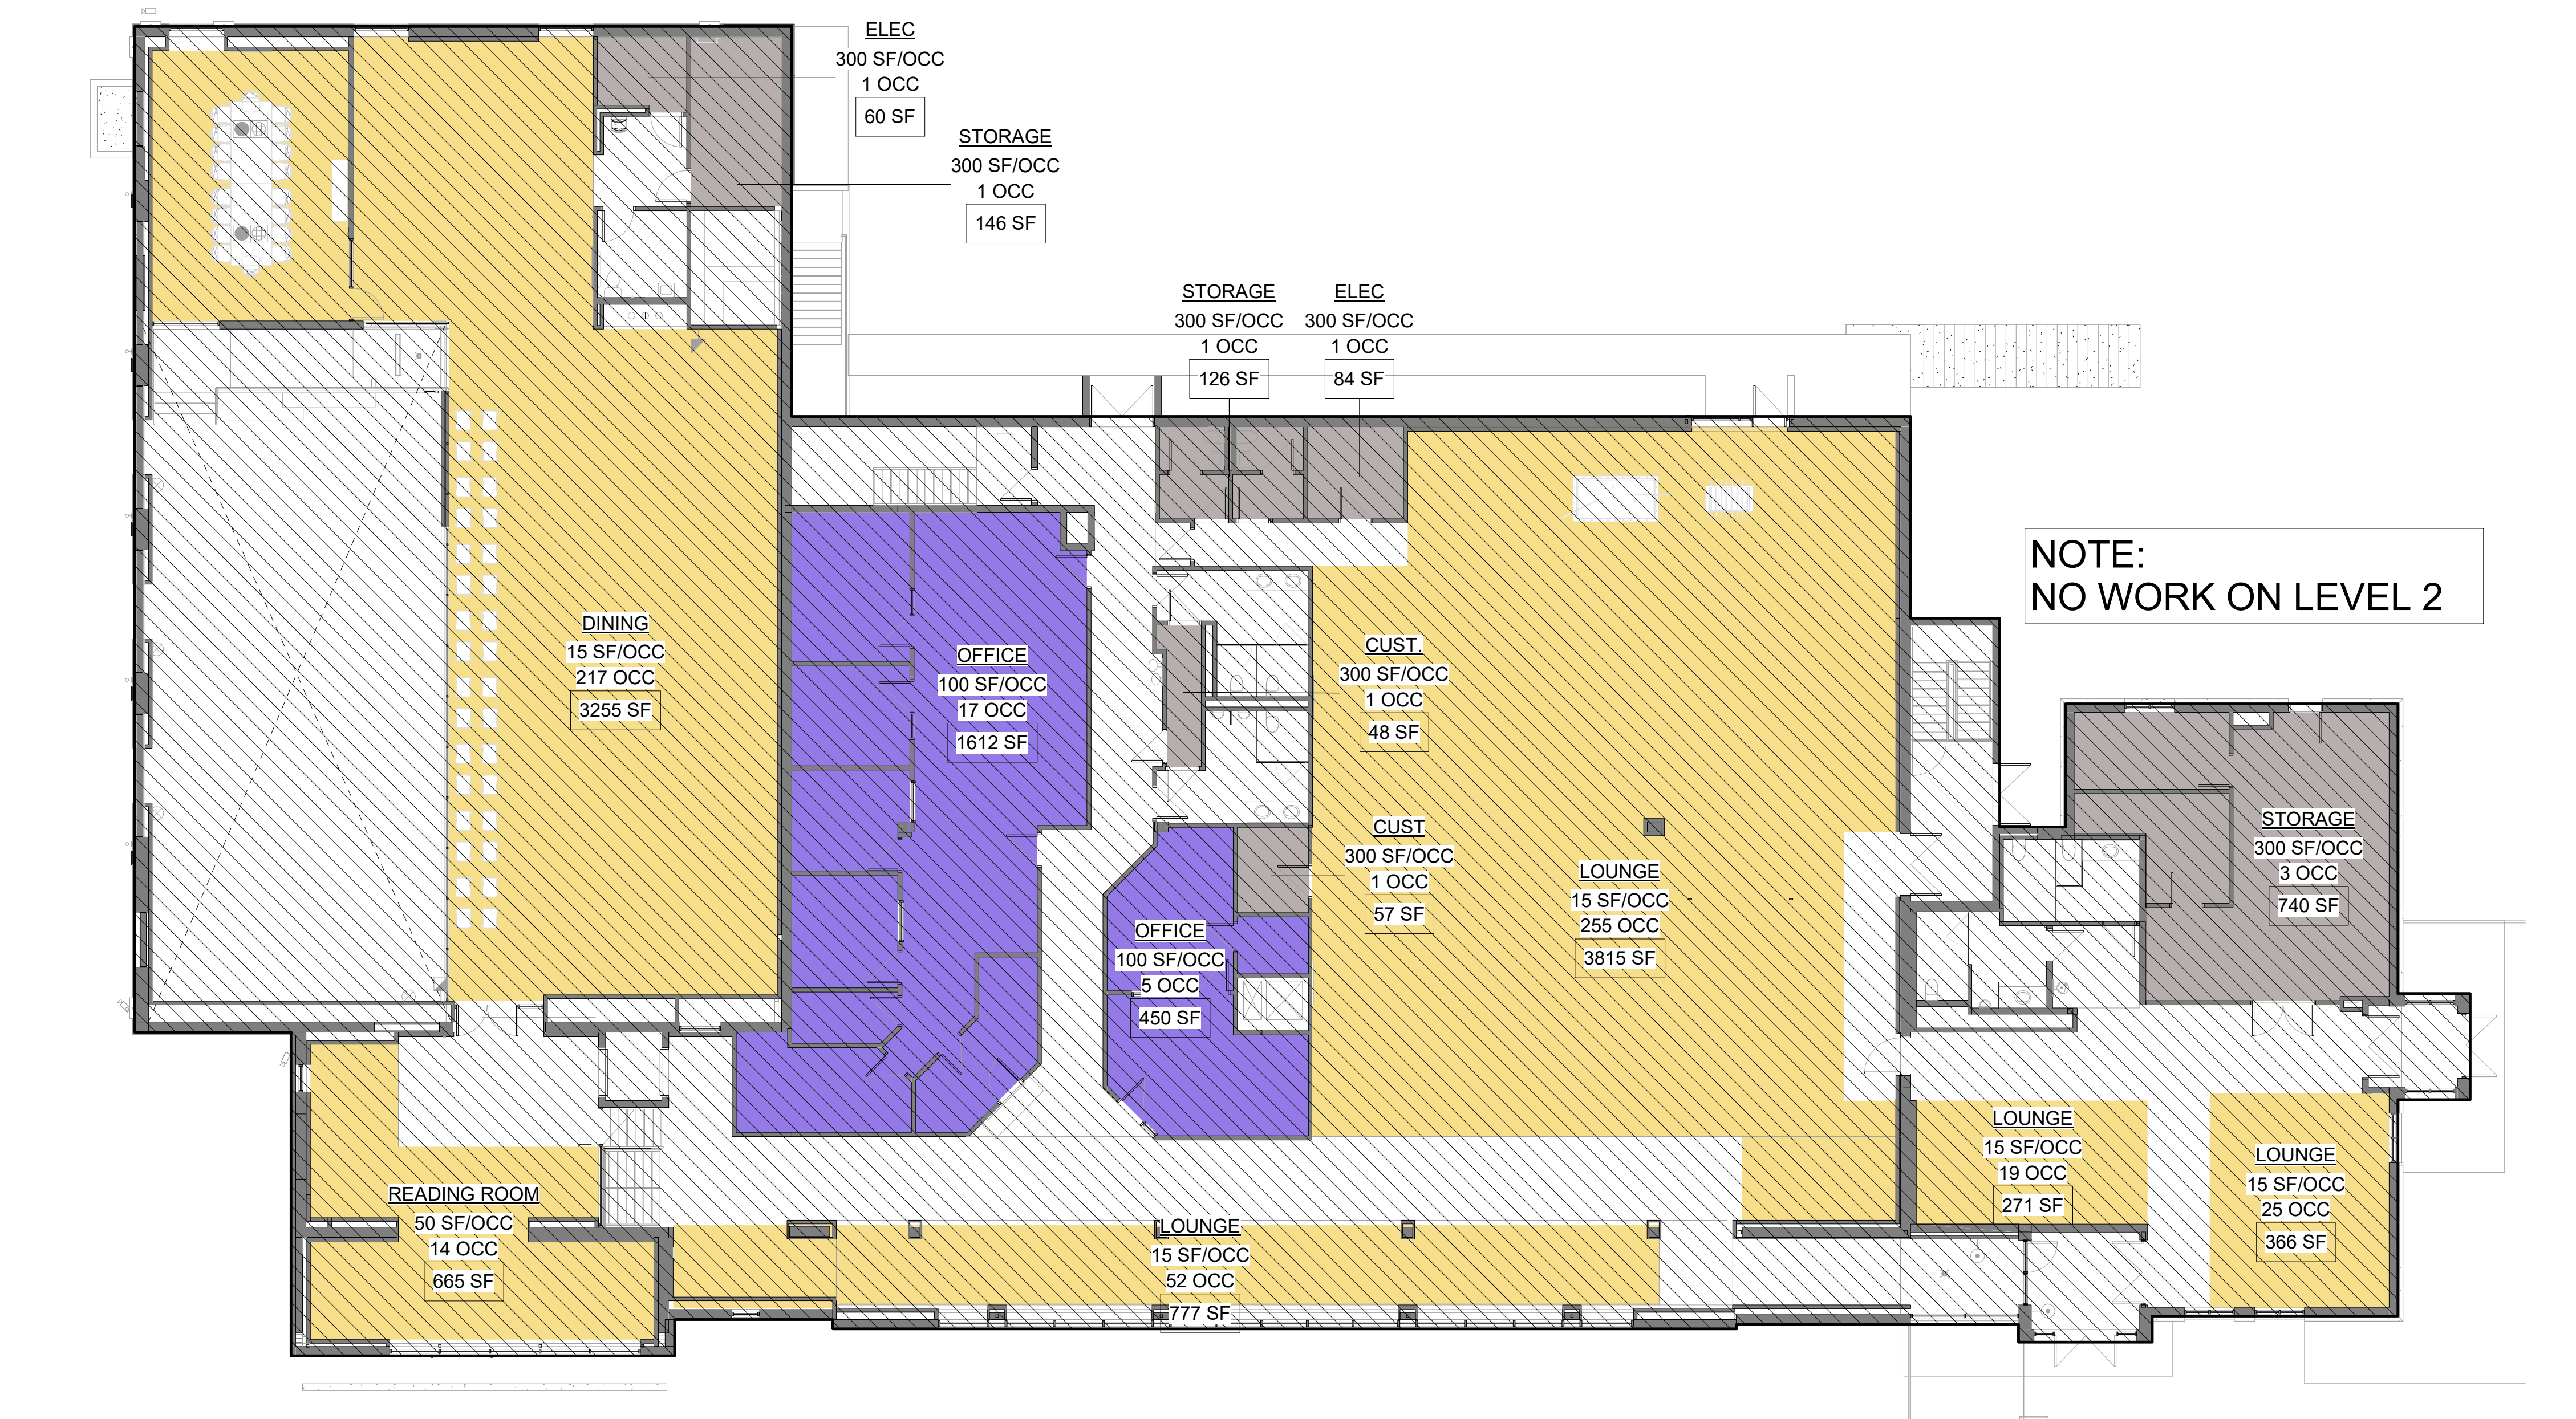


D1 | G-102 LIFE SAFETY LEVEL 2

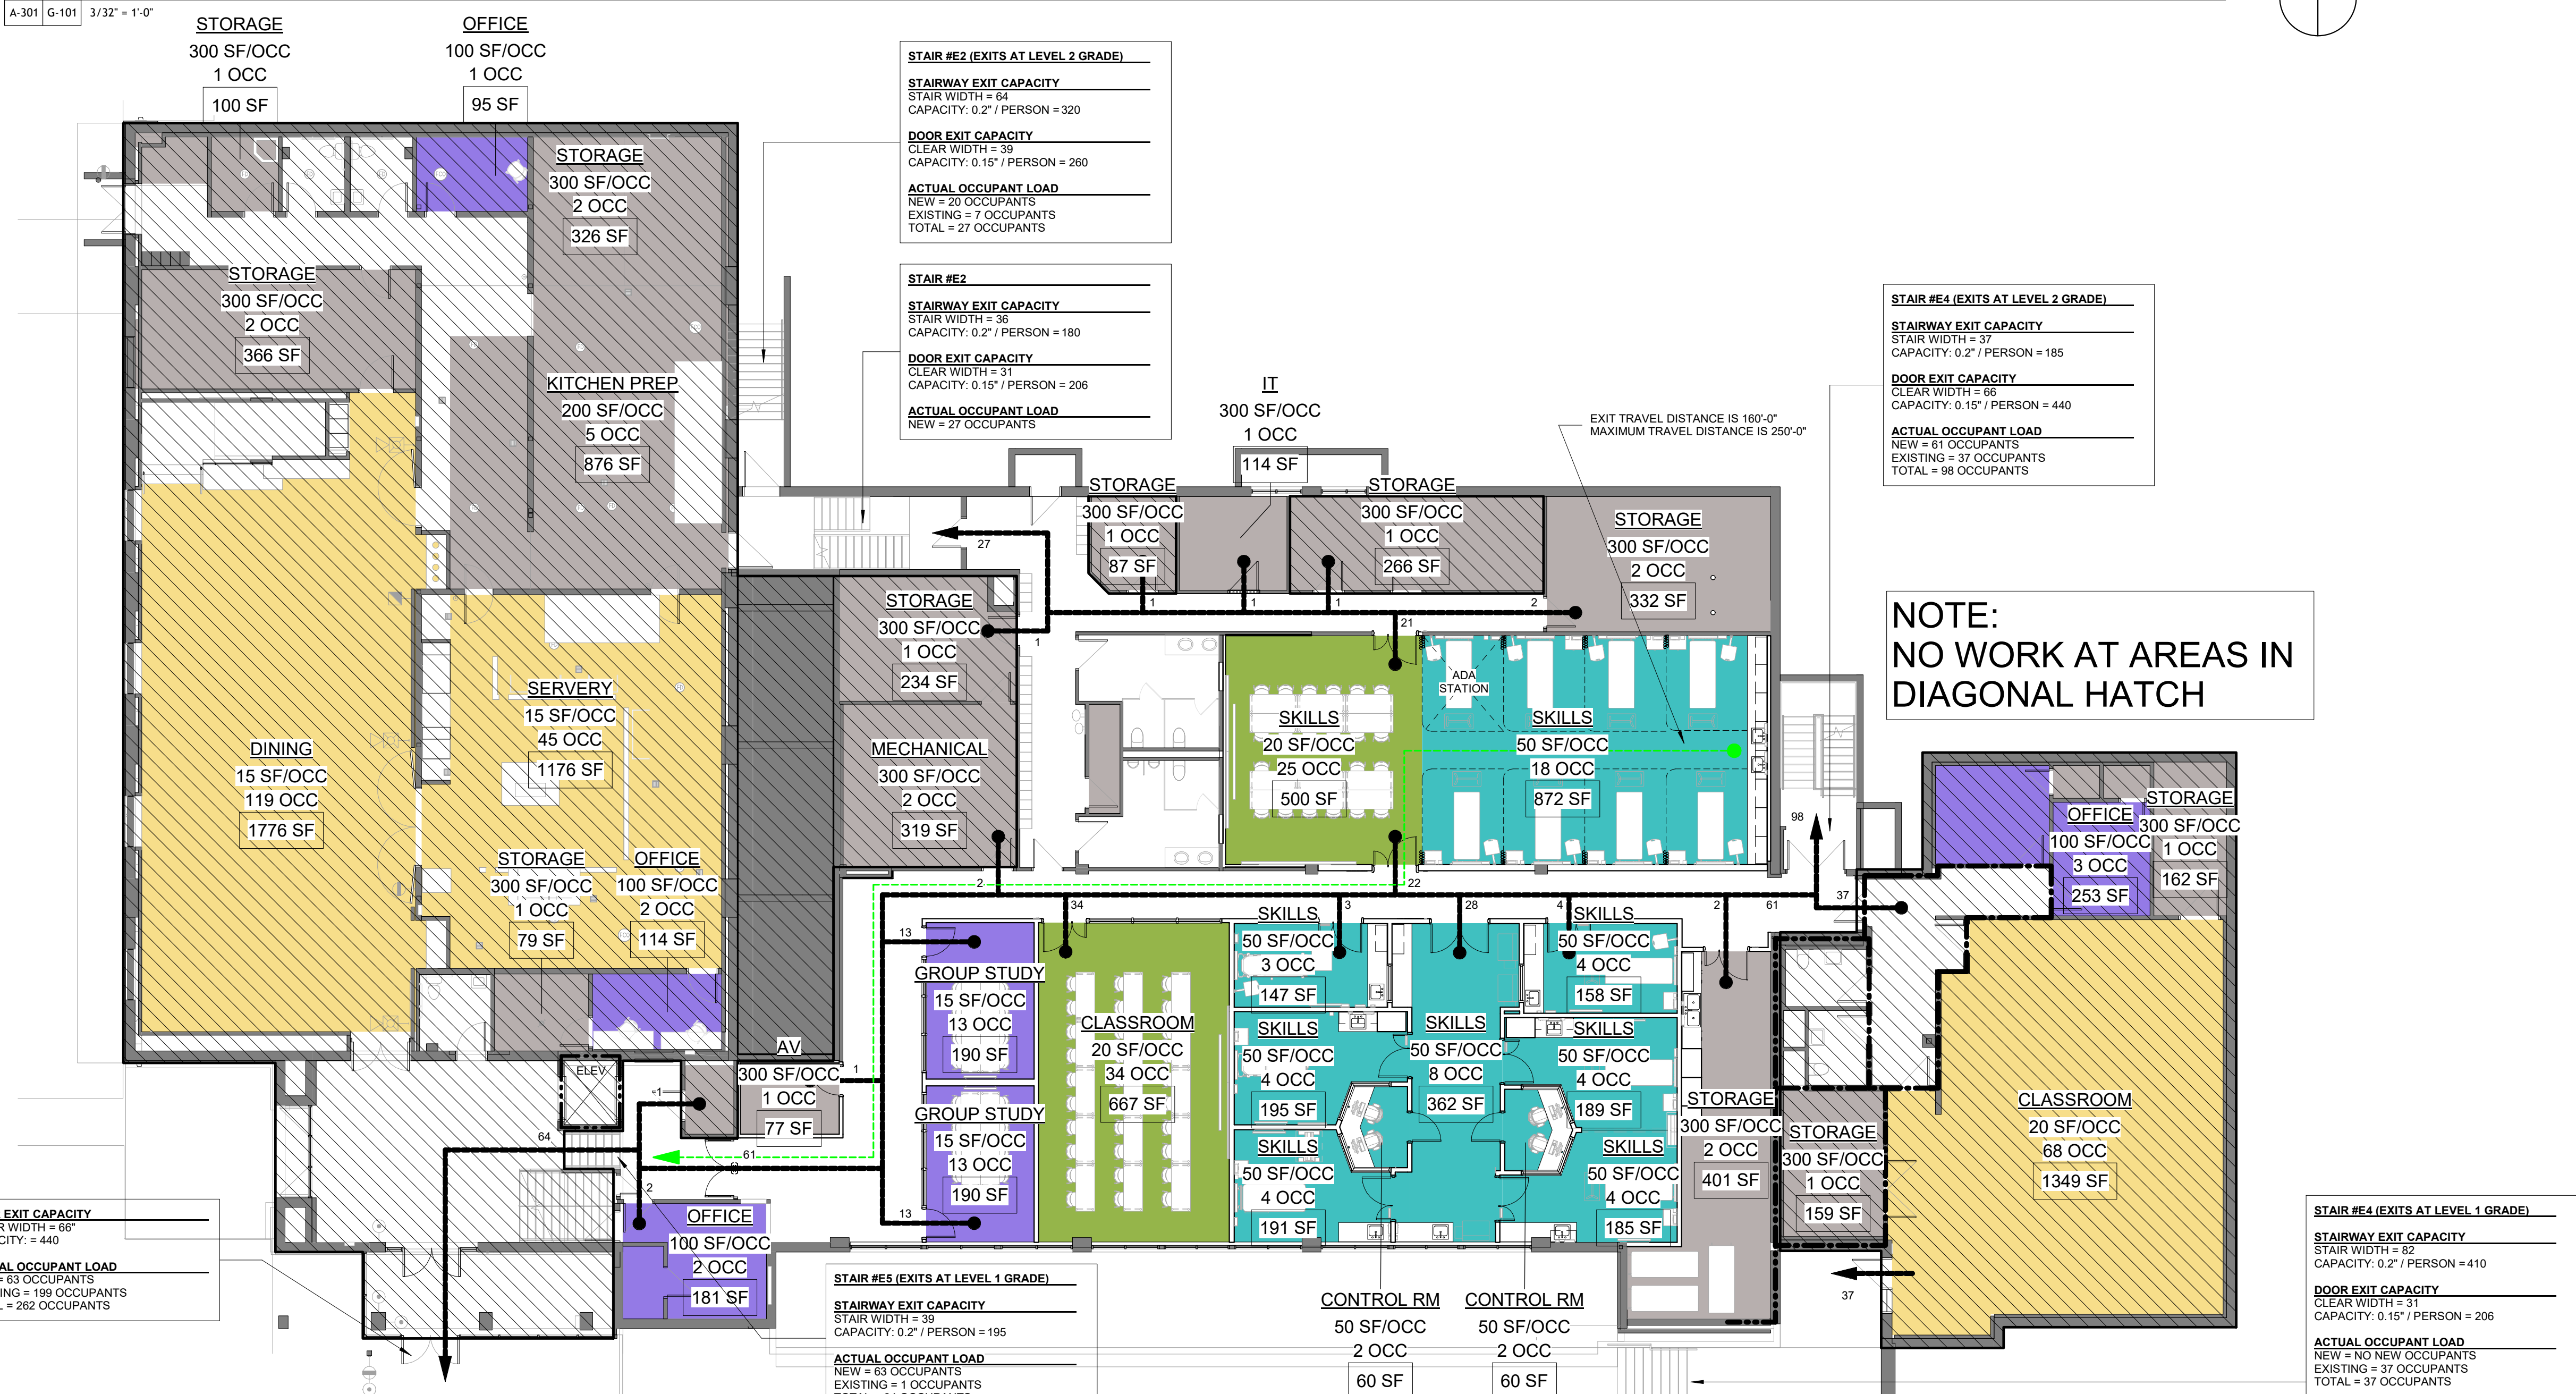

A1 | G-101 LIFE SAFETY LEVEL 0

10/10/2021 8:47:51 PM IMA 360-021-1110-00 DMC Nursing Bldg Rev04/2021 110.00 DMC Nursing Bldg Rev04, Central, 2021.rvt

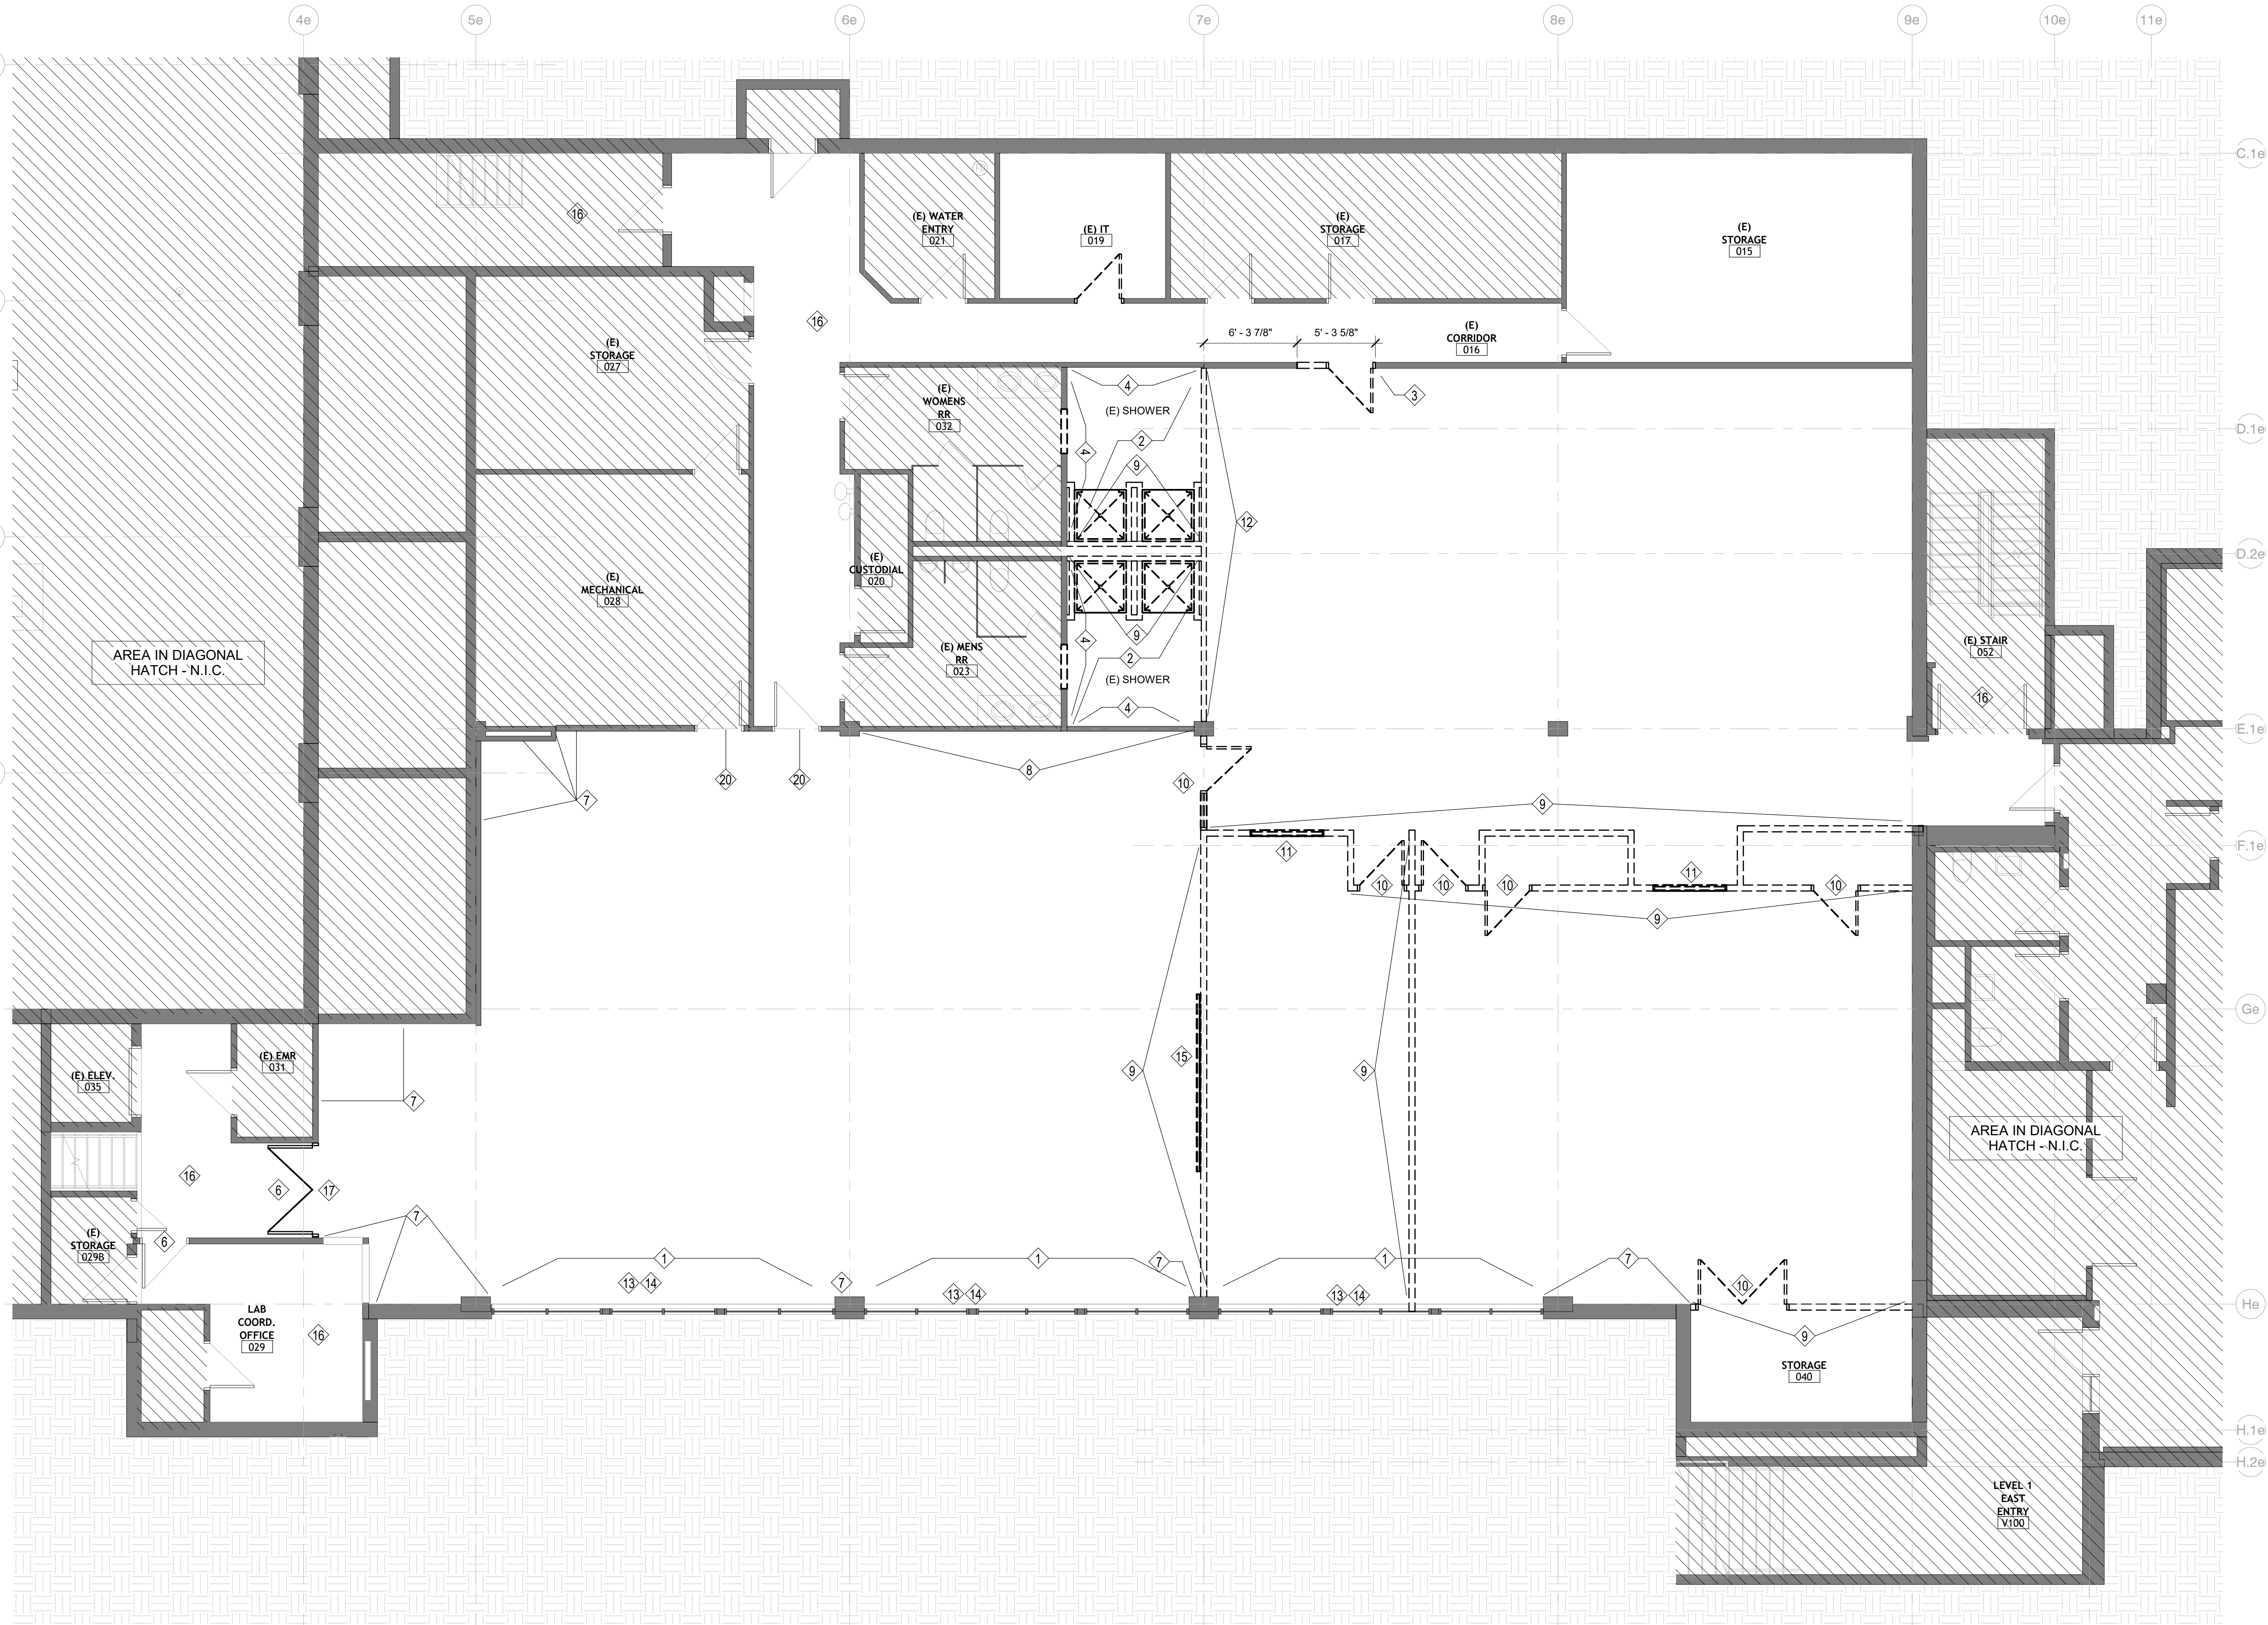

DEMOLITION GENERAL NOTES

- GENERAL CONTRACTOR TO COORDINATE SCHEDULING ALL WORK WITH OWNER.
- WORK LABELED (NIC), OR OTHERWISE NOT NOTED IS NOT IN CONTRACT FOR ANY ARCHITECTURAL IMPROVEMENTS.
- THE GENERAL CONTRACTOR & THEIR SUBCONTRACTORS SHALL VERIFY ALL EXISTING CONDITIONS AND DIMENSIONS WITH CONDITIONS SHOWN IN THE CONTRACT DOCUMENTS AND SHALL REPORT ANY DEVIATIONS, DISCREPANCIES AND/OR CONFLICTS TO ARCHITECT.
- THE GENERAL CONTRACTOR & SUBCONTRACTOR SHALL TAKE EXTREME CARE DURING DEMOLITION NOT TO DAMAGE OR DISTURB ANY EXISTING CONDITIONS THAT ARE TO REMAIN. GENERAL CONTRACTOR OR SUBCONTRACTOR SHALL REPAIR ANY DAMAGE OR DISTURBANCE TO EXISTING CONDITIONS AT NO COST TO THE OWNER.
- PROVIDE PROTECTION FOR FLOORS, WALLS, & CEILING AT ALL EXISTING CONDITIONS TO REMAIN, INCLUDING TRAFFIC AREA FOR DEMOLITION REMOVAL IN COMMON BUILDING AREAS & FREIGHT ELEVATORS. DAMAGED FLOORS WILL BE REPLACED @ NO COST TO OWNER.
- REMOVE ALL WALLS, DOORS (AND OTHER ITEMS) SHOWN DASHED - FIELD VERIFY EXISTING CONDITIONS AND TEMPORARILY OR PERMANENTLY REMOVE ITEMS AS NECESSARY FOR NEW CONSTRUCTION.
- ALL ITEMS WITHIN WALLS TO BE REMOVED ARE NOT SHOWN - FIELD VERIFY EXISTING CONDITIONS AND TEMPORARILY OR PERMANENTLY REMOVE ITEMS AS NECESSARY FOR NEW CONSTRUCTION.
- REFER TO SPECIFICATIONS REGARDING EXISTING CONDITIONS, CUTTING AND PATCHING AND SELECTIVE DEMOLITION REQUIREMENTS THAT APPLY TO ALL WORK KEY NOTES DESCRIBED ON THIS SHEET.
- REFER TO (ELECTRICAL, MECHANICAL, ETC.) DEMOLITION DRAWINGS FOR ADDITIONAL ITEMS.
- COORDINATE W/ BUILDING OWNER DURING DEMOLITION TO DETERMINE WHETHER EXISTING FIRE & SMOKE DETECTION SYSTEMS ARE TO BE BAGGED, PROTECTED & REMAIN IN OPERATION OR TO BE TAKEN OFF LINE.
- AREAS OF DEMOLITION SHALL BE FREE OF (FURNITURE AND MOBILE EQUIPMENT AND ACCESSORIES) PRIOR TO START OF WORK.
- REMOVE (STAPLES, NAILS AND SCREWS) FROM WALLS TO REMAIN, TYPICAL THROUGHOUT.
- REMOVE AND SALVAGE ALL SIGNAGE, CLOCKS, EMERGENCY KITS, AND PHONES FROM WALLS. PATCH AND REPAIR WALLS WHERE DAMAGED BY REMOVAL. SALVAGE AND RETURN TO OWNER OR SALVAGE FOR NEW LOCATION.
- REMOVE AND REPLACE ALL EXISTING SWITCH PLATES AND OUTLET COVERS FROM EXISTING WALLS AND REPLACE WITH NEW PLATES PER SPEC.
- REMOVE ALL EXISTING WALL MOUNTED DOOR STOPPERS. PATCH AND REPAIR WALLS WHERE DAMAGED BY REMOVAL.
- REMOVE ALL FLOORING (INCLUDING ADHESIVES, SETTING MATERIALS, TRANSITION MATERIALS, ETC.) AND RUBBER WALL BASE. PROTECT WALLS FROM DAMAGE.

SHEET NOTES - DEMO FLOOR PLANS

NOTE #	NOTE
1	(E) RADIANT WALL HEATERS TO BE REMOVED. REFER TO MECHANICAL DRAWINGS FOR DETAILS AND SCOPE.
2	REMOVE EXISTING SHOWER, SHOWER INSERT, FLOOR TILE, WALL TILE AND TILE BACKER TO STUDS ON SHOWER SIDE OF RESTROOM. CAP PLUMBING AT SHOWERS. RE: PLUMBING
3	REMOVE (E) DOOR & HOLLOW METAL FRAME, AND EXISTING PARTITION TO EXTENT INDICATED AND TO 7'-2" AFF
4	REMOVE TILE AND TILE BACKER TO STUDS. PREP STUDS TO RECEIVE NEW GYPSUM WALLBOARD.
5	SAW-CUT EXISTING FLOOR SLAB FOR NEW SANITARY CONNECTION AT SINKS, COORD. EXTENT OF SAW-CUT WITH PLUMBING DRAWINGS AND EXACT LOCATION OF SANITARY. RE: PLUMBING
6	REMOVE (E) VINYL LETTERING AT (E) GLASS
7	(E) DRYWALL AND FRAMING TO REMAIN. PROTECT IN PLACE DURING CONSTRUCTION. PATCH DRYWALL AND PAINT PER FINISH PLANS
8	(E) CMU TO REMAIN. PROTECT AND REPAINT
9	DEMO (E) WALL IN ITS ENTIRETY
10	DEMO (E) DOOR AND HOLLOW METAL FRAME IN ITS ENTIRETY
11	DEMO (E) HOLLOW METAL FRAME IN ITS ENTIRETY
12	DEMO (E) CMU IN ITS ENTIRETY
13	DEMO (E) WOOD SILL. RE: FINISH PLANS FOR NEW WINDOW SILL
14	DEMO (E) ROLLER SHADE. RE: FINISH SCHEDULE FOR NEW ROLLER SHADE(S)
15	REMOVE & SALVAGE (E) WHITEBOARD AND HAND OVER TO OWNER
16	(E) FINISHES TO REMAIN. PROTECT DURING CONSTRUCTION. RE: ADD ALTERNATES FOR SCOPE RELATED TO THIS AREA
17	SEE ADD ALTERNATE FOR REPLACEMENT OF THIS EXISTING DOOR PANEL
20	(E) HM FRAMES AND DOORS TO REMAIN. PROTECT DURING CONSTRUCTION. REPAINT FRAMES PER FINISH PLANS.

ARCHITECT
Hord Coplan Macht, Inc.
1850 Wazee Street, Suite 450
Denver, CO 80202
ph: 303.607.0877
URL: www.hcm2.com


M/E/P ENGINEER
Cator, Ruma and Associates, Co.
896 Tabor Street
Lakewood, CO 80401
p. 303-232-6200
URL: www.catoruma.com

AV / IT
NVS
2650 18th St #202
Denver, CO 80211
ph: 303-220-6400
URL: www.nv5.com

**COLORADO MOUNTAIN COLLEGE
NURSING RENOVATION**

3000 Co Rd 114, Glenwood Springs, CO 81601

hord | coplan | macht
ARCHITECTURE
LANDSCAPE ARCHITECTURE
PLANNING
INTERIOR DESIGN

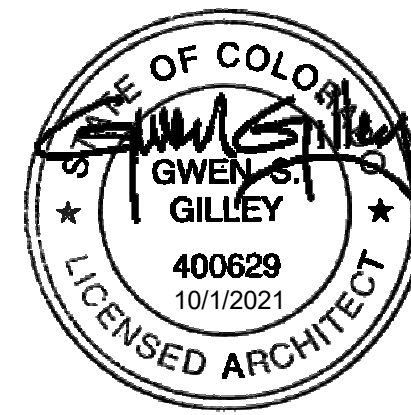

No. Date Revision

Project Name
NURSING RENOVATION

Project Number
22172.00

Date (YYYY/MM/DD)
10-01-2021

Drawn By
HRM

Checked By
SPD

Drawing
DEMOLITION FLOOR PLAN

AD111

CONTRACT DOCUMENTS

© Hord Coplan Macht, Inc.

A1 | D Level 00
A-301 AD111 3/16" = 1'-0"

DEMOLITION RCP
GENERAL NOTES

1. REMOVE ALL CEILINGS (SOFFITS, LIGHT FIXTURES, ETC.) SHOWN DASHED - FIELD VERIFY CONSTRUCTION OF ALL CEILINGS TO BE REMOVED - PROVIDE SHORING AND BRACING AS REQUIRED.
2. REFER TO MEP AND AV/IT DRAWINGS FOR ADDITIONAL INFORMATION.
3. REMOVE AND SALVAGE ALL LIGHT FIXTURES, GRILLS AND RETURNS AND TURN OVER TO OWNER OR REINSTALL AS INDICATED.
4. REMOVE STAPLES, NAILS AND SCREWS FROM CEILINGS AND SOFFITS, TYPICAL THROUGHOUT.
5. REMOVE AND SALVAGE ALL CEILING MOUNTED EQUIPMENT (PROJECTORS, PULL DOWN SCREENS, SPEAKERS, ETC). TURN OVER TO OWNER FOR REINSTALL AS INDICATED. SHOULD REMOVAL NOT BE NECESSARY, COVER AND PROTECT ELEMENTS DURING CONSTRUCTION.

SHEET NOTES - DEMO RCP

NOTE #	NOTE
1	REMOVE GYPSUM CEILING AND FIXTURES IN SHOWER AREA. CEILING IN RESTROOM AREA TO REMAIN.
2	DEMO (E) ACOUSTICAL CEILING GRID AND SALVAGE CEILING TILES TO BE RE-USED FOR NEW CEILING SYSTEM. RE: MEP & TECH DRAWINGS FOR ALL DEVICES TO BE REMOVED
3	(E) ACOUSTICAL CEILING TILE TO REMAIN

ARCHITECT
Hord Coplan Macht, Inc.
1802 Wazee Street, Suite 450
Denver, CO 80202
ph: 303.607.0877
URL: www.hcm2.com

ME/P ENGINEER
Cator, Ruma and Associates, Co.
896 Tabor Street
Lakewood, CO 80401
p. 303-232-6200
URL: www.catoruma.com

AV / IT
NV5
2650 18th Sty #202
Denver, CO 80211
ph: 303-220-6400
URL: www.nv5.com

COLORADO MOUNTAIN COLLEGE
NURSING RENOVATION

3000 Co Rd 114, Glenwood Springs, CO 81601

hord | coplan | macht
ARCHITECTURE
LANDSCAPE ARCHITECTURE
PLANNING
INTERIOR DESIGN



No.	Date	Revision

Project Name
NURSING RENOVATION

Project Number
22172.00


Date (YYYY/MM/DD)
10-01-2021


Drawn By
SPD

Checked By
HRM




Drawing
DEMOLITION CEILING PLAN

AD151

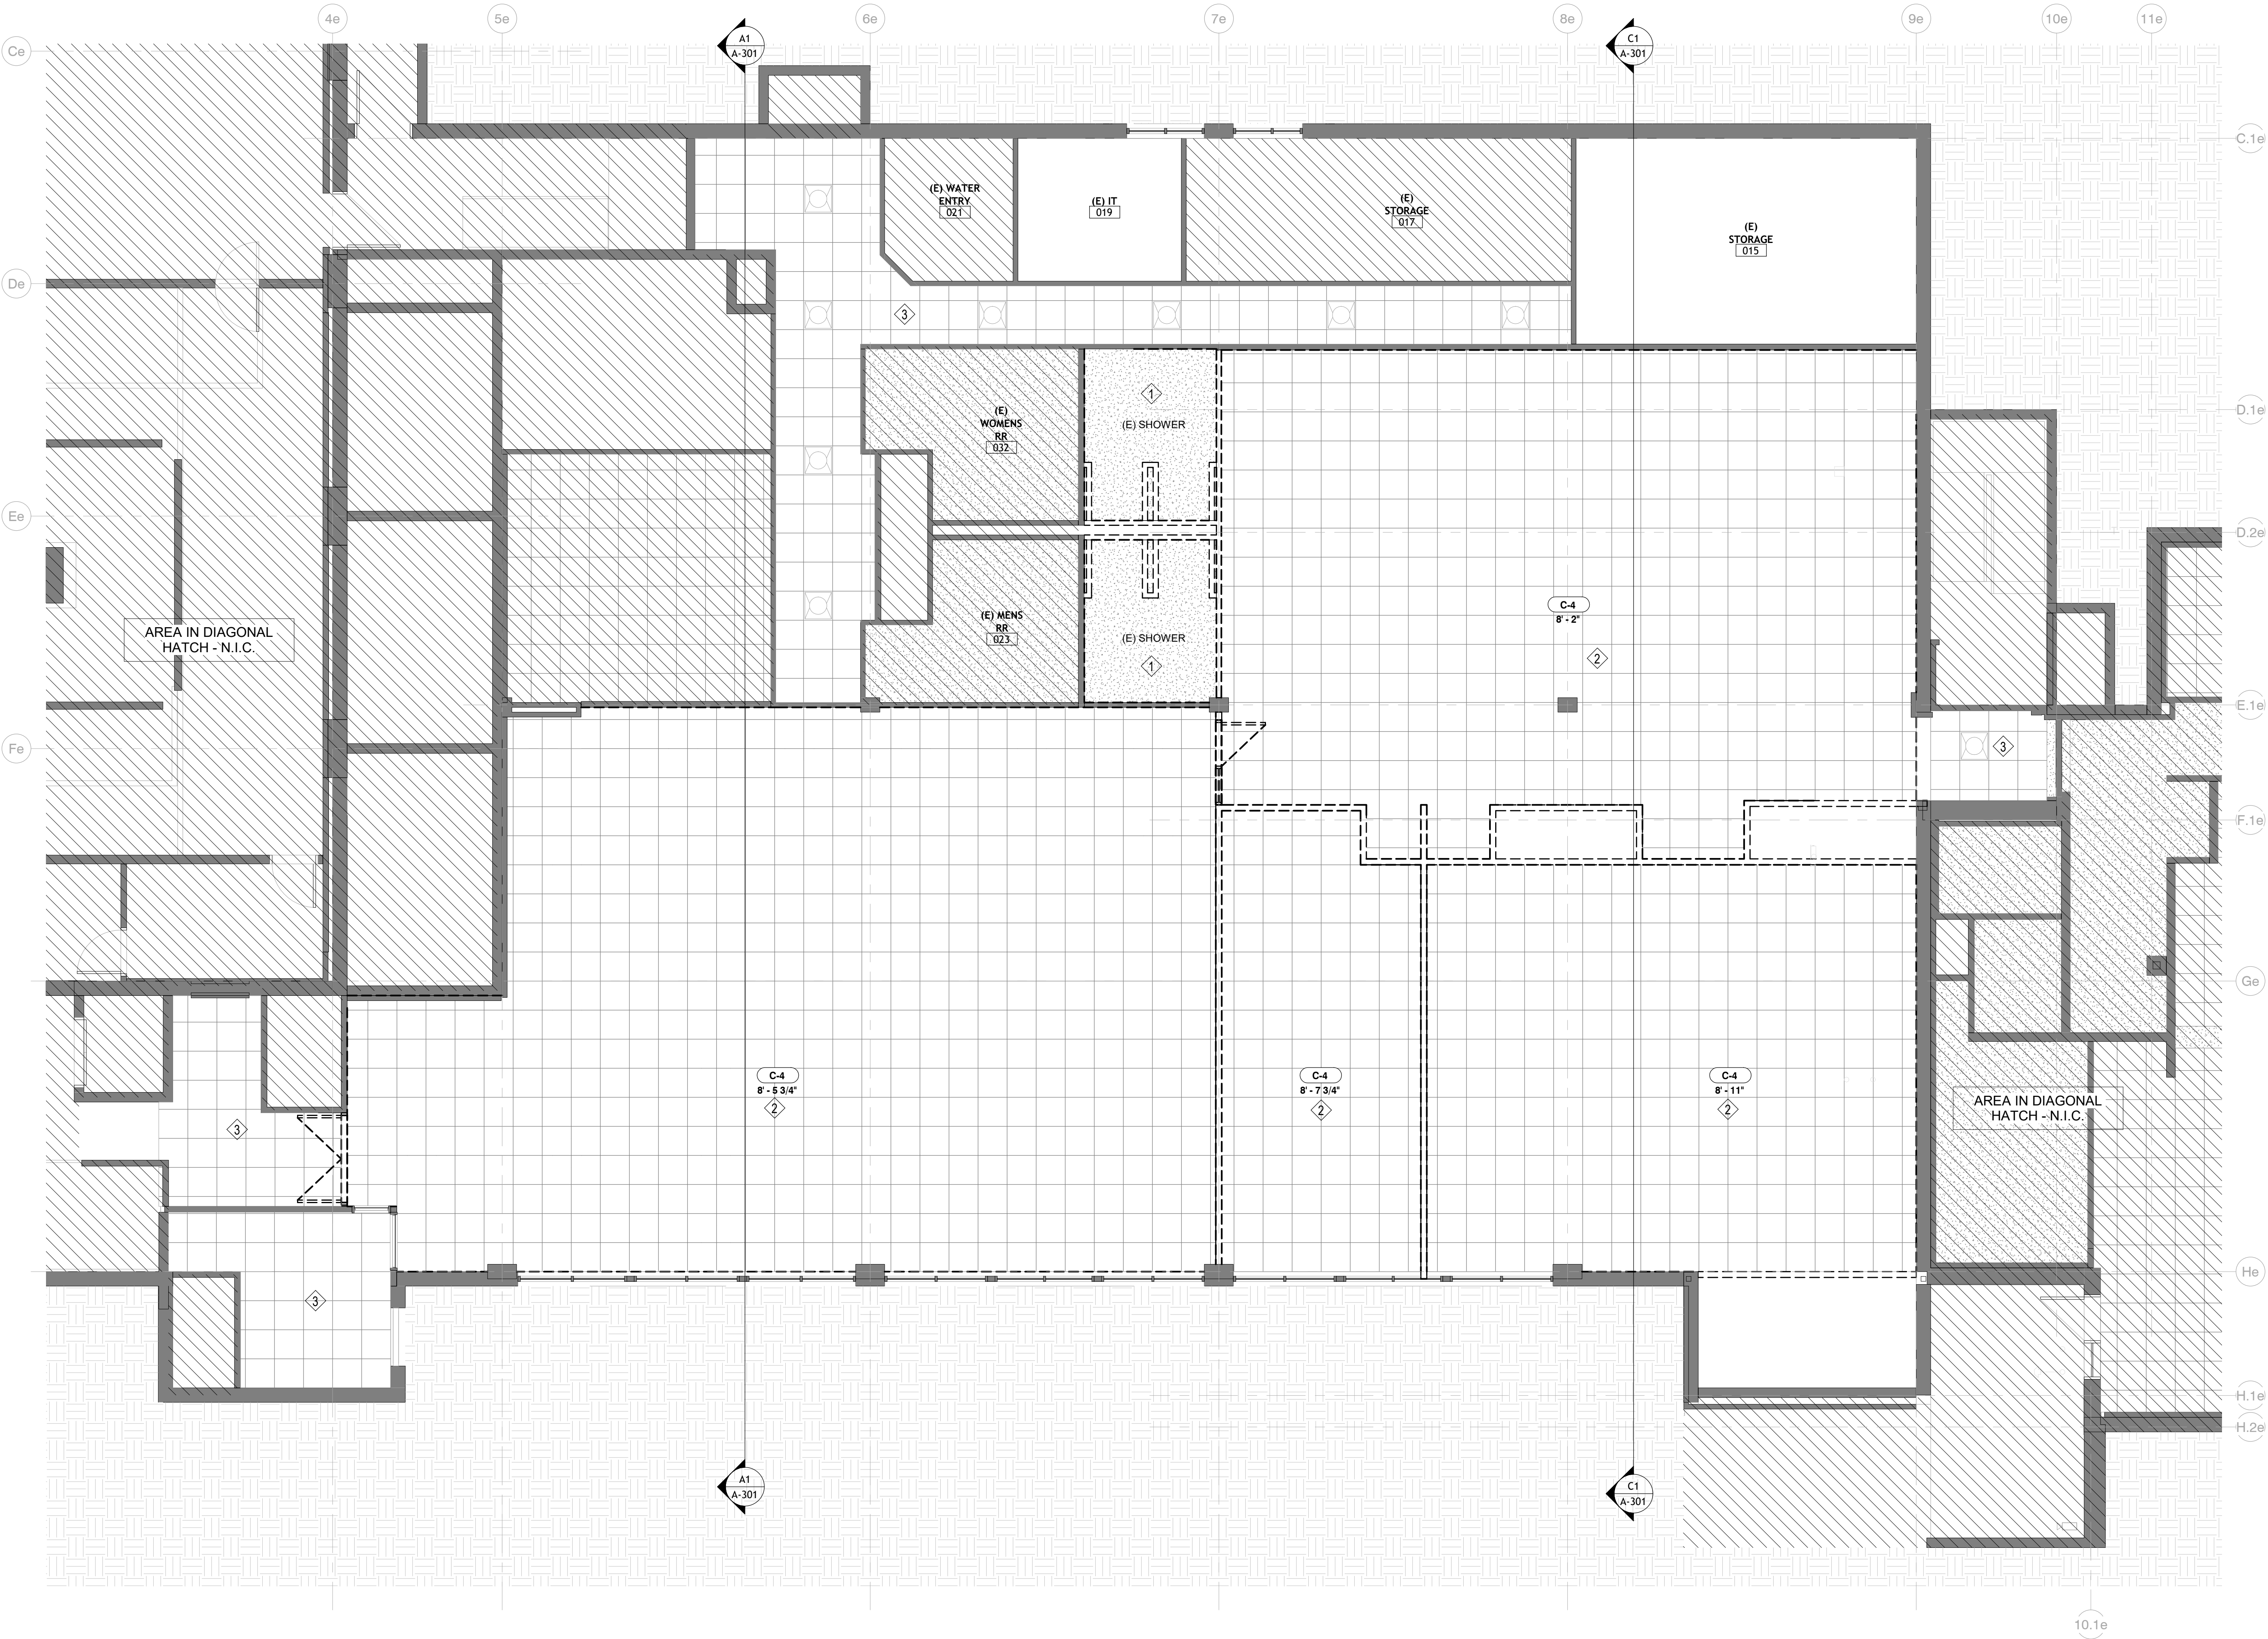

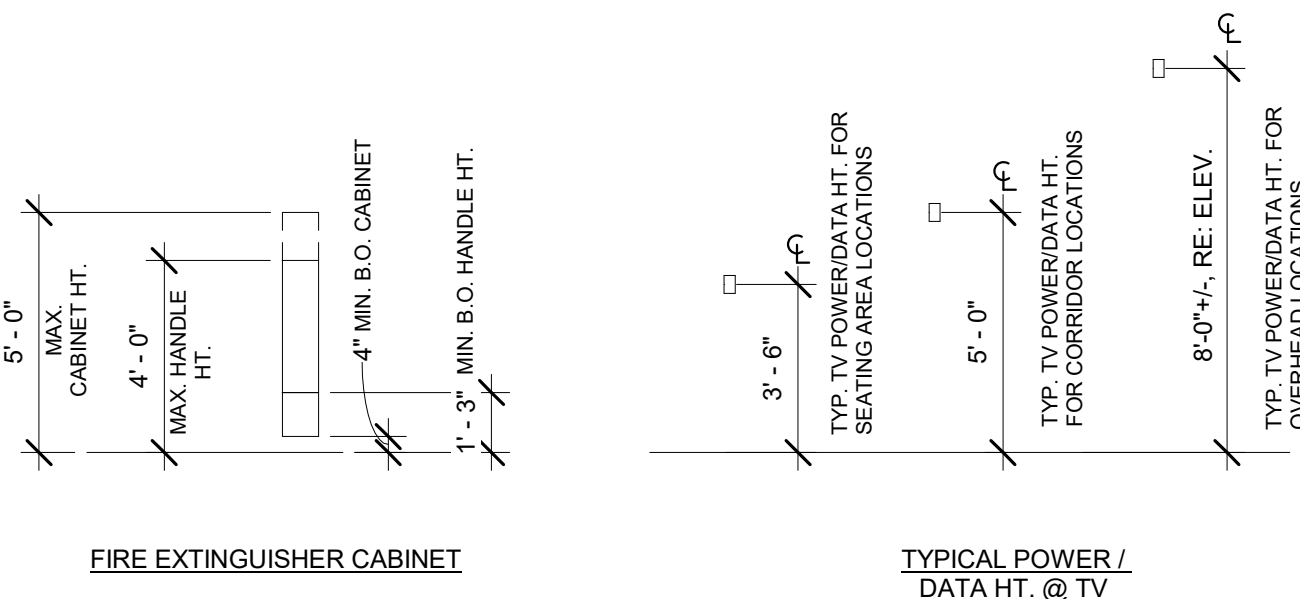

LIMITS ON PROTRUDING OBJECTS

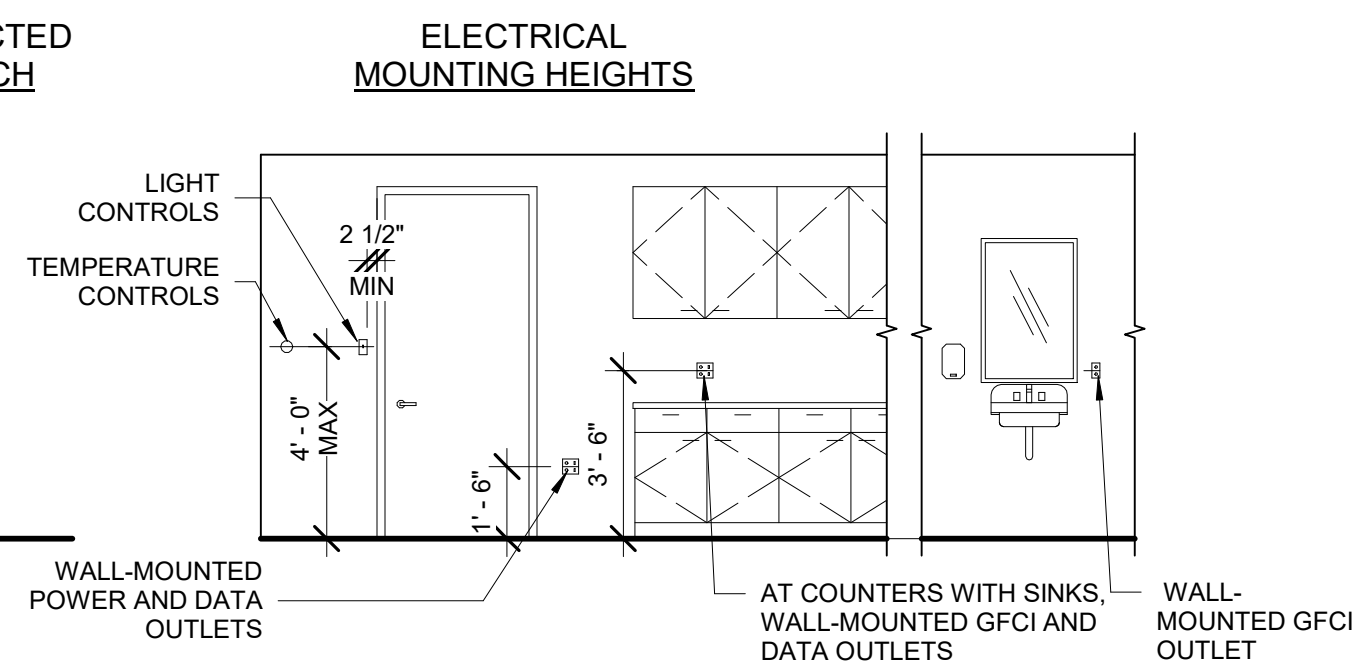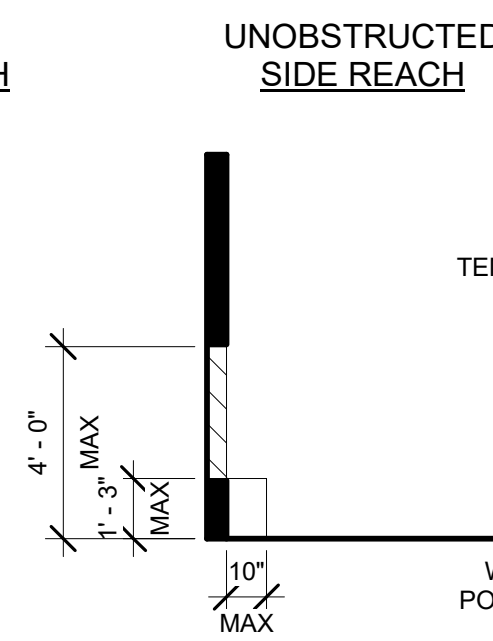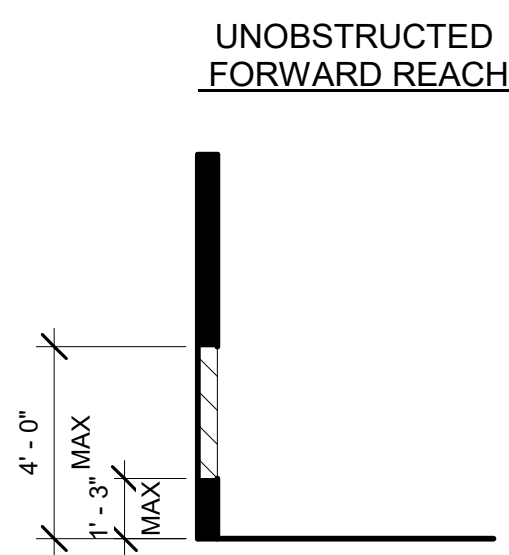

ARCHITECT
Hard Coplan Macht, Inc.
100 Wazee Street, Suite 450
Denver, CO 80202
P: 303.607.0977
RL: www.hcm2i.com


INTERIOR ENGINEER
Cattor, Ruma and Associates, Co.
16 Tabor Street
Keewood, CO 80401
P: 303-232-6200
RL: www.cattorruma.com

/// IT
nv5
500 18th Sty #202
Denver, CO 80211
P: 303-220-6400
RL: www.nv5.com

NURSING RENOVATION
3000 Co Rd 114, Glenwood Springs, CO 81601

3000 Co Rd 114, Glenwood Springs, CO 81601

ARCHITECTURE
LANDSCAPE ARCHITECTURE
PLANNING
INTERIOR DESIGN

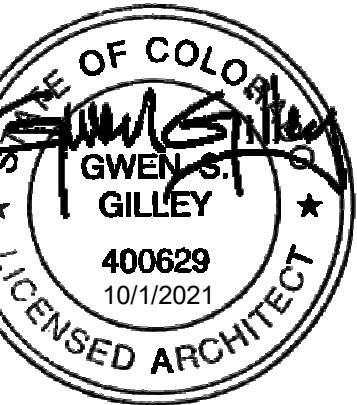[illegible]

No.	Date	Revision
-----	------	----------

Project Name _____
NURSING RENOVATION

Project Number 2172.00

0-01-2021

Drawn By _____ Checked By _____
PD HRM

TYPICAL MOUNTING HEIGHTS

A-001

CONTRACT DOCUMENTS

Lord Coplan Macht, Inc.

NOTE #	NOTE
1	(E) HM FRAMES AND DOORS TO REMAIN. PROTECT DURING CONSTRUCTION. REPAIR FRAMES PER FINISH PLANS.
4	FABRICATED PAINTED METAL BOLLARDS FOR ELECTRICAL CLEARANCE. RE: DETAIL ON A-511
5	NEW WINDOW SILL AT ALL EXTERIOR WINDOWS IN SCOPE AREA, RE: B1 / A-511
6	(E) HM WINDOWS TO REMAIN. RE: FINISH PLAN FOR UPDATED FINISH.
A1	ADD ALTERNATE - RE: ADD ALTERNATE FLOOR PLAN FOR DETAILS

- ARCHITECT**
Hord Coplan Macht, Inc.
1800 Wazee Street, Suite 450
Denver, CO 80202
ph: 303.607.0977
URL: www.hcm2i.com
- M/E/P ENGINEER**
Cator, Rummen and Associates, Co.
896 Talbot Street
Lakewood, CO 80401
p. 303-232-6200
URL: www.catorrumma.com
- AV / IT**
NV5
2650 18th Sty #202
Denver, CO 80211
ph. 303-220-6400
URL: www.nv5.com

3000 Co Rd 114, Glenwood Springs, CO 81601

ARCHITECTURE
LANDSCAPE ARCHITECTURE
PLANNING
INTERIOR DESIGN

[illegible]

Project Name
NURSING RENOVATION

Project Number
22172.00

Date (YYYY/MM/DD)
10-01-2021

 
Drawn By
SPD

Checked By
HRM

Drawing
**OVERALL FLOOR PLAN -
BASE SCOPE**

CONTRACT DOCUMENTS

© Hord Coplan Macht, Inc.



A1 OVERALL FLOOR PLAN
3/16" = 1'-0"

SHEET NOTES - CONSTRUCTION PLANS

NOTE #	NOTE
1	(E) HM FRAMES AND DOORS TO REMAIN. PROTECT DURING CONSTRUCTION. REPAINT FRAMES PER FINISH PLANS.
4	FABRICATED PAINTED METAL BOLLARDS FOR ELECTRICAL CLEARANCE. RE: DETAIL ON A-511
5	NEW WINDOW SILL AT ALL EXTERIOR WINDOWS IN SCOPE AREA. RE: B1 / A-511
6	(E) HM WINDOWS TO REMAIN. RE: FINISH PLAN FOR UPDATED FINISH.
A1	ADD ALTERNATE - RE: ADD ALTERNATE FLOOR PLAN FOR DETAILS

FLOOR PLAN GENERAL NOTES

- DIMENSIONS INDICATED ARE TO FACE OF FINISH MATERIAL OF PARTITION OR WALL AND GRID LINES. UCN
- REFER TO FINISH PLANS FOR FLOOR PATTERNS.
- REFER TO SHEET (A-010) FOR PARTITION TYPE INFORMATION
- REFER TO FINISH PLANS FOR ACCESSORY SCHEDULE AND LOCATIONS.
- PROVIDE BLOCKING AT ALL WALL-MOUNTED ACCESSORIES (GRAB BARS, ETC), HARDWARE WHERE REQUIRED AND WALL-HUNG CABINETS.
- VERIFY & COORDINATE ALL REQUIREMENTS FOR OWNER FURNISHED ITEMS PRIOR TO PERFORMANCE OF WORK THAT MAY INTERFACE WITH SUCH ITEMS.
- PROVIDE PAINTED ACCESS PANELS IN WALLS & CEILINGS AT CONCEALED ITEMS, SUCH AS VALVES, CONTROLS, SWITCHES OR ANY OTHER ITEMS THAT REQUIRES ACCESS. GC TO DETERMINE ACCESS PANEL LOCATION W/ ARCHITECT PRIOR TO INSTALLATION.
- REFER TO ALTERNATE FLOOR PLAN FOR ALTERNATE SCOPE DESCRIPTIONS.

ARCHITECT
Hord Coplan Macht, Inc.
1850 Wazee Street, Suite 450
Denver, CO 80202
ph: 303.607.0877
URL: www.hcm2.com

M/E/P ENGINEER
Cator, Ruma and Associates, Co.
890 Tabor Street
Lakewood, CO 80401
p. 303-232-6200
URL: www.catoruma.com

AV / IT
NV5
2650 18th Sty #202
Denver, CO 80211
ph. 303-220-6400
URL: www.nv5.com

COLORADO MOUNTAIN COLLEGE
NURSING RENOVATION

3000 Co Rd 114, Glenwood Springs, CO 81601

hord | coplan | macht
ARCHITECTURE
LANDSCAPE ARCHITECTURE
PLANNING
INTERIOR DESIGN



No.	Date	Revision

Project Name
NURSING RENOVATION

Project Number
22172.00

Date (YYYY/MM/DD)
10-01-2021

Drawn By
SPD


Checked By
HRM

Drawing
OVERALL DIMENSION PLAN

A-101.1

CONTRACT DOCUMENTS

© Hord Coplan Macht, Inc.

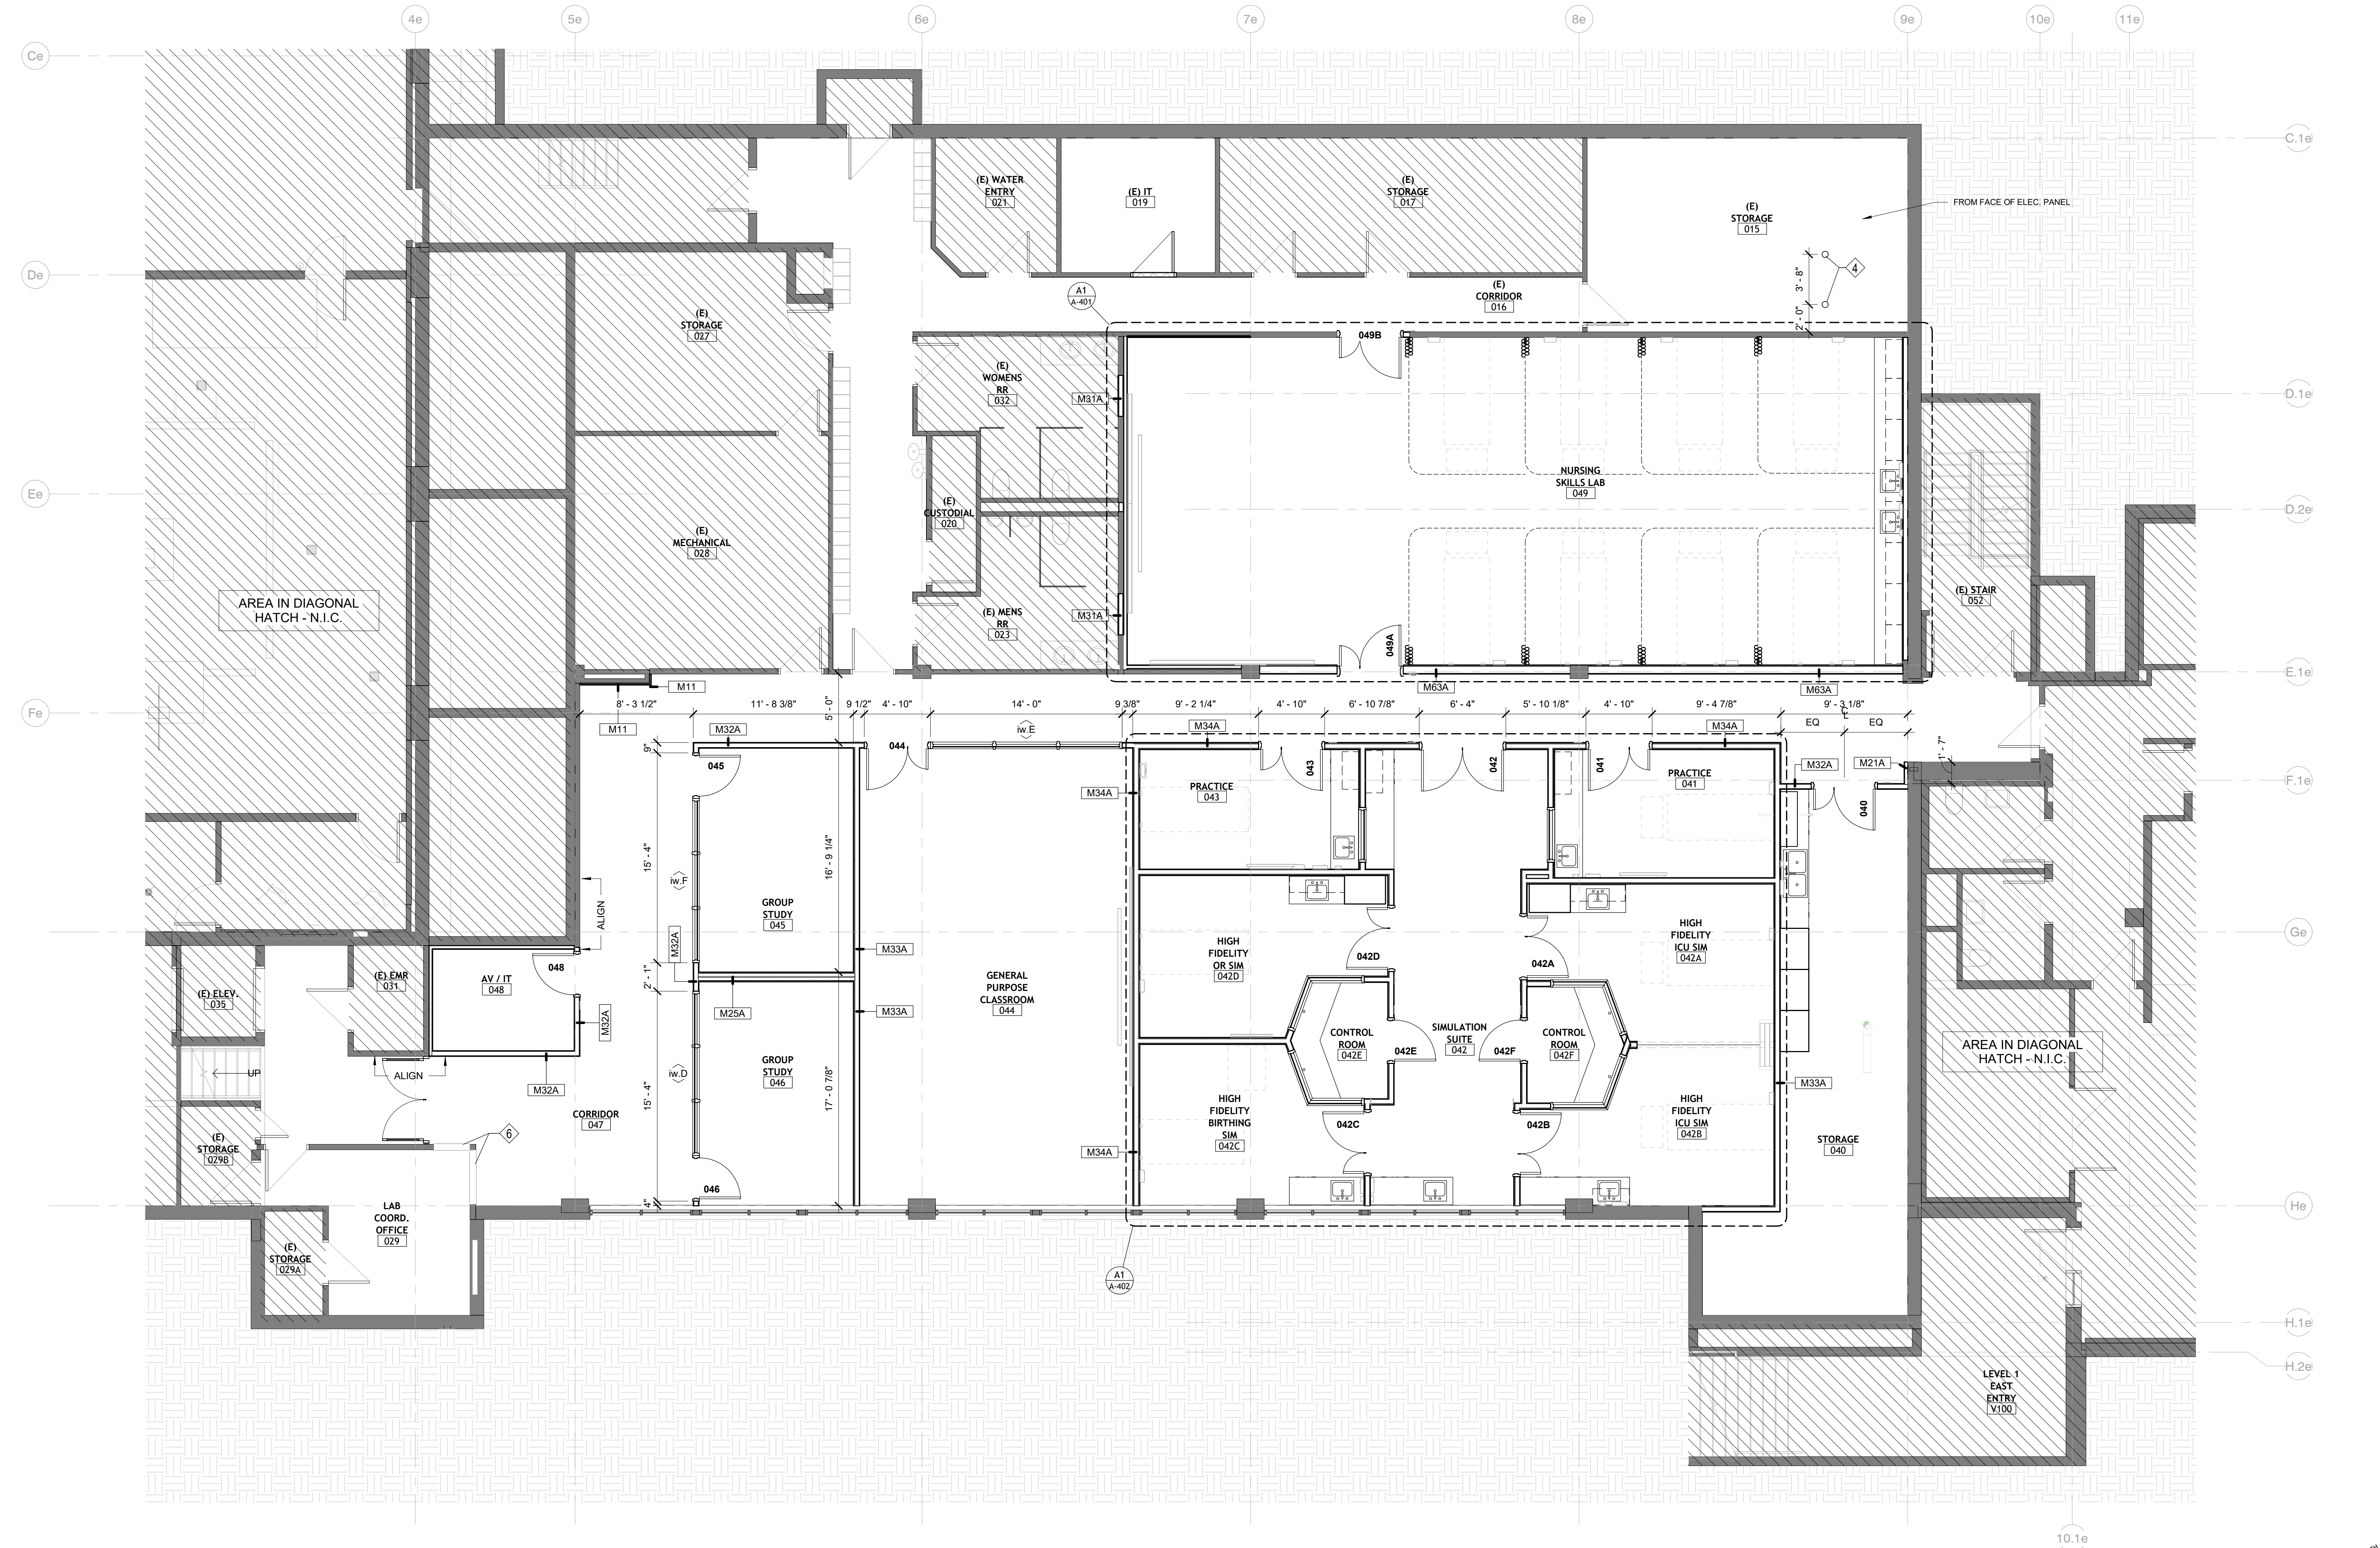


A1 OVERALL DIMENSION PLAN
3/16" = 1'-0"

ADD ALTERNATE SCOPE:

- PROVIDE NEW LVT FLOORING AT CORRIDOR(S)
- PROVIDE NEW RUBBER BASE AT ALL WALLS
- PATCH EXISTING DRYWALL AND PAINT ALL WALLS AND HOLLOW METAL FRAMES

© 2010 Blackwell Publishing Ltd

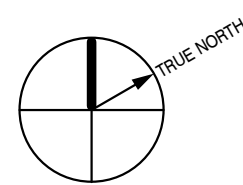

BIM 350 (221 170.00) CMC Nursing Sim Spring/221 170.00 CMC Nursing Sim Spring_Central_R20.NT

FINISH LEGEND

CSI SECTION NUMBER	CSI SECTION NAME	TYPE	CODE	MANUFACTURER	PRODUCT	SIZE	COLOR	REMARKS
DIVISION 6								
06 4116	PLASTIC-LAMINATE-FACED ARCHITECTURAL CABINETS	PLASTIC-LAMINATE CASEWORK	PL-1	WILSONART	HPL	-	10776-60 KENSINGTON MAPLE	USE MATCHING 3MM PVC EDGEBANDING.
DIVISION 9								
09 6500	RUBBER STAIR TREADS AND NOSING	RUBBER STAIR TREADS AND NOSING	RBR-1	JOHNSONITE	RUBBER STAIR TREAD WITH INTEGRATED RISER	-	28 MEDIUM GREY	
09 6513	RESILIENT BASE AND ACCESSORIES	RESILIENT BASE	RB-1	JOHNSONITE	BASEWORKS THERMOSET RUBBER WALL BASE	4" COVE, ROLLED GOODS	28 MEDIUM GREY	USE PRE-FORMED INSIDE AND OUTSIDE CORNERS.
09 6516	RESILIENT SHEET FLOORING	WELDED SEAM SHEET FLOORING	WSF-1	GERFLOR	MIPOLAM MYBIOZ	6" ROLL	6010 MYST	WELD ROD: 05070626; SUBMIT SEAMING DIAGRAM.
09 6519	RESILIENT TILE FLOORING	LUXURY VINYL TILE	LVT-1	ARMSTRONG	DUO SPETTRO W/ DIAMOND 10 TECHNOLOGY	18" X 36"	ST2PR ENGLISH GREY W/ BLUE HAWAIIAN / BLUE LAGOON	PATTERN: STAGGER; CONDUCT RH TESTING PRIOR TO ORDERING ADHESIVE.
09 6519		LUXURY VINYL TILE	LVT-2	ARMSTRONG	DUO MIXER 2 W/ DIAMOND 10 TECHNOLOGY	6" X 36"	ST2S2 BLUE HAWAIIAN	PATTERN: STAGGER; CONDUCT RH TESTING PRIOR TO ORDERING ADHESIVE.
09 6519		LUXURY VINYL TILE	LVT-3	ARMSTRONG	DUO MIXER 2 W/ DIAMOND 10 TECHNOLOGY	6" X 36"	ST526 APPLTINI	PATTERN: STAGGER; CONDUCT RH TESTING PRIOR TO ORDERING ADHESIVE.
09 6813	TILE CARPETING	CARPET TILE	CPT-1	MOHAWK	GT405 COLOR BALANCE TILE	12" X 36"	959 BEDROCK	PATTERN: ASHLAR; CONDUCT RH TESTING PRIOR TO ORDERING ADHESIVE.
09 7200	WALL COVERINGS	VINYL WALL COVERING (CUSTOM GRAPHIC)	VWC-1	MDC	DREAMSCAPE SMOOTH MATTE, SUEDE, ARTIST CANVAS	RE: INTERIOR ELEVATIONS	-	CUSTOM GRAPHIC.
09 7200		VINYL WALL COVERING (CUSTOM GRAPHIC - CMU)	VWC-2	3M	SCOTCHAL OVERLAMINATE, MATTE	RE: INTERIOR ELEVATIONS	-	CUSTOM GRAPHIC.
09 9123	INTERIOR PAINTING	PAINT (FIELD)	P-1	SHERWIN WILLIAMS	SEMI-GLOSS	-	SW 7004 SNOWBOUND	
09 9123		PAINT (CEILING)	P-2	SHERWIN WILLIAMS	FLAT (EGGSHELL AT TOILET ROOMS)	-	SW 7004 SNOWBOUND	
09 9123		PAINT (DOOR FRAME & STAIR RAILING)	P-3	SHERWIN WILLIAMS	SEMI-GLOSS	-	SW 7074 SOFTWARE	PAINT ALL EXISTING DOOR FRAMES IN AREA OF WORK.
09 9123		PAINT (ACCENT)	P-4	SHERWIN WILLIAMS	SEMI-GLOSS	-	SW 6417 TUPELO TREE	
09 9123		PAINT (ACCENT)	P-5	SHERWIN WILLIAMS	SEMI-GLOSS	-	SW 6501 MANITOU BLUE	
09 9123		PAINT (ACCENT)	P-6	SHERWIN WILLIAMS	SEMI-GLOSS	-	SW 6509 GEORGIAN BAY	
09 9123		PAINT (ACCENT)	P-7	SHERWIN WILLIAMS	SEMI-GLOSS	-	SW 7072 ONLINE	
09 9123		PAINT (ACCENT)	P-8	SHERWIN WILLIAMS	SEMI-GLOSS	-	SW 7703 EARTHEN JUG	
09 9300	STAINING AND TRANSPARENT FINISHING	WOOD DOOR STAIN	S-1	-	-	-	CLEAR	MATCH FACILITY STANDARD DOORS, WHITE MAPLE, RE: SPECIFICATIONS.
DIVISION 10								
10 1100	VISUAL DISPLAY UNITS	PORCELAIN MARKERBOARD	VD-1	TBD	TBD	4" X 8'	TBD	
10 2123	CUBICLE CURTAINS AND TRACK	CUBICLE CURTAINS AND TRACK	CC-1	RE: SPECS	RE: SPECS	RE: SPECS	TBD	
10 2239	FOLDING PANEL PARTITIONS	CORNER GUARDS	FP-1	RE: SPECS	RE: SPECS	RE: SPECS	TBD	
10 2600	WALL AND DOOR PROTECTION	CORNER GUARDS	CG-1	INPRO	STAINLESS STEEL CORNER GUARD	48" H, 2" WINGS	-	ALL OUTSIDE CORNERS WITHIN SCOPE AREA.
10 2600	WALL AND DOOR PROTECTION	IMPACT-RESISTANT WALL COVERING	WP-1	INPRO	1400 WALL GUARD	4" H	TBD	PERIMETER OF CLASSROOMS, 30" AFF.
10 5123	PLASTIC-LAMINATE-CLAD LOCKERS	PLASTIC-LAMINATE LOCKERS	PL-2	FORMICA	STANDARD HPL	-	914 MARINE BLUE	INCLUDE DIGITAL OR COMBINATION LOCKS. CONFIRM WITH OWNER.
DIVISION 12								
12 2413	ROLLER WINDOW SHADES	MANUAL ROLLER WINDOW SHADES	RWS-1	TBD	MANUAL-OPERATED SINGLE ROLLER, LIGHT FILTERING FABRIC (3%)	-	MATCH EXISTING	
12 2413	ROLLER WINDOW SHADES	MANUAL ROLLER WINDOW SHADES	RWS-2	TBD	MANUAL-OPERATED DUAL ROLLER, LIGHT FILTERING FABRIC (3%) / BLACKOUT	-	MATCH EXISTING	
12 3623.13	PLASTIC-LAMINATE COUNTERTOPS	PLASTIC-LAMINATE COUNTERTOP (CHEMICAL RESISTANT)	PL-3	WILSONART	CHEMSURF CHEMICAL-RESISTANT LAMINATE	0.034" THICK	1573 FROSTY WHITE	SELF EDGE IN CHEMSURF LAMINATE.
12 3623.13	PLASTIC-LAMINATE-CLAD COUNTERTOPS	PLASTIC-LAMINATE COUNTERTOP	PL-4	WILSONART	HPL	-	1573 FROSTY WHITE	USE MATCHING 3MM PVC EDGEBANDING; USE AT WINDOW SILLS.

ROOM FINISH SCHEDULE

ROOM NUMBER	ROOM NAME	FINISH			MILLWORK		REMARKS
		FLOOR	BASE	WALL	HORIZ.	VERT.	
015	(E) STORAGE	EXISTING	EXISTING	EXISTING			ADD/ALT FINISH UPGRADE
016	(E) CORRIDOR	EXISTING	EXISTING	EXISTING			ADD/ALT FINISH UPGRADE
019	(E) IT	EXISTING	EXISTING	EXISTING			NEW PL-2 LOCKERS ADD/ALT. RE: INTERIOR ELEVATIONS.
029	LAB COORD. OFFICE	EXISTING	EXISTING	EXISTING			ADD/ALT FINISH UPGRADE
040	STORAGE	WSF-1	RB-1	P-1	PL-4	PL-1	
041	PRACTICE	WSF-1	RB-1	P-1, WP-2	PL-3	PL-1	
042	SIMULATION SUITE	WSF-1	RB-1	P-1, P-5, P-7	PL-4	PL-1	RSW-1 AT EXTERIOR WINDOWS.
042A	HIGH FIDELITY ICU SIM	WSF-1	RB-1	P-1, WP-2	PL-3	PL-1	
042B	HIGH FIDELITY ICU SIM	WSF-1	RB-1	P-1, WP-2	PL-3	PL-1	RSW-2 AT EXTERIOR WINDOW.
042C	HIGH FIDELITY BIRTHING SIM	WSF-1	RB-1	P-1, WP-2	PL-3	PL-1	RSW-2 AT EXTERIOR WINDOWS.
042D	HIGH FIDELITY DR SIM	WSF-1	RB-1	P-1, WP-2	PL-3	PL-1	
042E	CONTROL ROOM	WSF-1	RB-1	P-7	PL-4	-	
042F	CONTROL ROOM	WSF-1	RB-1	P-7	PL-4	-	
043	PRACTICE	WSF-1	RB-1	P-1, WP-2	PL-3	PL-1	
044	GENERAL PURPOSE CLASSROOM	CPT-1	RB-1	P-1, P-5, P-6, WP-1			EXISTING ROLLER SHADES TO REMAIN: WP-1 FULL PERIMETER.
045	GROUP STUDY	CPT-1	RB-1	P-1, P-4			
046	GROUP STUDY	CPT-1	RB-1	P-1, P-4			EXISTING ROLLER SHADES TO REMAIN.
047	CORRIDOR	CPT-1, LVT-1, LVT-2, LVT-3	RB-1	P-1, P-6, VWC-1, VWC-2			CUSTOM WALL GRAPHICS, RE: INTERIOR ELEVATIONS; EXISTING ROLLER SHADES TO REMAIN.
048	AV / IT	CPT-1	RB-1	P-1			
049	NURSING SKILLS LAB	WSF-1	RB-1	P-1, P-5, P-6, WP-1, WP-2	PL-3	PL-1	WP-1 FULL PERIMETER, CC-1 CURTAINS.
052	(E) STAIR	EXISTING	EXISTING	EXISTING			ADD/ALT FINISH UPGRADE
100B	(E) LOBBY	EXISTING	EXISTING	EXISTING			ADD/ALT FINISH UPGRADE
E-201	NORTH STAIR	EXISTING	EXISTING	EXISTING			ADD/ALT FINISH UPGRADE

ACCESSORY SCHEDULE

CSI DIV #	DESCRIPTION	TAG	QTY	REMARKS	FURNISHED	INSTALLED
102800	GLOVE DISPENSER	GD-01	14	PROVIDE BLOCKING	TBD	CONTRACTOR
102800	HAND SANITIZER DISPENSER	HS-01	14	PROVIDE BLOCKING	TBD	CONTRACTOR
101100	MARKERBOARD - 8'W X 4'H	MB-1	4	PROVIDE BLOCKING	CONTRACTOR	CONTRACTOR
101100	MARKERBOARD - 1'W X 2'H	MB-2	6	MOUNTED ON INTERIOR SIDE OF SECONDARY PANELS TO SIM LAB DOORS	CONTRACTOR	CONTRACTOR
101100	MARKERBOARD - 3'W X 5'H	MB-3	1	PROVIDE BLOCKING	CONTRACTOR	CONTRACTOR
101100	MARKERBOARD - 12'W X 4'H	MB-8	2	PROVIDE BLOCKING	CONTRACTOR	CONTRACTOR
102800	PAPER TOWEL DISPENSER	PT-01	10	PROVIDE BLOCKING	TBD	CONTRACTOR
102800	SHARPS CONTAINER	SC-01	14	PROVIDE BLOCKING	TBD	CONTRACTOR
102800	SOAP DISPENSER	SD-01	10	PROVIDE BLOCKING	TBD	CONTRACTOR

FINISH PLAN GENERAL NOTES

- ALL FLOOR MATERIALS TO BE BUTT JOINTED AT TRANSITIONS ON CENTER OF DOOR WHERE APPLICABLE. UNO. PROVIDE EDGE PROTECTION AND TRANSITION PROFILES WHERE FLOOR MATERIAL CHANGES AND/OR STOPS. REFER TO SPECIFICATIONS FOR ADDITIONAL INFORMATION.
- PAINT ALL EXPOSED PIPES, AIR GRILLES, ETC. TO MATCH ADJACENT WALL COLOR.
- ALL WALL MOUNTED CASEWORK, MILLWORK, HARDWARE, EQUIPMENT, ETC. SHALL BE ANCHORED TO METAL STRAPPING OR ½" FRT PLYWOOD BACKING BETWEEN STUDS, U.N.O. COORDINATE ACCORDINGLY.
- REFER TO OTHER DRAWINGS IN ADDITION TO THE FINISH PLANS AND KEYNOTE LEGEND FOR THE FULL EXTENT OF INTERIOR FINISHES.
- ALL FLOORING MATERIALS CONTINUE UNDER CASEWORK TO TOE KICK OR IF OPEN, TO WALL.

SHEET NOTES - FINISH PLANS

NOTE #	NOTE
1	ADD ALTERNATE #1: NEW WALL PAINT (P-1, P-6), RAILING/STRINGER/HM FRAMES PAINT (P-3), WALL BASE (RB-1), AND FLOORING (CPT-1).
2	ADD ALTERNATE #3: NEW WALL PAINT (P-1), HM FRAMES PAINT (P-3), WALL BASE (RB-1), AND FLOORING (CPT-1).
3	ADD/ALTERNATE #4: NEW PAINT (P-1), RAILING/STRINGER/HM FRAMES & DOORS PAINT (P-3), WALL BASE (RB-1), AND FLOORING (LVT-1).
4	ADD/ALTERNATE #11: NEW PAINT (P-1) ACCENT PAINT COLORS AT LOCKER WALLS, HM FRAMES PAINT (P-3), WALL BASE (RB-1), AND FLOORING (LVT-1).
5	ADD ALTERNATE #5: NEW WALL PAINT (P-1), RAILING/STRINGER/HM FRAMES PAINT (P-3), WALL BASE (RB-1), FLOORING (LVT-1), AND STAIR TREADS (RBR-1).
6	PROVIDE WALL TILE, PAINT AND BASE TO MATCH EXISTING AT INFILLED WALL OPENING.
7	ACCENT LVT BANDS ALIGN WITH CENTER OF COLUMNS.
8	ADD ALTERNATE #9
9	ADD ALTERNATE #10
10	PAINT (E) WINDOW FRAMES.
11	ADD/ALTERNATE #6: NEW P-LAM LOCKERS (PL-2).

FINISH SYMBOL LEGEND


- XXX WALL FINISH SYMBOL
- ◆ SHEET NOTE SYMBOL
- └ CORNER GUARD (CG)
- ≡ FLOOR TRANSITION SYMBOL
- NOT IN SCOPE

FLOOR FINISH LEGEND

- CARPET (CPT-1)
- RESILIENT TILE (LVT-1)
- RESILIENT TILE (LVT-2)
- RESILIENT TILE (LVT-3)
- RESILIENT SHEET (VSF-1)
- EXISTING TO REMAIN

FLOOR TRANSITION LEGEND

- TR-1 CARPET - RESILIENT FLOORING
- TR-2 CARPET - CONCRETE
- TR-3 RESILIENT FLOORING - CONCRETE
- TR-4 RESILIENT FLOORING - RESILIENT FLOORING

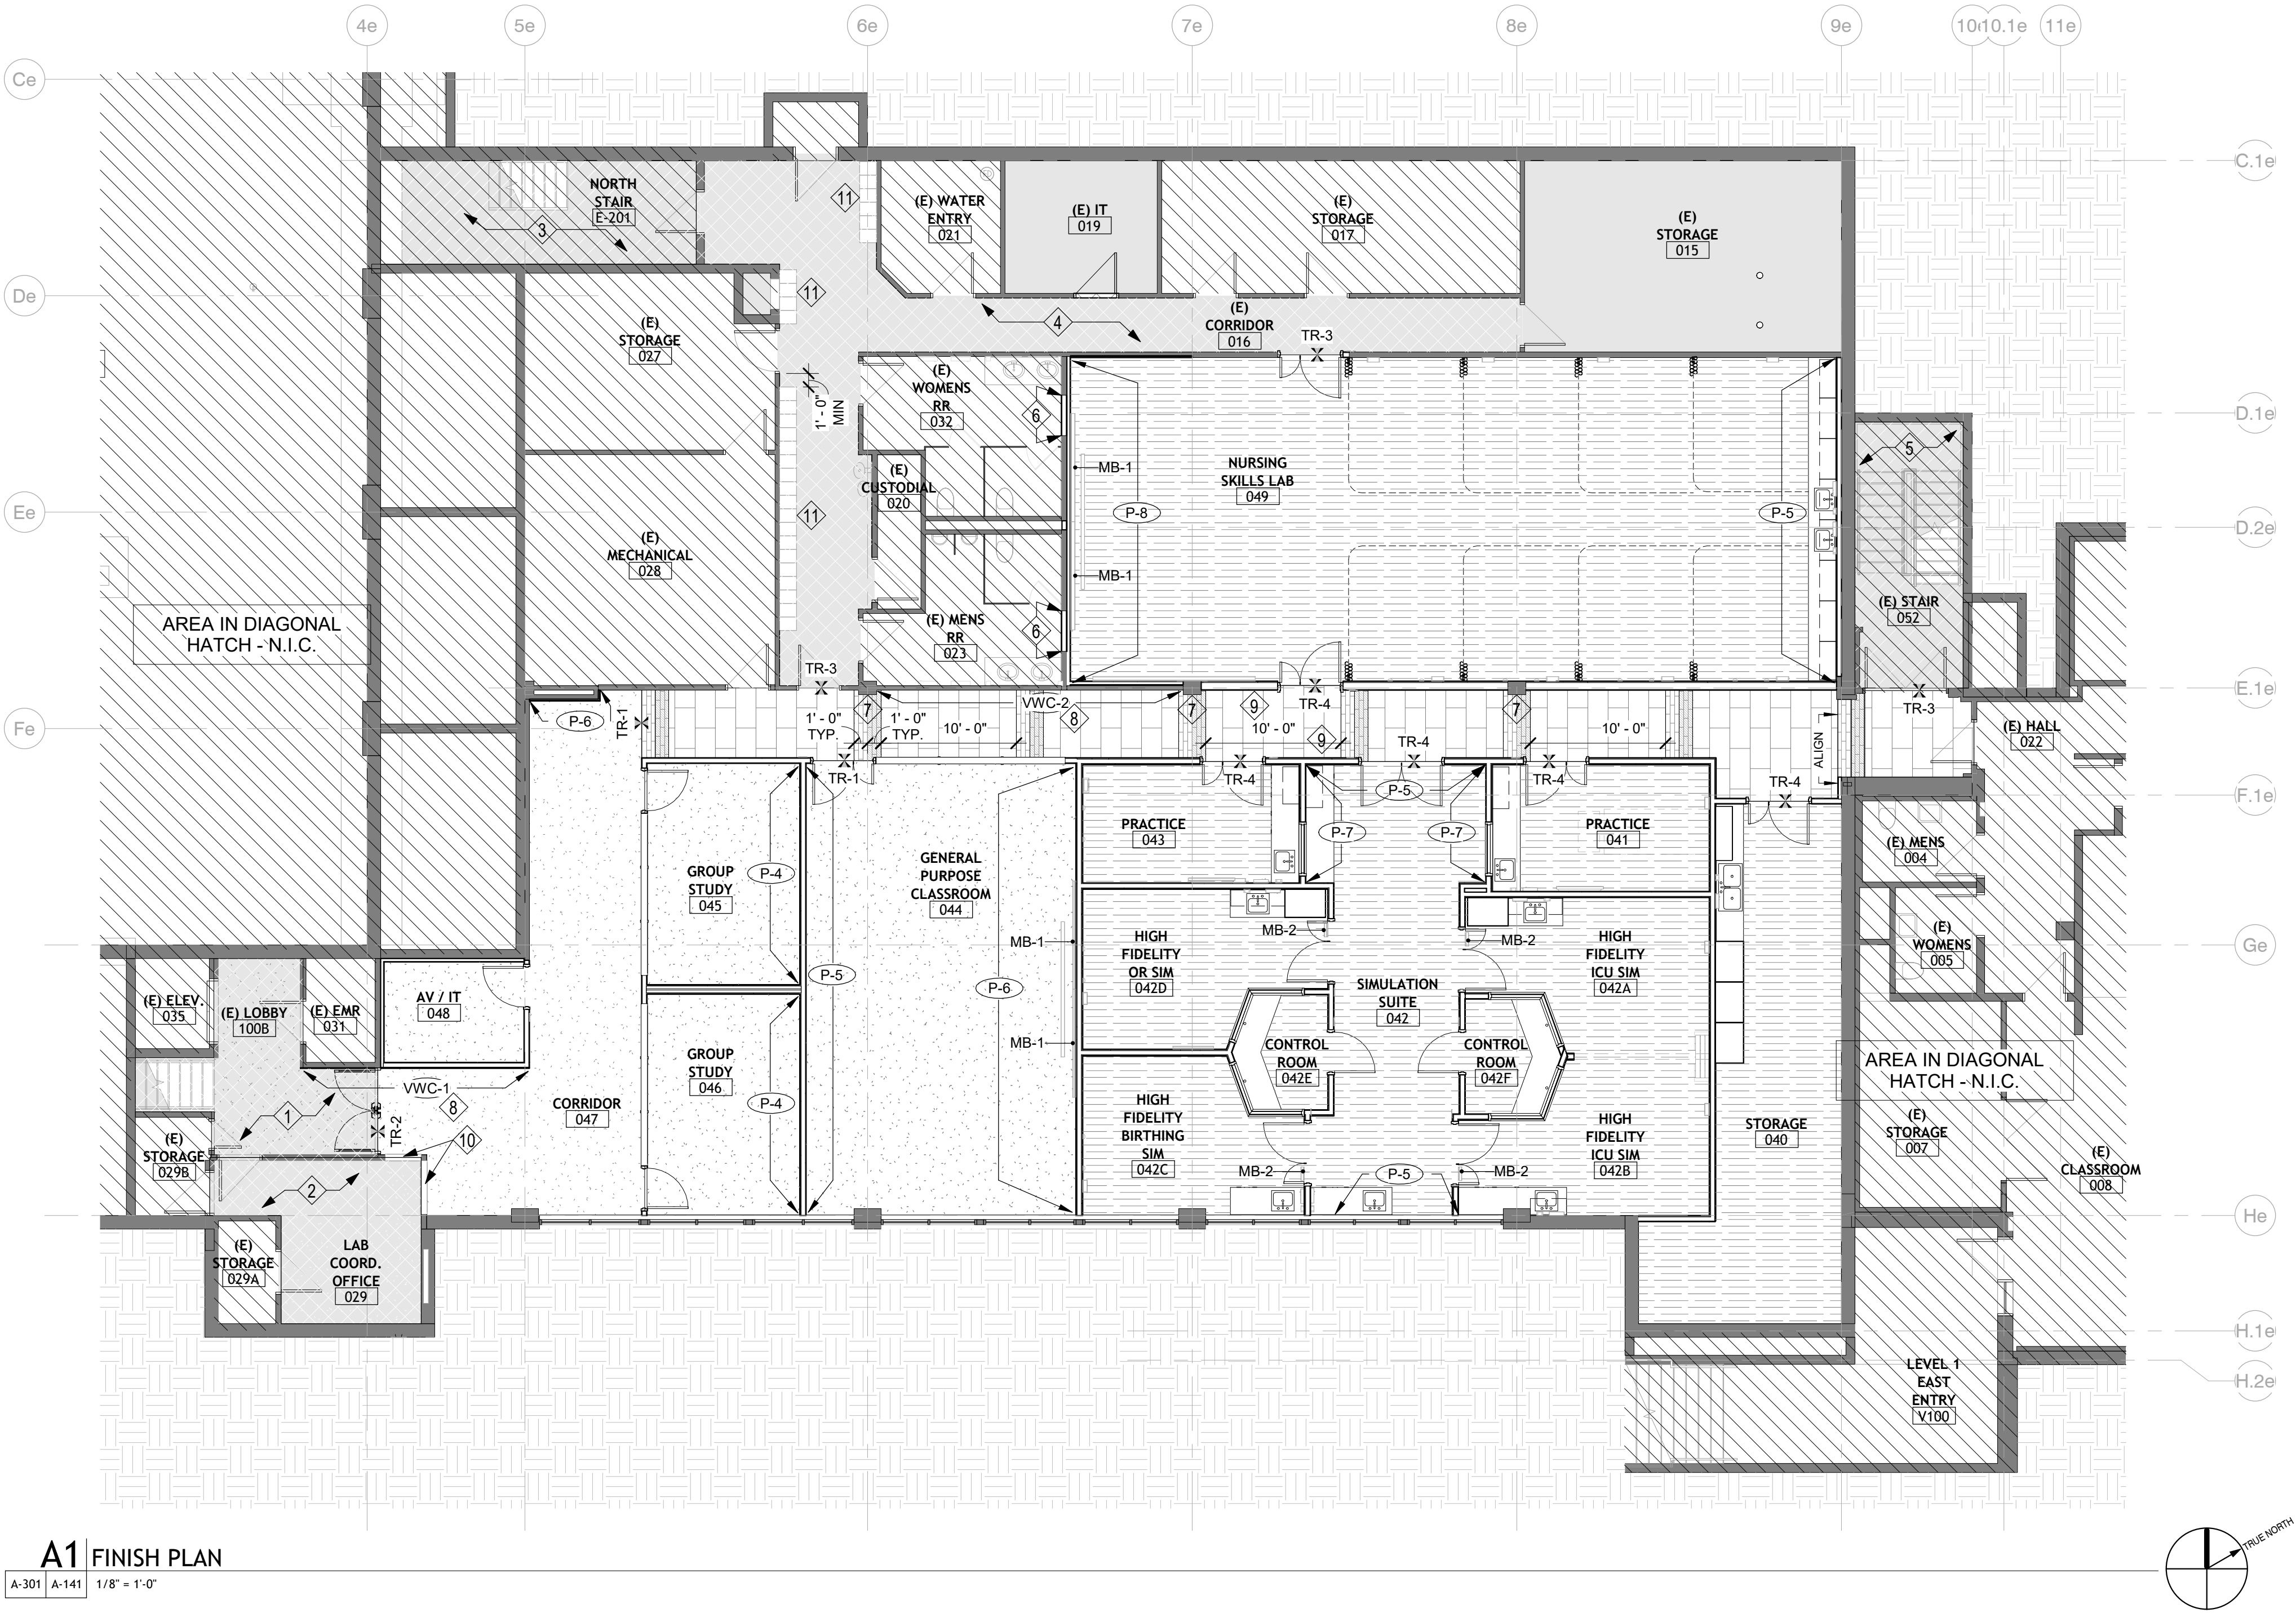

50 18th St #202
Denver, CO 80211
Tel: 303-220-6400
URL: www.nv5.com

Project Name
KURSING RENOVATION

Project Number
2172.00

Date (YYYY/MM/DD)
20-01-2021

Drawn By
Author

Checked By
Checker

Drawing

FURNITURE PLAN

CONTRACT DOCUMENTS

© Hord Coplan Macht, Inc.



A-301	A-142	3/16" = 1'-0"
-------	-------	---------------

1. ALL CEILING ELEVATIONS DIMENSIONED FROM FINISH FLOOR BELOW.
2. CENTER ALL DEVICES, SPRINKLER HEADS, ETC. IN CEILING TILE, U.N.O.
3. EXISTING EXPOSED STRUCTURE TO REMAIN, UNPAINTED.
4. CONTRACTOR TO REUSE AS MANY EXISTING ACOUSTIC CEILING TILES AS POSSIBLE. THEY ARE IN GOOD CONDITION.
5. FIRE SPRINKLER CONTRACTOR TO REFERENCE ALL DRAWINGS & SPECIFICATIONS FOR DETERMINING REQUIRED COVERAGE & HEAD LAYOUT/DESIGN
6. ALL GYPSUM BOARD SOFFITS AT 8'-0" AFF U.N.O.
7. REFER TO MEP AND A/VIT DRAWINGS FOR ADDITIONAL INFORMATION.
8. ALL DIFFUSERS SHALL BE PAINTED TO MATCH ADJACENT SURFACE COLOR, U.N.O.

- **C-4**
24" X 24" ACOUSTIC PANEL CEILING
- **C-5**
24" X 48" ACOUSTIC PANEL CEILING
- **C-7**
GYPSUM WALL BOARD, PAINTED

NOTE #	NOTE
1	(E) CEILING AND LIGHT FIXTURES TO REMAIN.
2	PATCH AND REPAIR CEILINGS AS NECESSARY AT RESTROOM INFILL WALL. PAINT TO MATCH (E) CEILING.
3	OPEN TO STRUCTURE - UNFINISHED
5	OVERHEAD PROJECTOR AND PROJECTOR SCREEN, RE: AV/IT DWGS.

AREA IN DIAGONAL
HATCH - N.I.C.

CO MOUNTAIN COLLEGE
NURSING RENOVATION
 3000 Co Rd 114, Glenwood Springs, CO 81601

A-151

Hord Coplan Macht, Inc.

ARCHITECT
Hord Coplan Macht, Inc.
1842 Wazee Street, Suite 450
Denver, CO 80202
ph: 303.607.0877
URL: www.hcm2.com

M/E/P ENGINEER
Cator, Ruma and Associates, Co.
896 Tabor Street
Lakewood, CO 80401
p. 303-232-6200
URL: www.catoruma.com

AV / IT
NV5
2650 18th Sty #202
Denver, CO 80211
ph. 303-220-6400
URL: www.nv5.com

COLORADO MOUNTAIN COLLEGE
NURSING RENOVATION

3000 Co Rd 114, Glenwood Springs, CO 81601

hord | coplan | macht
ARCHITECTURE
LANDSCAPE ARCHITECTURE
PLANNING
INTERIOR DESIGN



No.	Date	Revision

Project Name
NURSING RENOVATION

Project Number
22172.00

Date (YYYY/MM/DD)
10-01-2021

Drawn By
Author


Checked By
Checker

Drawing
BUILDING SECTIONS


A-301

CONTRACT DOCUMENTS


© Hord Coplan Macht, Inc.

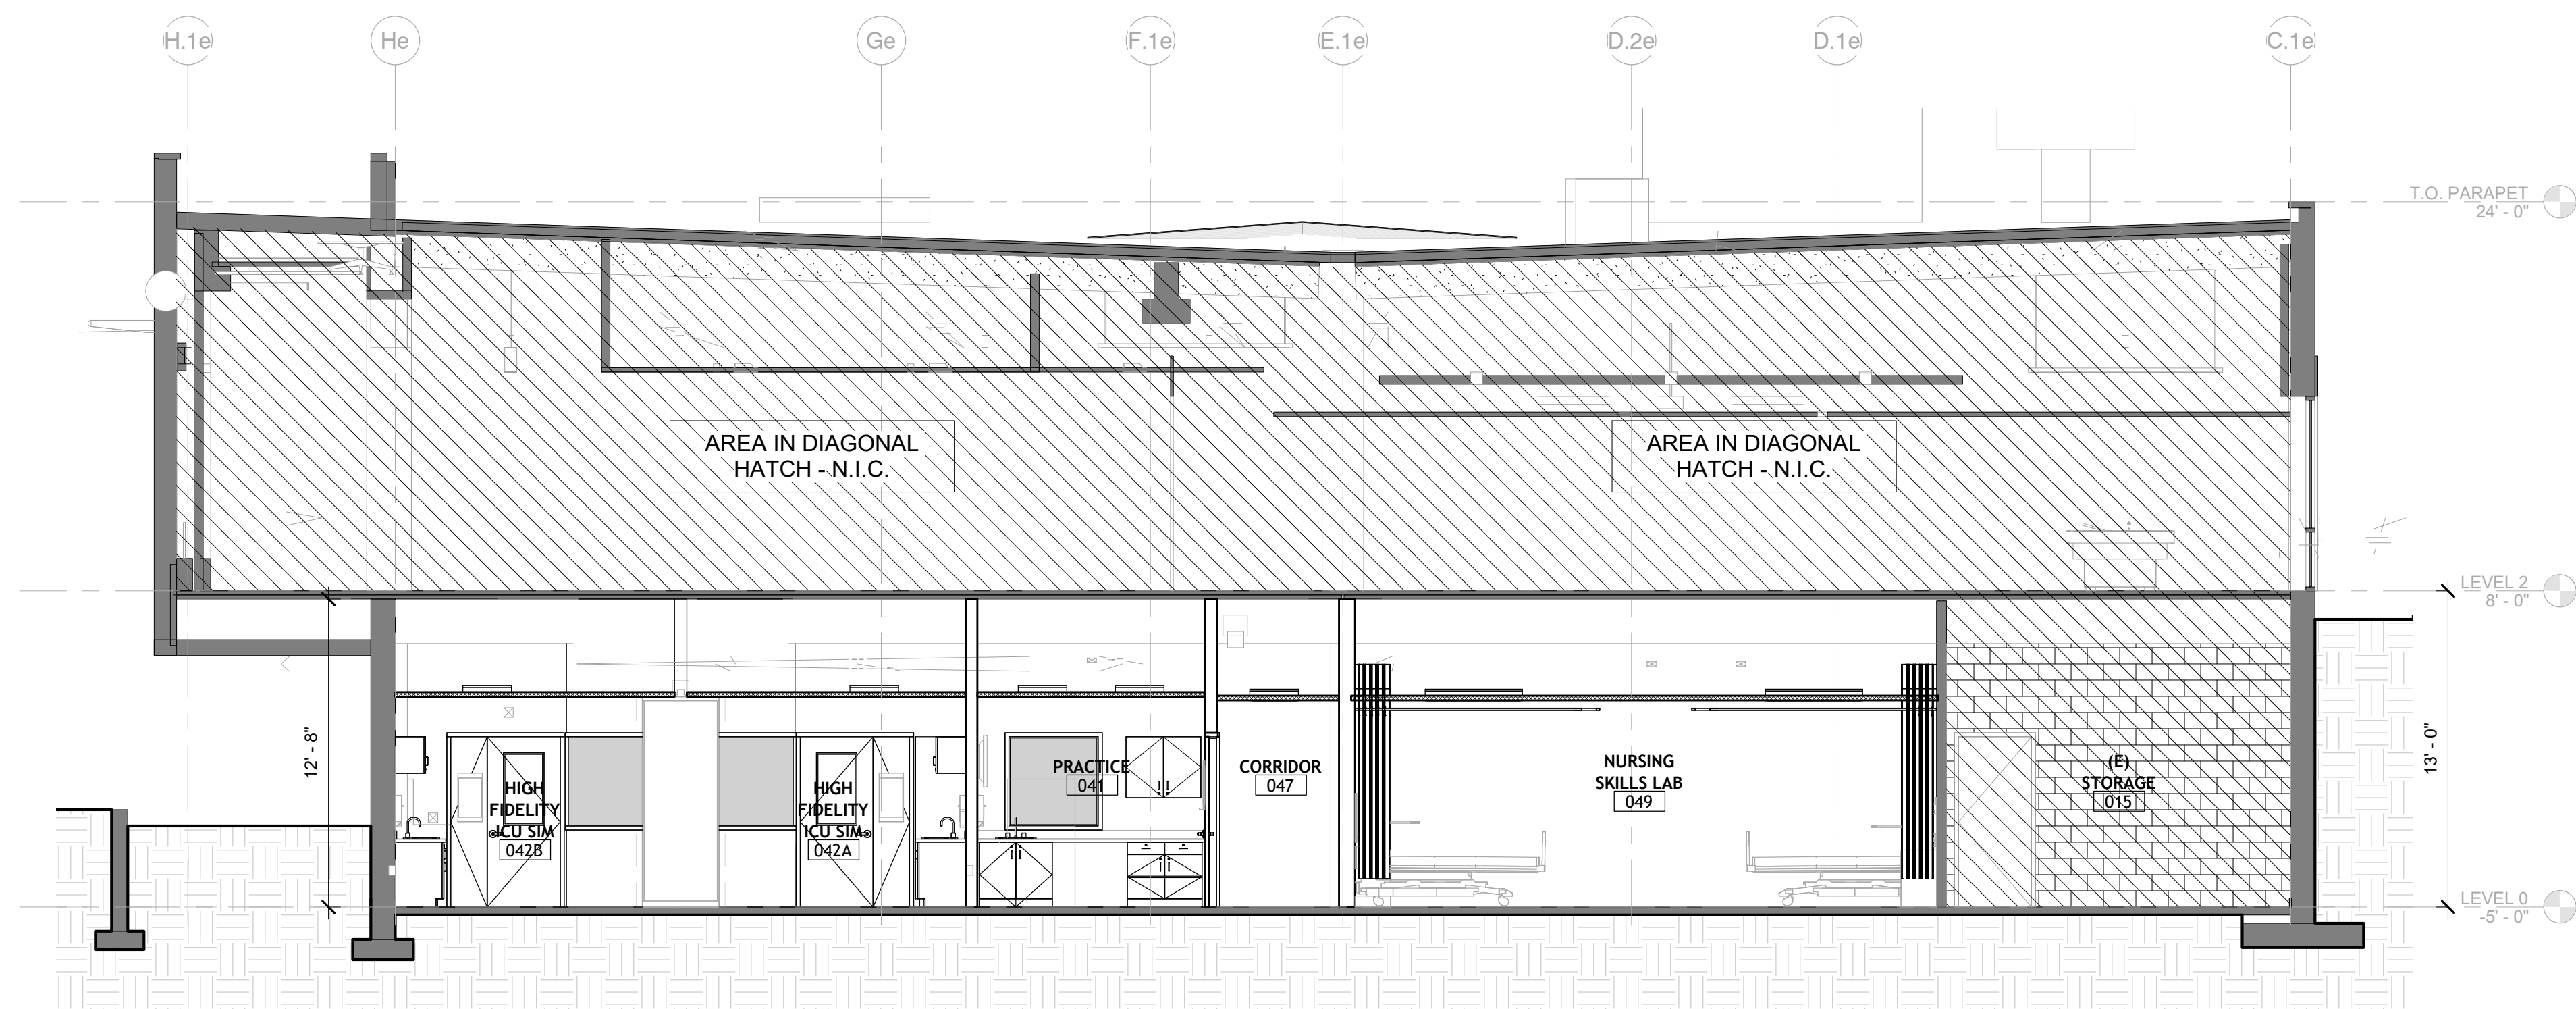

NOTE
BUILDING SECTIONS SHOWN FOR FLOOR TO FLOOR HEIGHT REFERENCE FOR PARTITIONS ATTACHED TO STRUCTURE ABOVE.

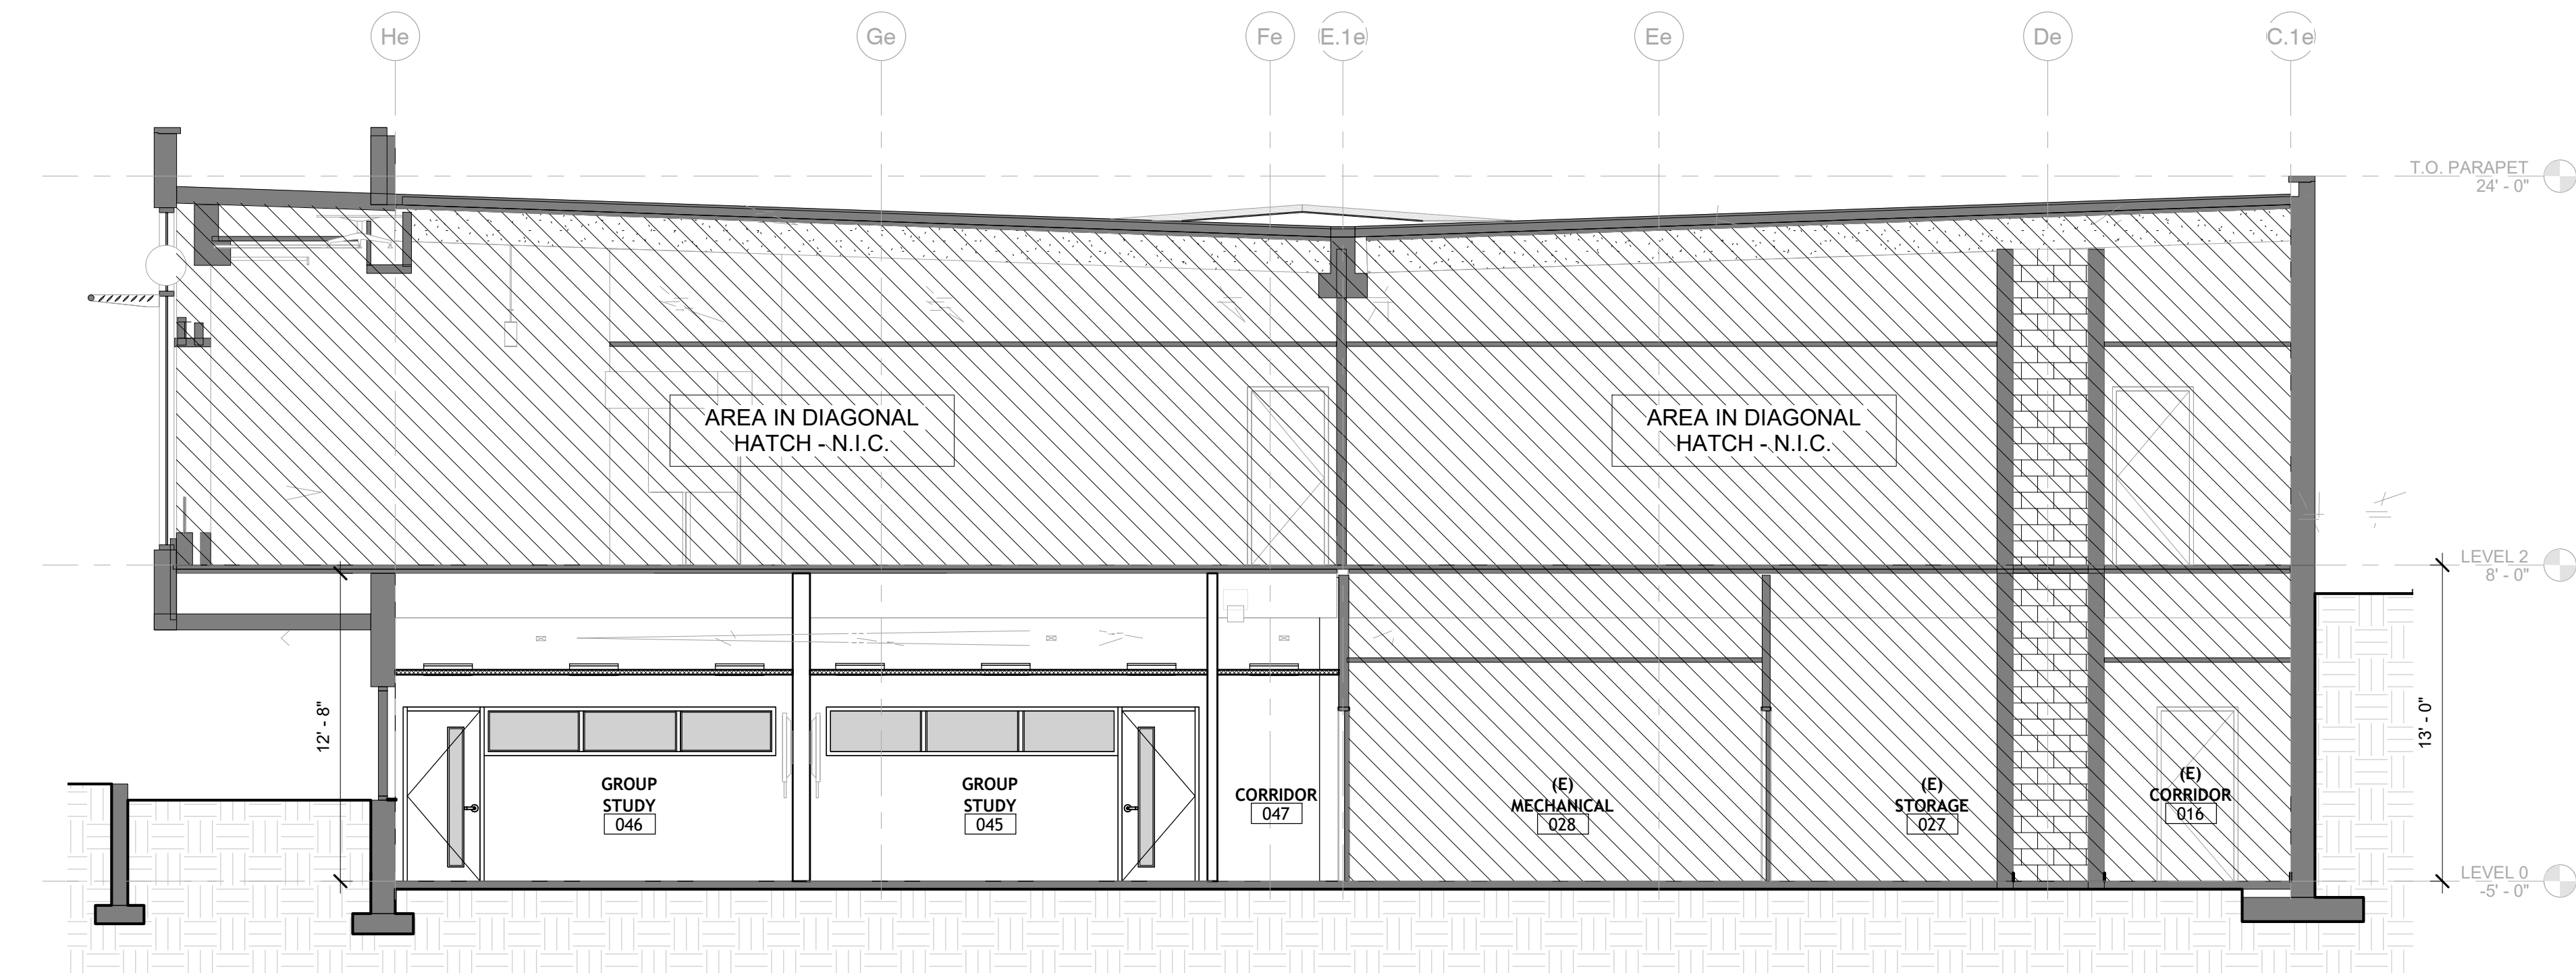

NOTE
BUILDING SECTIONS SHOWN FOR FLOOR TO FLOOR HEIGHT REFERENCE FOR PARTITIONS ATTACHED TO STRUCTURE ABOVE.

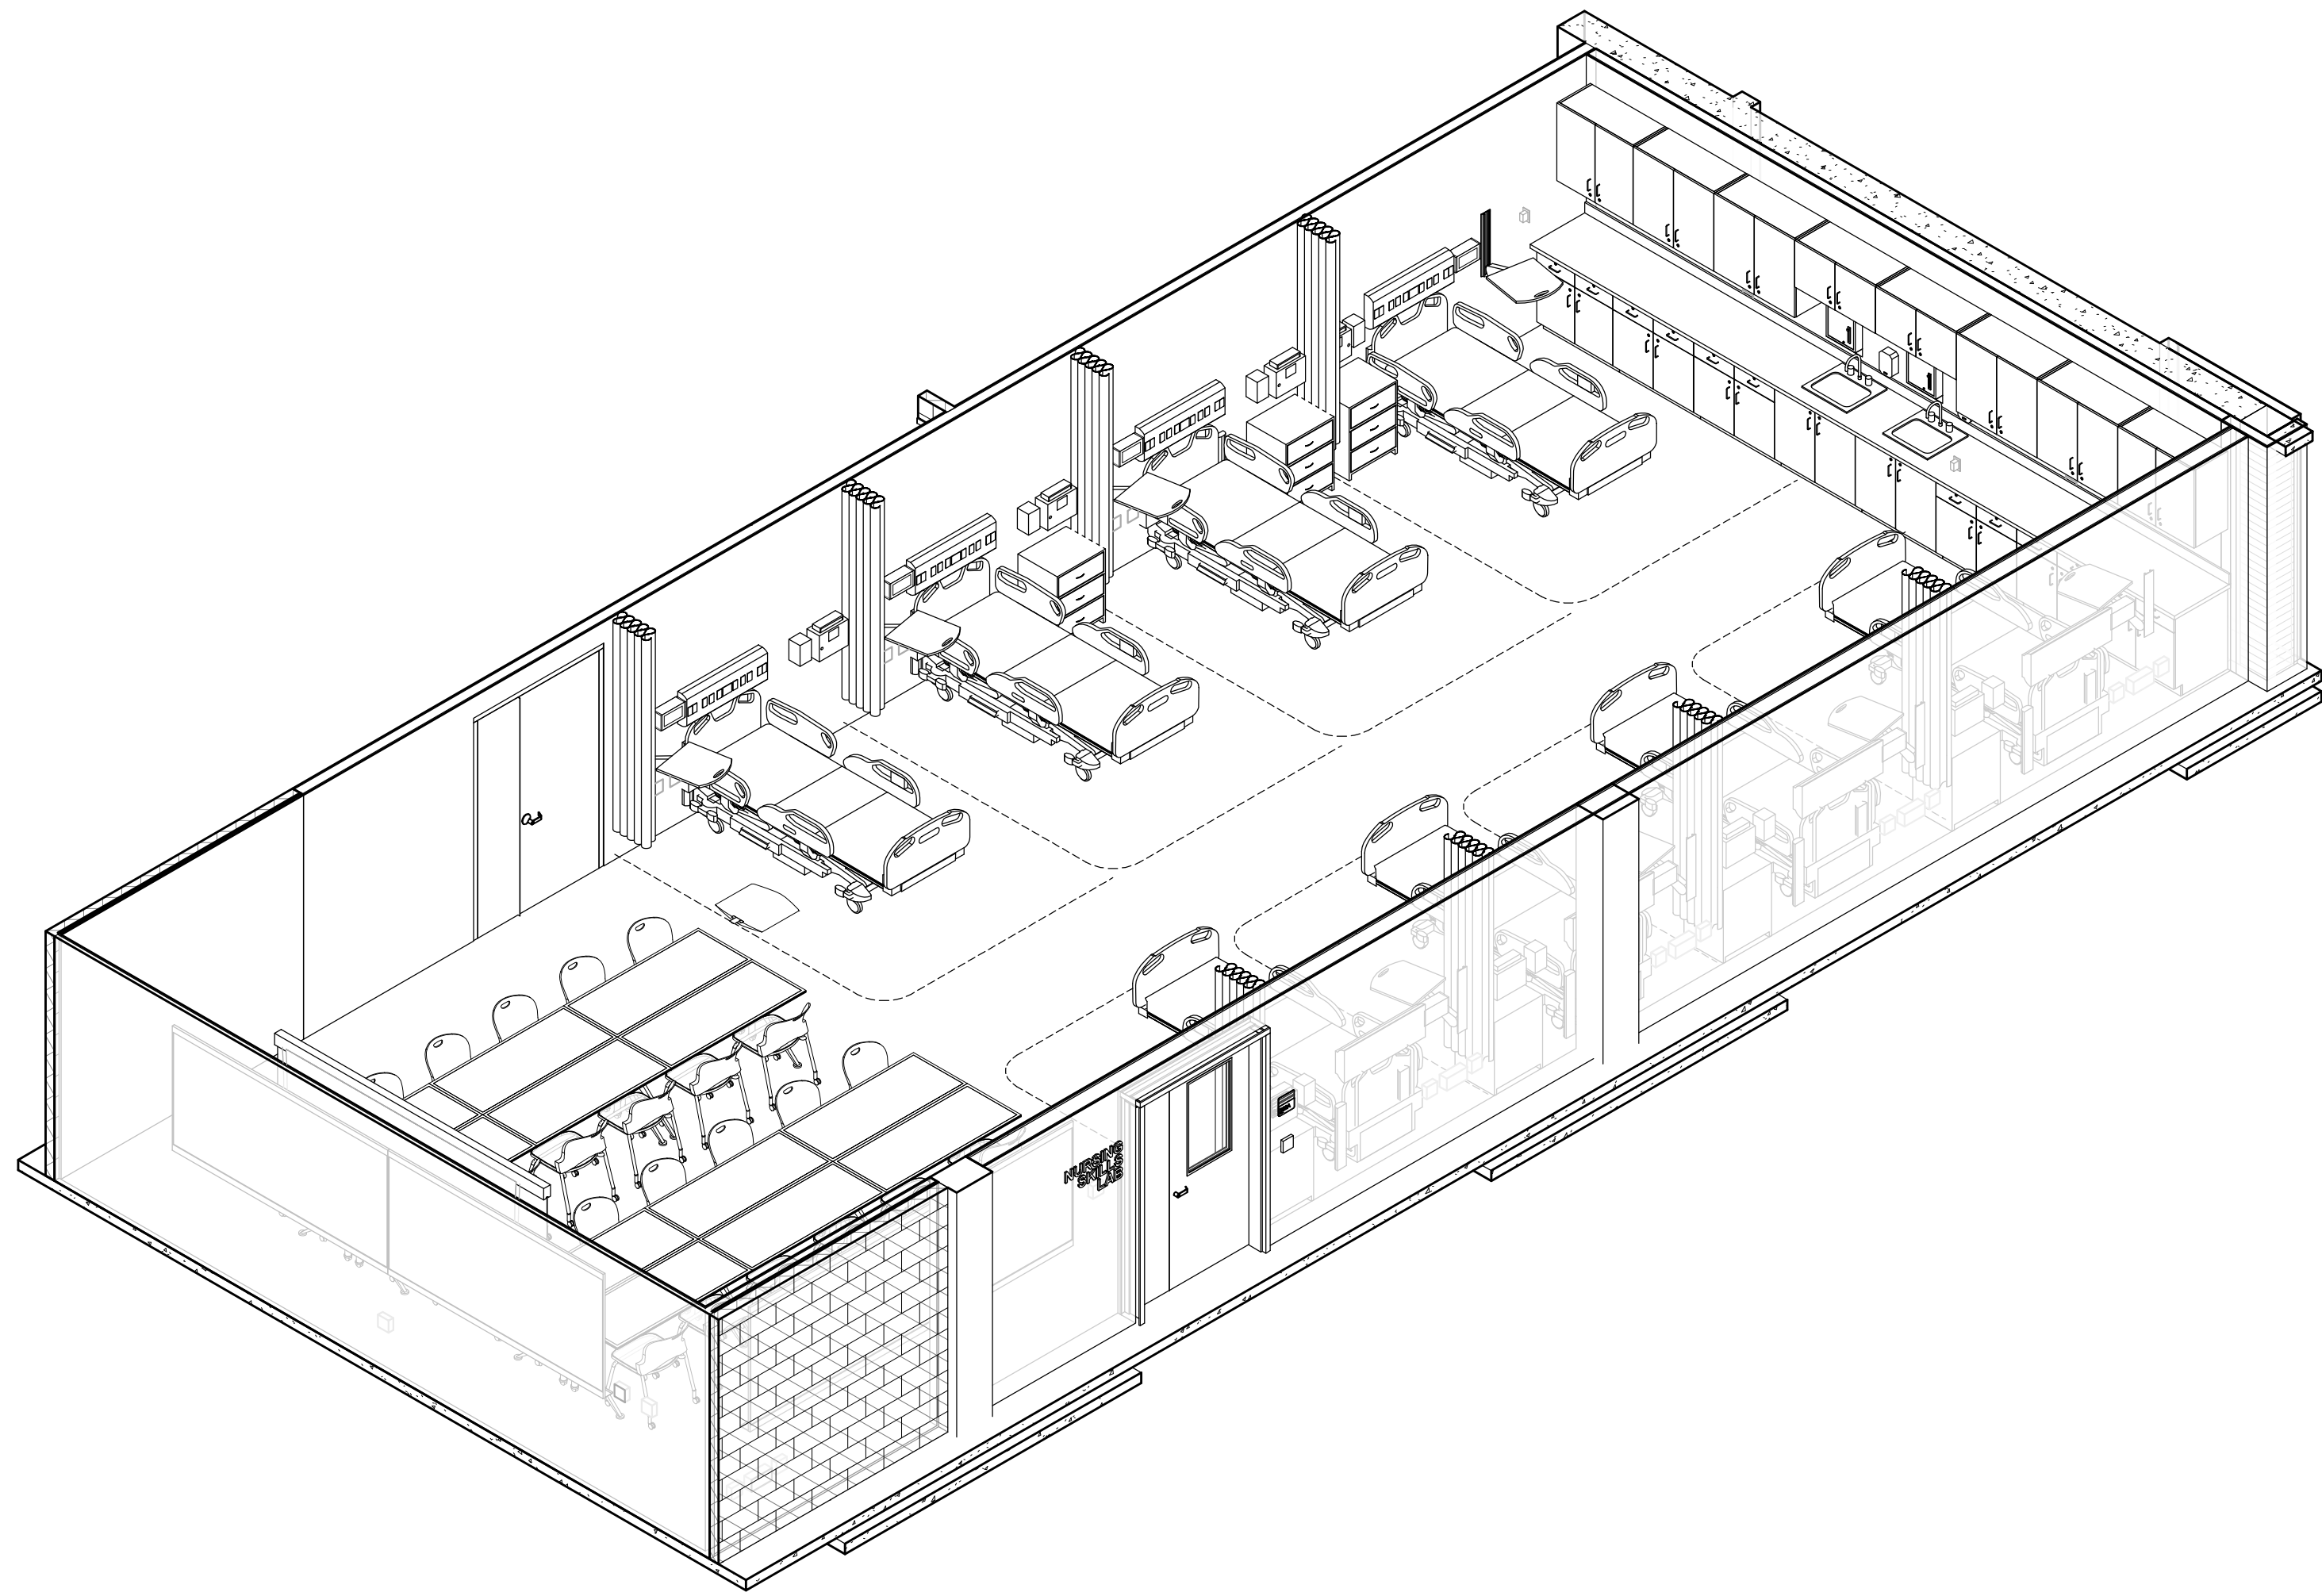

C1 3D VIEW - NURSING SKILLS LAB


EQUIPMENT SCHEDULE				
Type Mark	DESCRIPTION	PROVIDED BY	INSTALLED BY	Comments
BB-01	BIRTHING BED	OWNER	OWNER	
BG-01	BROSELOW CART	OWNER	OWNER	
BS-01	BEDSIDE NIGHTSTAND	OWNER	OWNER	
CC-01	CRASH CART	OWNER	OWNER	
HB-01	PATIENT BED	OWNER	OWNER	
HW-01	HEADWALL WITH POWER, VAC, COMPRESSED AIR TO SIMULATE OXYGEN	CONTRACTOR	CONTRACTOR	
LB-01	WALL-MOUNTED LAPTOP BRACKET	CONTRACTOR	CONTRACTOR	
MD-01	MEDICATION DISPENSER	OWNER	OWNER	
NI-01	NEONATAL INCUBATOR	OWNER	OWNER	
OT-01	OVERBED TABLE	OWNER	OWNER	
PS-01	PROJECTOR SCREEN, RE: AVIT DRAWINGS	OWNER	OWNER	
ST-01	STRETCHER	OWNER	OWNER	
TS-01	OFFICE COMPUTER	OWNER	OWNER	
TV-01	TELEVISION	TBD	CONTRACTOR	RE: AVIT DRAWINGS
WB-01	WALL BUMPER GUARDS	CONTRACTOR	CONTRACTOR	B.O.D. AMICO VERTICAL BED BUMPERS

FLOOR PLAN GENERAL NOTES


- DIMENSIONS INDICATED ARE TO FACE OF FINISH MATERIAL OF PARTITION OR WALL AND GRID LINES, UNLESS NOTED OTHERWISE.
- REFER TO FINISH PLANS FOR FLOOR PATTERNS.
- REFER TO SHEET (A-010) FOR PARTITION TYPE INFORMATION.
- REFER TO FINISH PLANS FOR ACCESSORY SCHEDULE AND LOCATIONS.
- PROVIDE BLOCKING AT ALL WALL-MOUNTED ACCESSORIES (GRAB BARS, ETC), HARDWARE WHERE REQUIRED AND WALL-HUNG CABINETS.
- VERIFY & COORDINATE ALL REQUIREMENTS FOR OWNER FURNISHED ITEMS PRIOR TO PERFORMANCE OF WORK THAT MAY INTERFACE WITH SUCH ITEMS.
- PROVIDE PAINTED ACCESS PANELS IN WALLS & CEILINGS AT CONCEALED ITEMS, SUCH AS VALVES, CONTROLS, SWITCHES OR ANY OTHER ITEMS THAT REQUIRE ACCESS. GC TO DETERMINE ACCESS PANEL LOCATION W/ ARCHITECT PRIOR TO INSTALLATION.
- REFER TO ALTERNATE FLOOR PLAN FOR ALTERNATE SCOPE DESCRIPTIONS.

SHEET NOTES - ENLARGED PLANS


NOTE #	NOTE
9	NEW OPENING IN (E) WALL. PATCH AND REPAIR DRYWALL AT OPENING.
10	P-LAM COUNTERTOP W/ P-LAM LOWER CABINETS AND P-LAM UPPER CABINETS.
12	INFILL DOOR OPENING W/ PARTITION TYPE AS INDICATED. PATCH GWB FLUSH TO (E) RESTROOM SIDE OF WALL. INSTALL TILE AND PAINT WALL TO MATCH (E) RESTROOM FINISH. PROVIDE NEW WALL AS INDICATED ON NURSING SKILLS LAB SIDE.

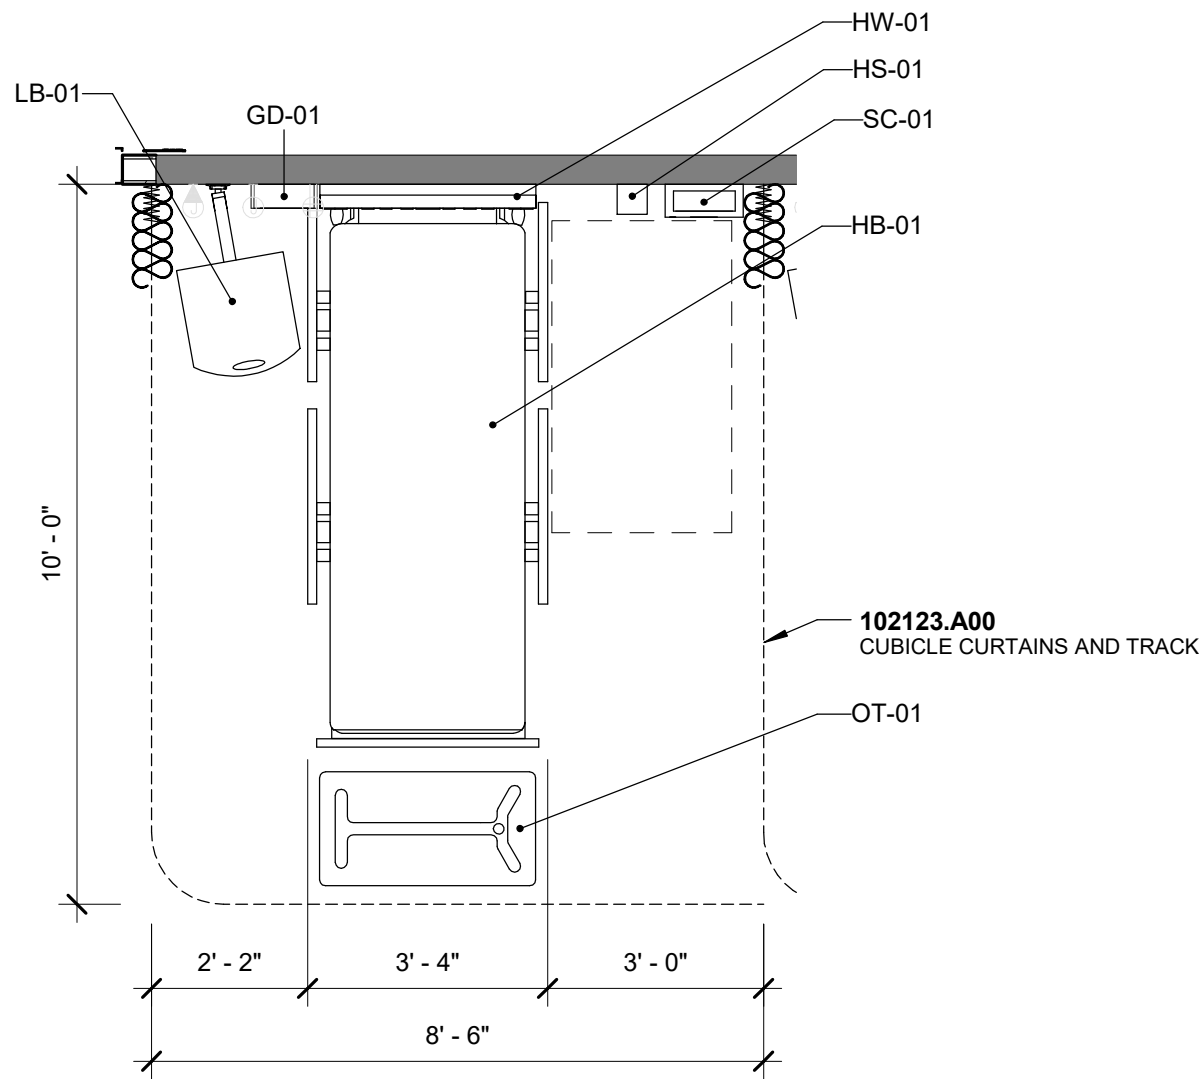


C5 ENLARGED PLAN - ADA BED LAYOUT PLAN

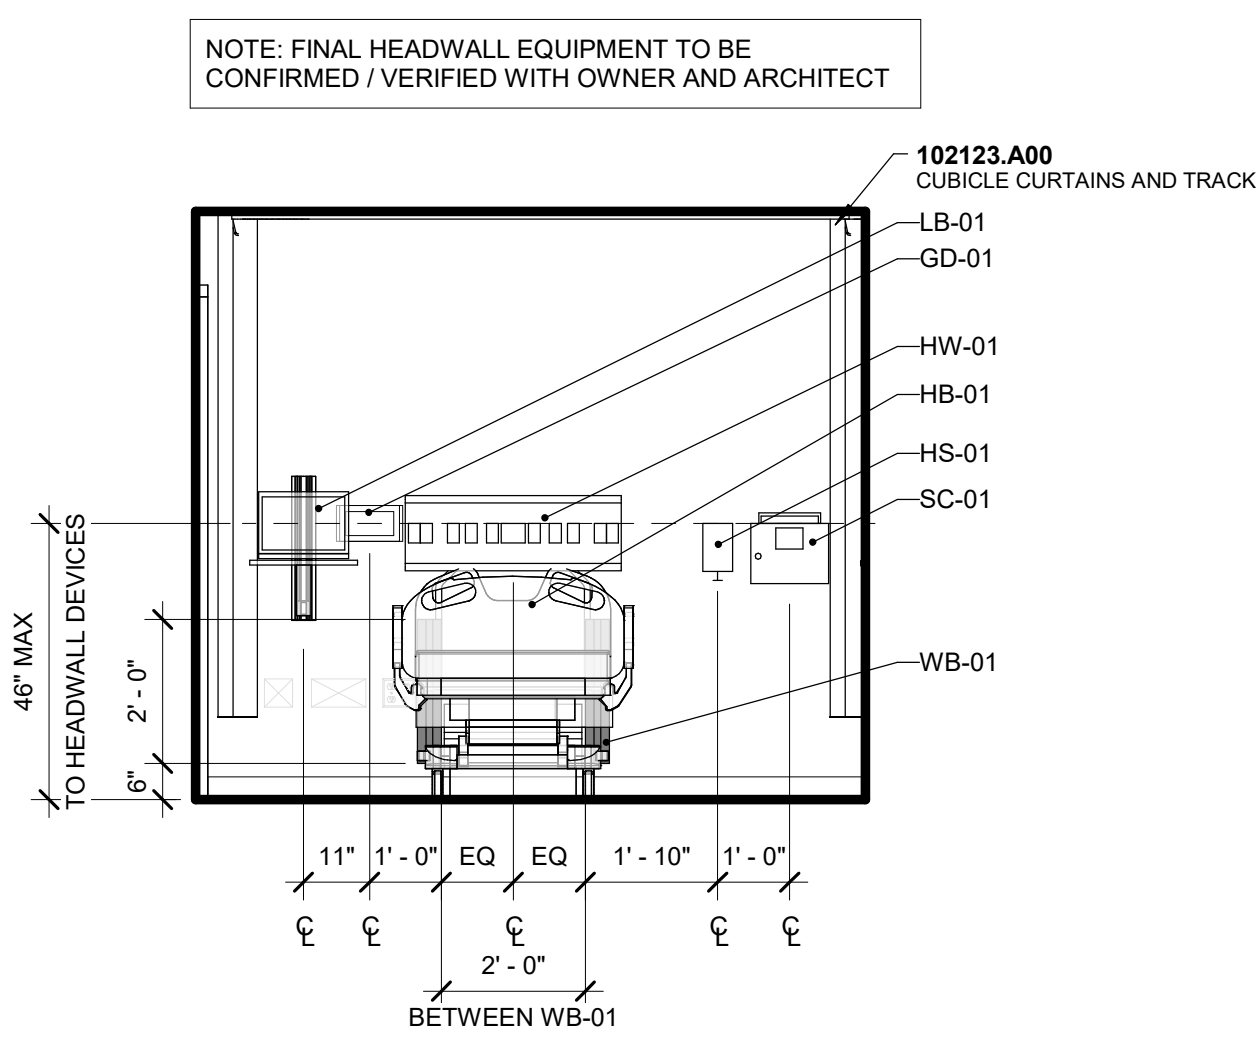


C6 ENLARGED ADA SKILLS BED ELEVATION

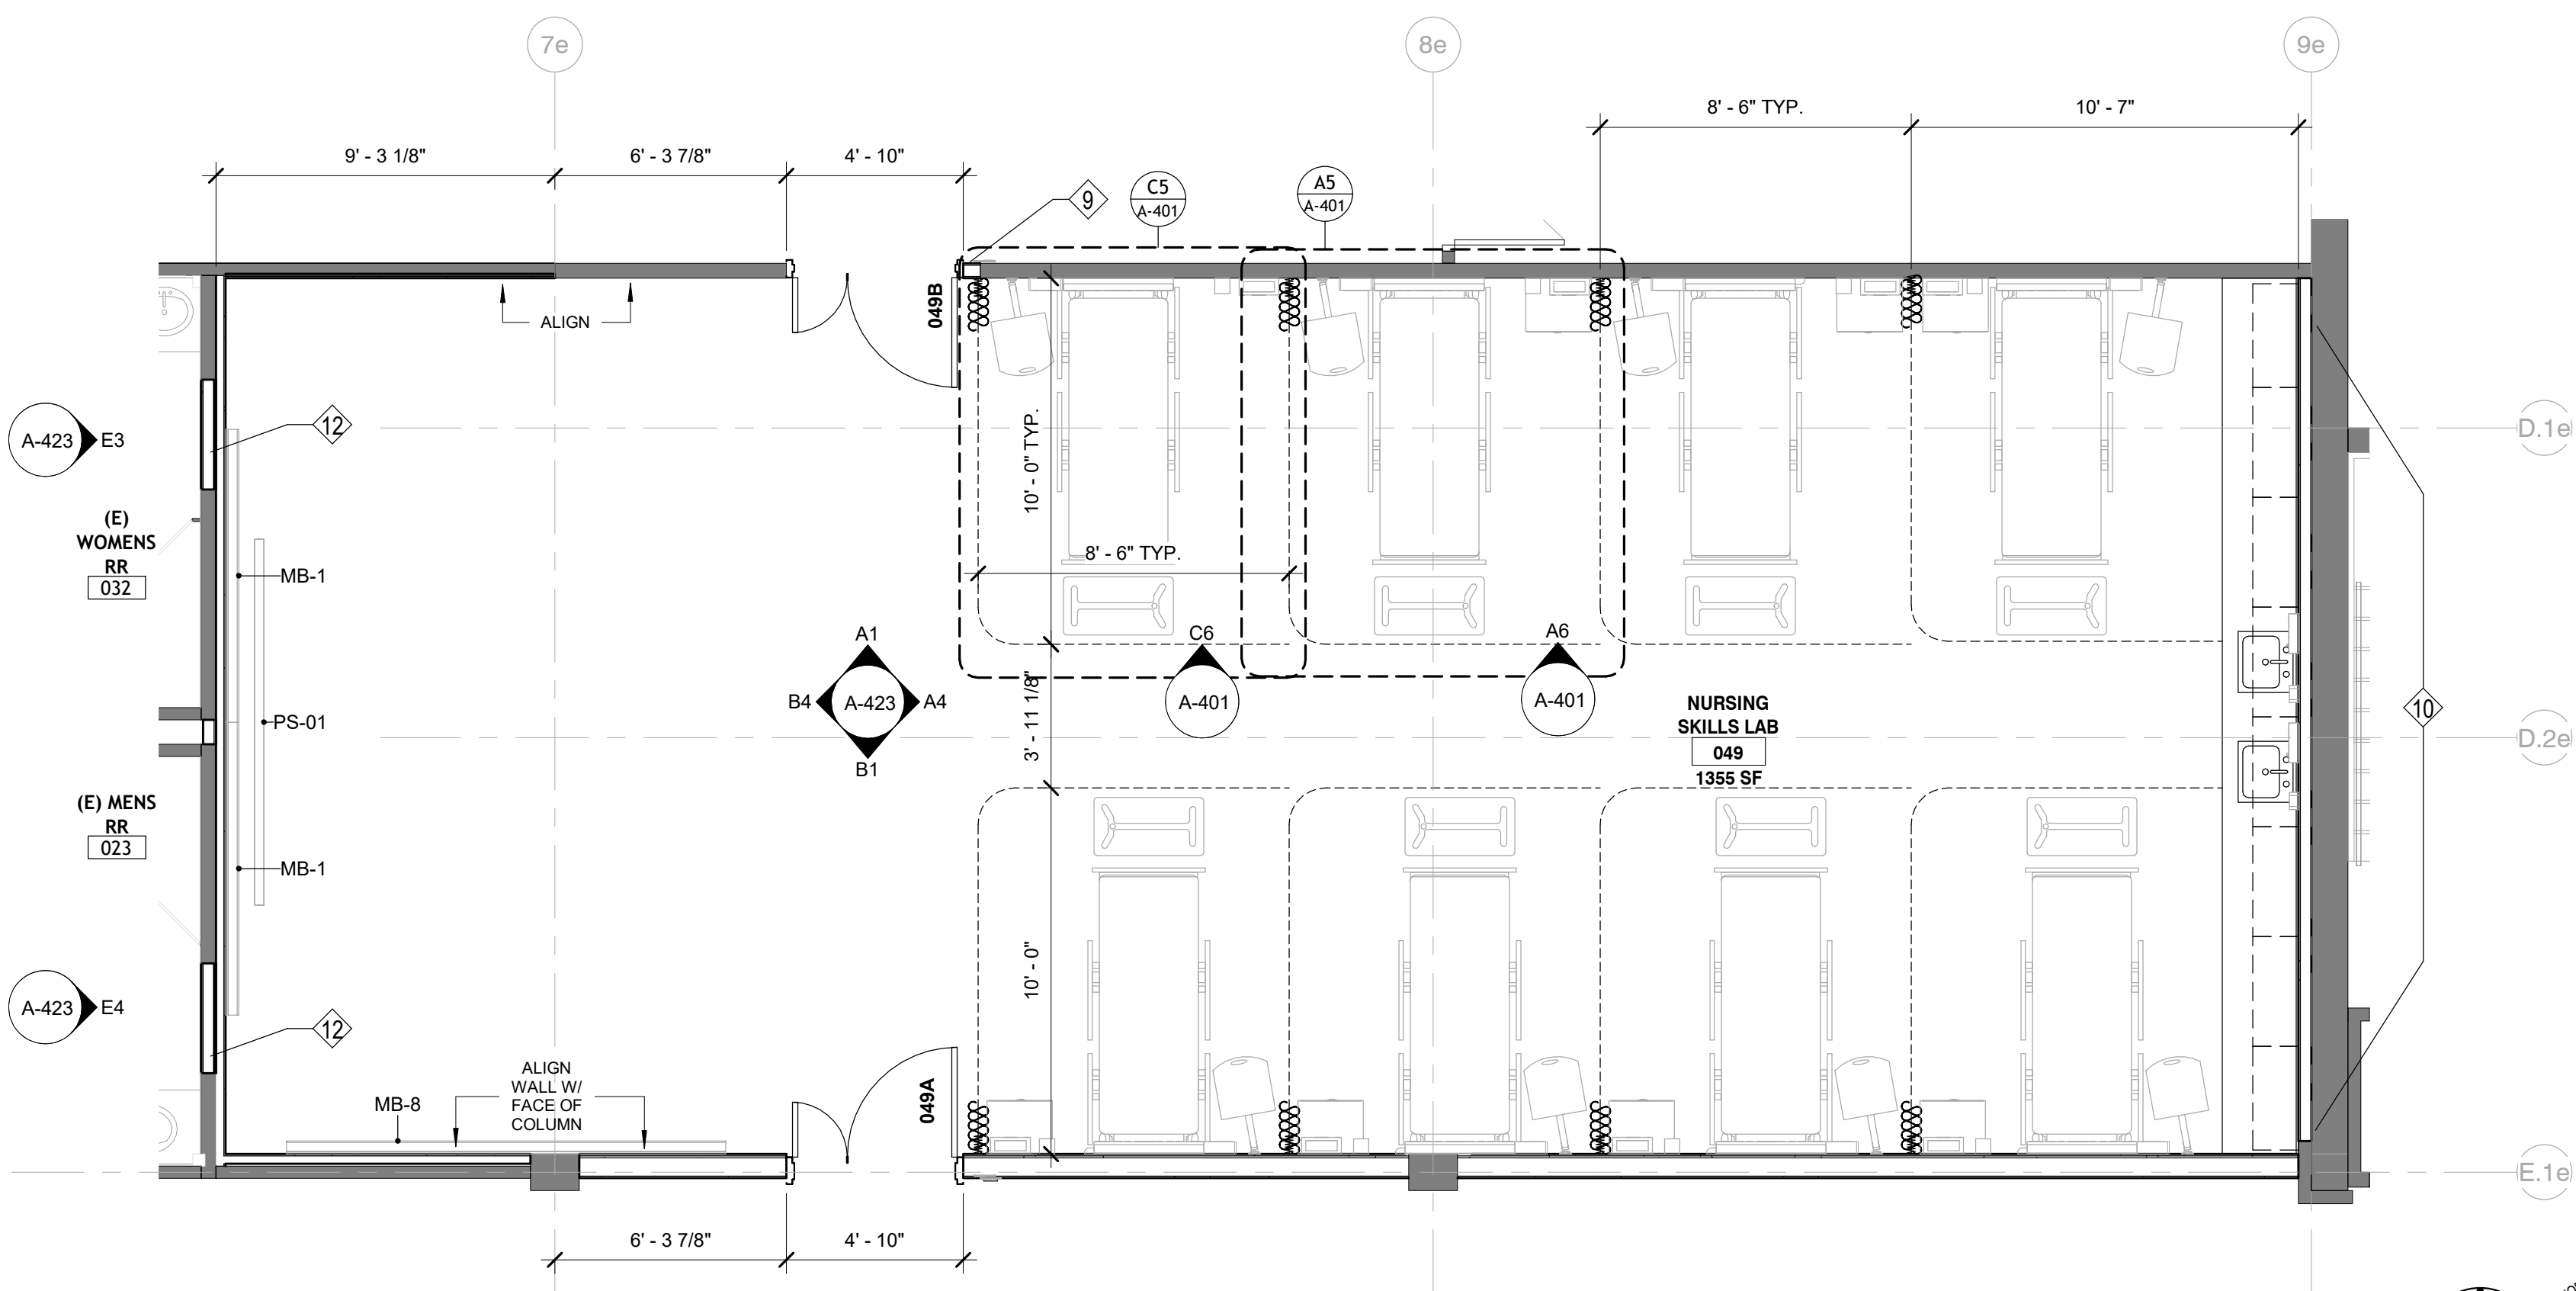

A1 ENLARGED PLAN - SKILLS LAB

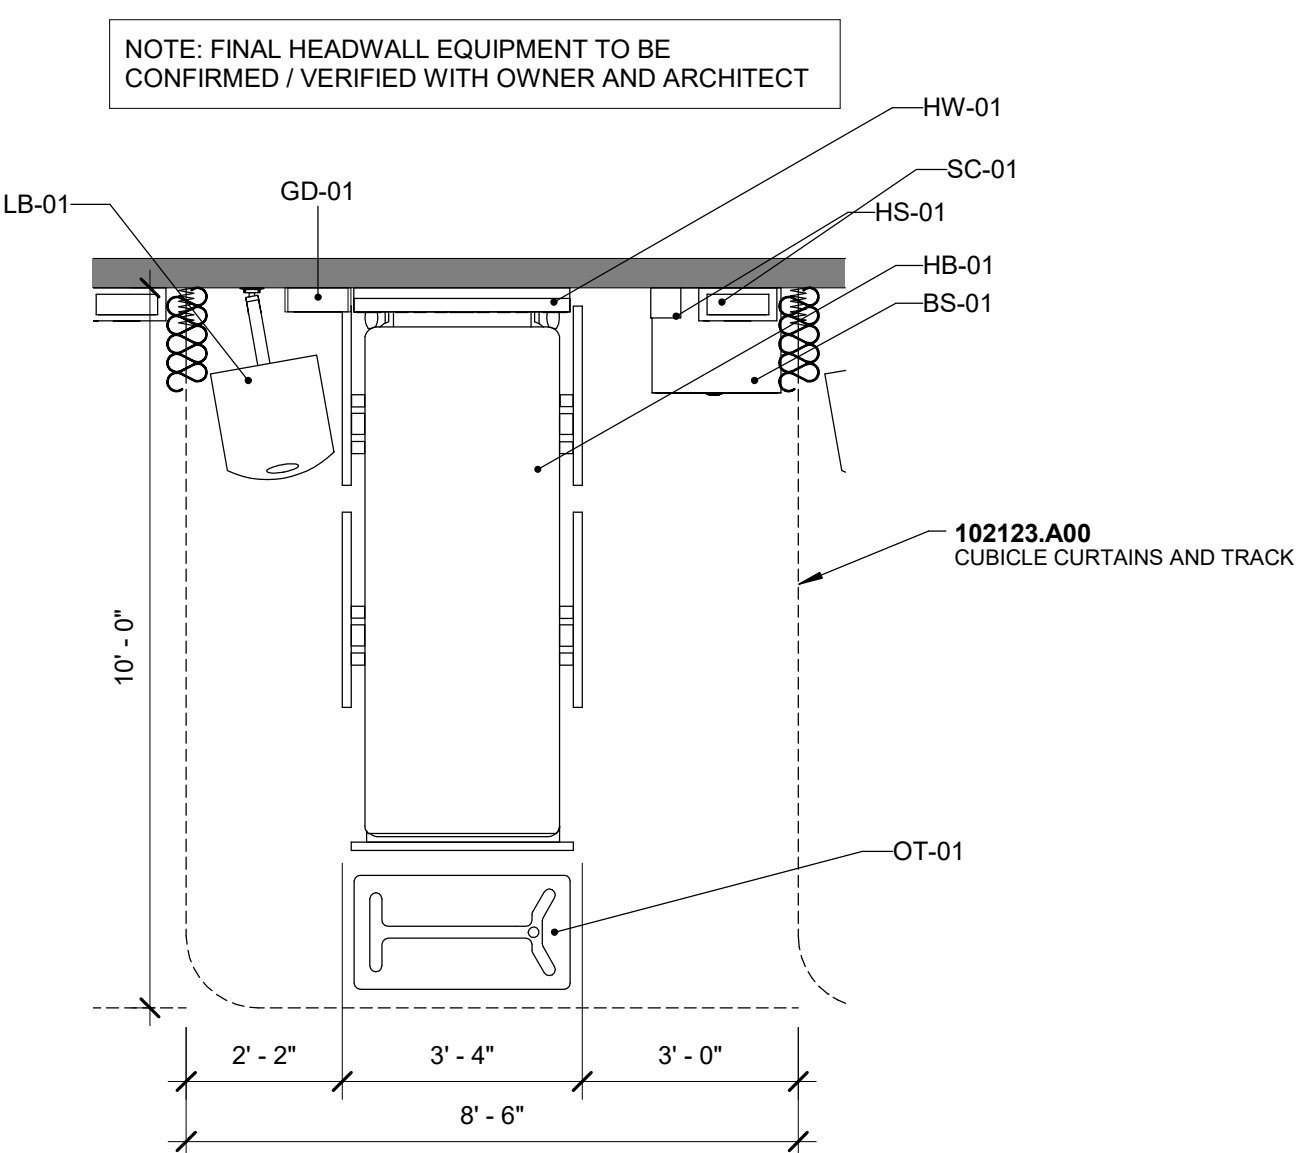

A5 ENLARGED PLAN - TYP. BED LAYOUT PLAN

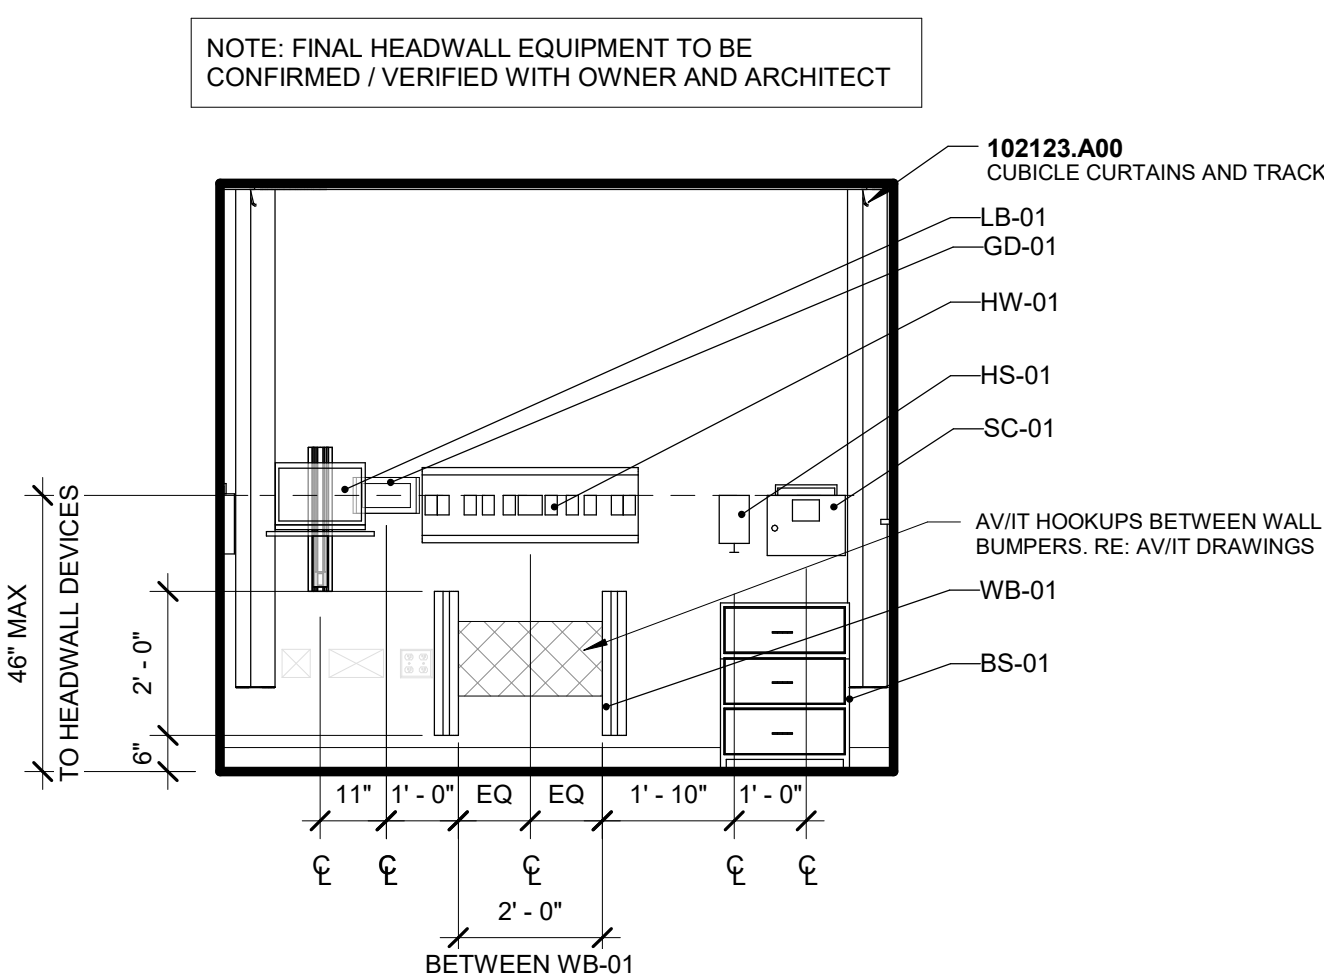

A6 ENLARGED SKILLS BED ELEVATION

ARCHITECT
Hord Coplan Macht, Inc.
1850 Wazee Street, Suite 450
Denver, CO 80202
ph: 303.607.0877
URL: www.hcm2.com


M/E/P ENGINEER
Cator, Ruma and Associates, Co.
896 Tabor Street
Lakewood, CO 80401
p. 303-232-6200
URL: www.catoruma.com

AV / IT
NVS
2650 18th Sty #202
Denver, CO 80211
ph. 303-220-6400
URL: www.nvs.com

COLORADO MOUNTAIN COLLEGE
NURSING RENOVATION

3000 Co Rd 114, Glenwood Springs, CO 81601

hord | coplan | macht
ARCHITECTURE
LANDSCAPE ARCHITECTURE
PLANNING
INTERIOR DESIGN

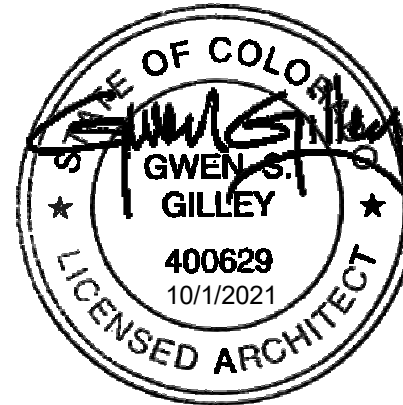

No.	Date	Revision

Project Name
NURSING RENOVATION

Project Number
22172.00

Date (YYYY/MM/DD)
10-01-2021

Drawn By
SPD

Checked By
HRM

Drawing
ENLARGED PLANS

A-401

ARCHITECT
Hord Coplan Macht, Inc.
1850 Wazee Street, Suite 450
Denver, CO 80202
ph: 303.607.0877
URL: www.hcm2.com

M/E/P ENGINEER
Cator, Ruma and Associates, Co.
896 Tabor Street
Lakewood, CO 80401
p. 303-232-6200
URL: www.catoruma.com

AV / IT
NV5
2650 18th Sty #202
Denver, CO 80211
ph. 303-220-6400
URL: www.nv5.com

FLOOR PLAN
GENERAL NOTES


- DIMENSIONS INDICATED ARE TO FACE OF FINISH MATERIAL OF PARTITION OR WALL AND GRID LINES, UNLESS NOTED OTHERWISE.
- REFER TO FINISH PLANS FOR FLOOR PATTERNS.
- REFER TO SHEET (A-010) FOR PARTITION TYPE INFORMATION.
- REFER TO FINISH PLANS FOR ACCESSORY SCHEDULE AND LOCATIONS.
- PROVIDE BLOCKING AT ALL WALL-MOUNTED ACCESSORIES (GRAB BARS, ETC), HARDWARE WHERE REQUIRED AND WALL-HUNG CABINETS.
- VERIFY & COORDINATE ALL REQUIREMENTS FOR OWNER FURNISHED ITEMS PRIOR TO PERFORMANCE OF WORK THAT MAY INTERFACE WITH SUCH ITEMS.
- PROVIDE PAINTED ACCESS PANELS IN WALLS & CEILINGS AT CONCEALED ITEMS, SUCH AS VALVES, CONTROLS, SWITCHES OR ANY OTHER ITEMS THAT REQUIRES ACCESS. GC TO DETERMINE ACCESS PANEL LOCATION W/ ARCHITECT PRIOR TO INSTALLATION.
- REFER TO ALTERNATE FLOOR PLAN FOR ALTERNATE SCOPE DESCRIPTIONS.

Type Mark	DESCRIPTION	PROVIDED BY	INSTALLED BY	Comments
BB-01	BIRTHING BED	OWNER	OWNER	
BC-01	BROSELOW CART	OWNER	OWNER	
BS-01	BEDSIDE NIGHTSTAND	OWNER	OWNER	
CC-01	CRASH CART	OWNER	OWNER	
HB-01	PATIENT BED	OWNER	OWNER	
HW-01	HEADWALL WITH POWER, VAC, COMPRESSED AIR TO SIMULATE OXYGEN	CONTRACTOR	CONTRACTOR	
LB-01	WALL-MOUNTED LAPTOP BRACKET	CONTRACTOR	CONTRACTOR	
MD-01	MEDICATION DISPENSER	OWNER	OWNER	
NI-01	NEONATAL INCUBATOR	OWNER	OWNER	
OT-01	OVERBED TABLE	OWNER	OWNER	
PS-01	PROJECTOR SCREEN, RE: AV/IT DRAWINGS	OWNER	OWNER	
ST-01	STRETCHER	OWNER	OWNER	
TS-01	OFFICE COMPUTER	OWNER	OWNER	
TV-01	TELEVISION	TBD	CONTRACTOR	RE: AV/IT DRAWINGS
WB-01	WALL BUMPER GUARDS	CONTRACTOR	CONTRACTOR	B.O.D. AMICO VERTICAL BED BUMPERS

COLORADO MOUNTAIN COLLEGE
NURSING RENOVATION

3000 Co Rd 114, Glenwood Springs, CO 81601

hord | coplan | macht
ARCHITECTURE
LANDSCAPE ARCHITECTURE
PLANNING
INTERIOR DESIGN

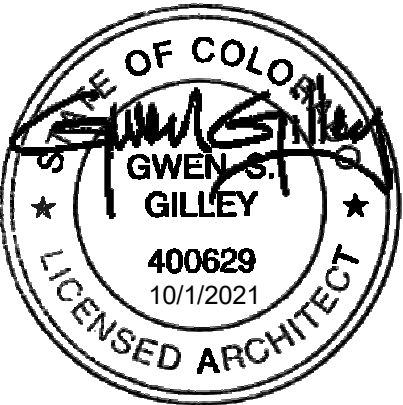

No.	Date	Revision

Project Name
NURSING RENOVATION

Project Number
22172.00

Date (YYYY/MM/DD)
10-01-2021

Drawn By
SPD


Checked By
HRM

Drawing
ENLARGED PLANS


A-402

CONTRACT DOCUMENTS

© Hord Coplan Macht, Inc.

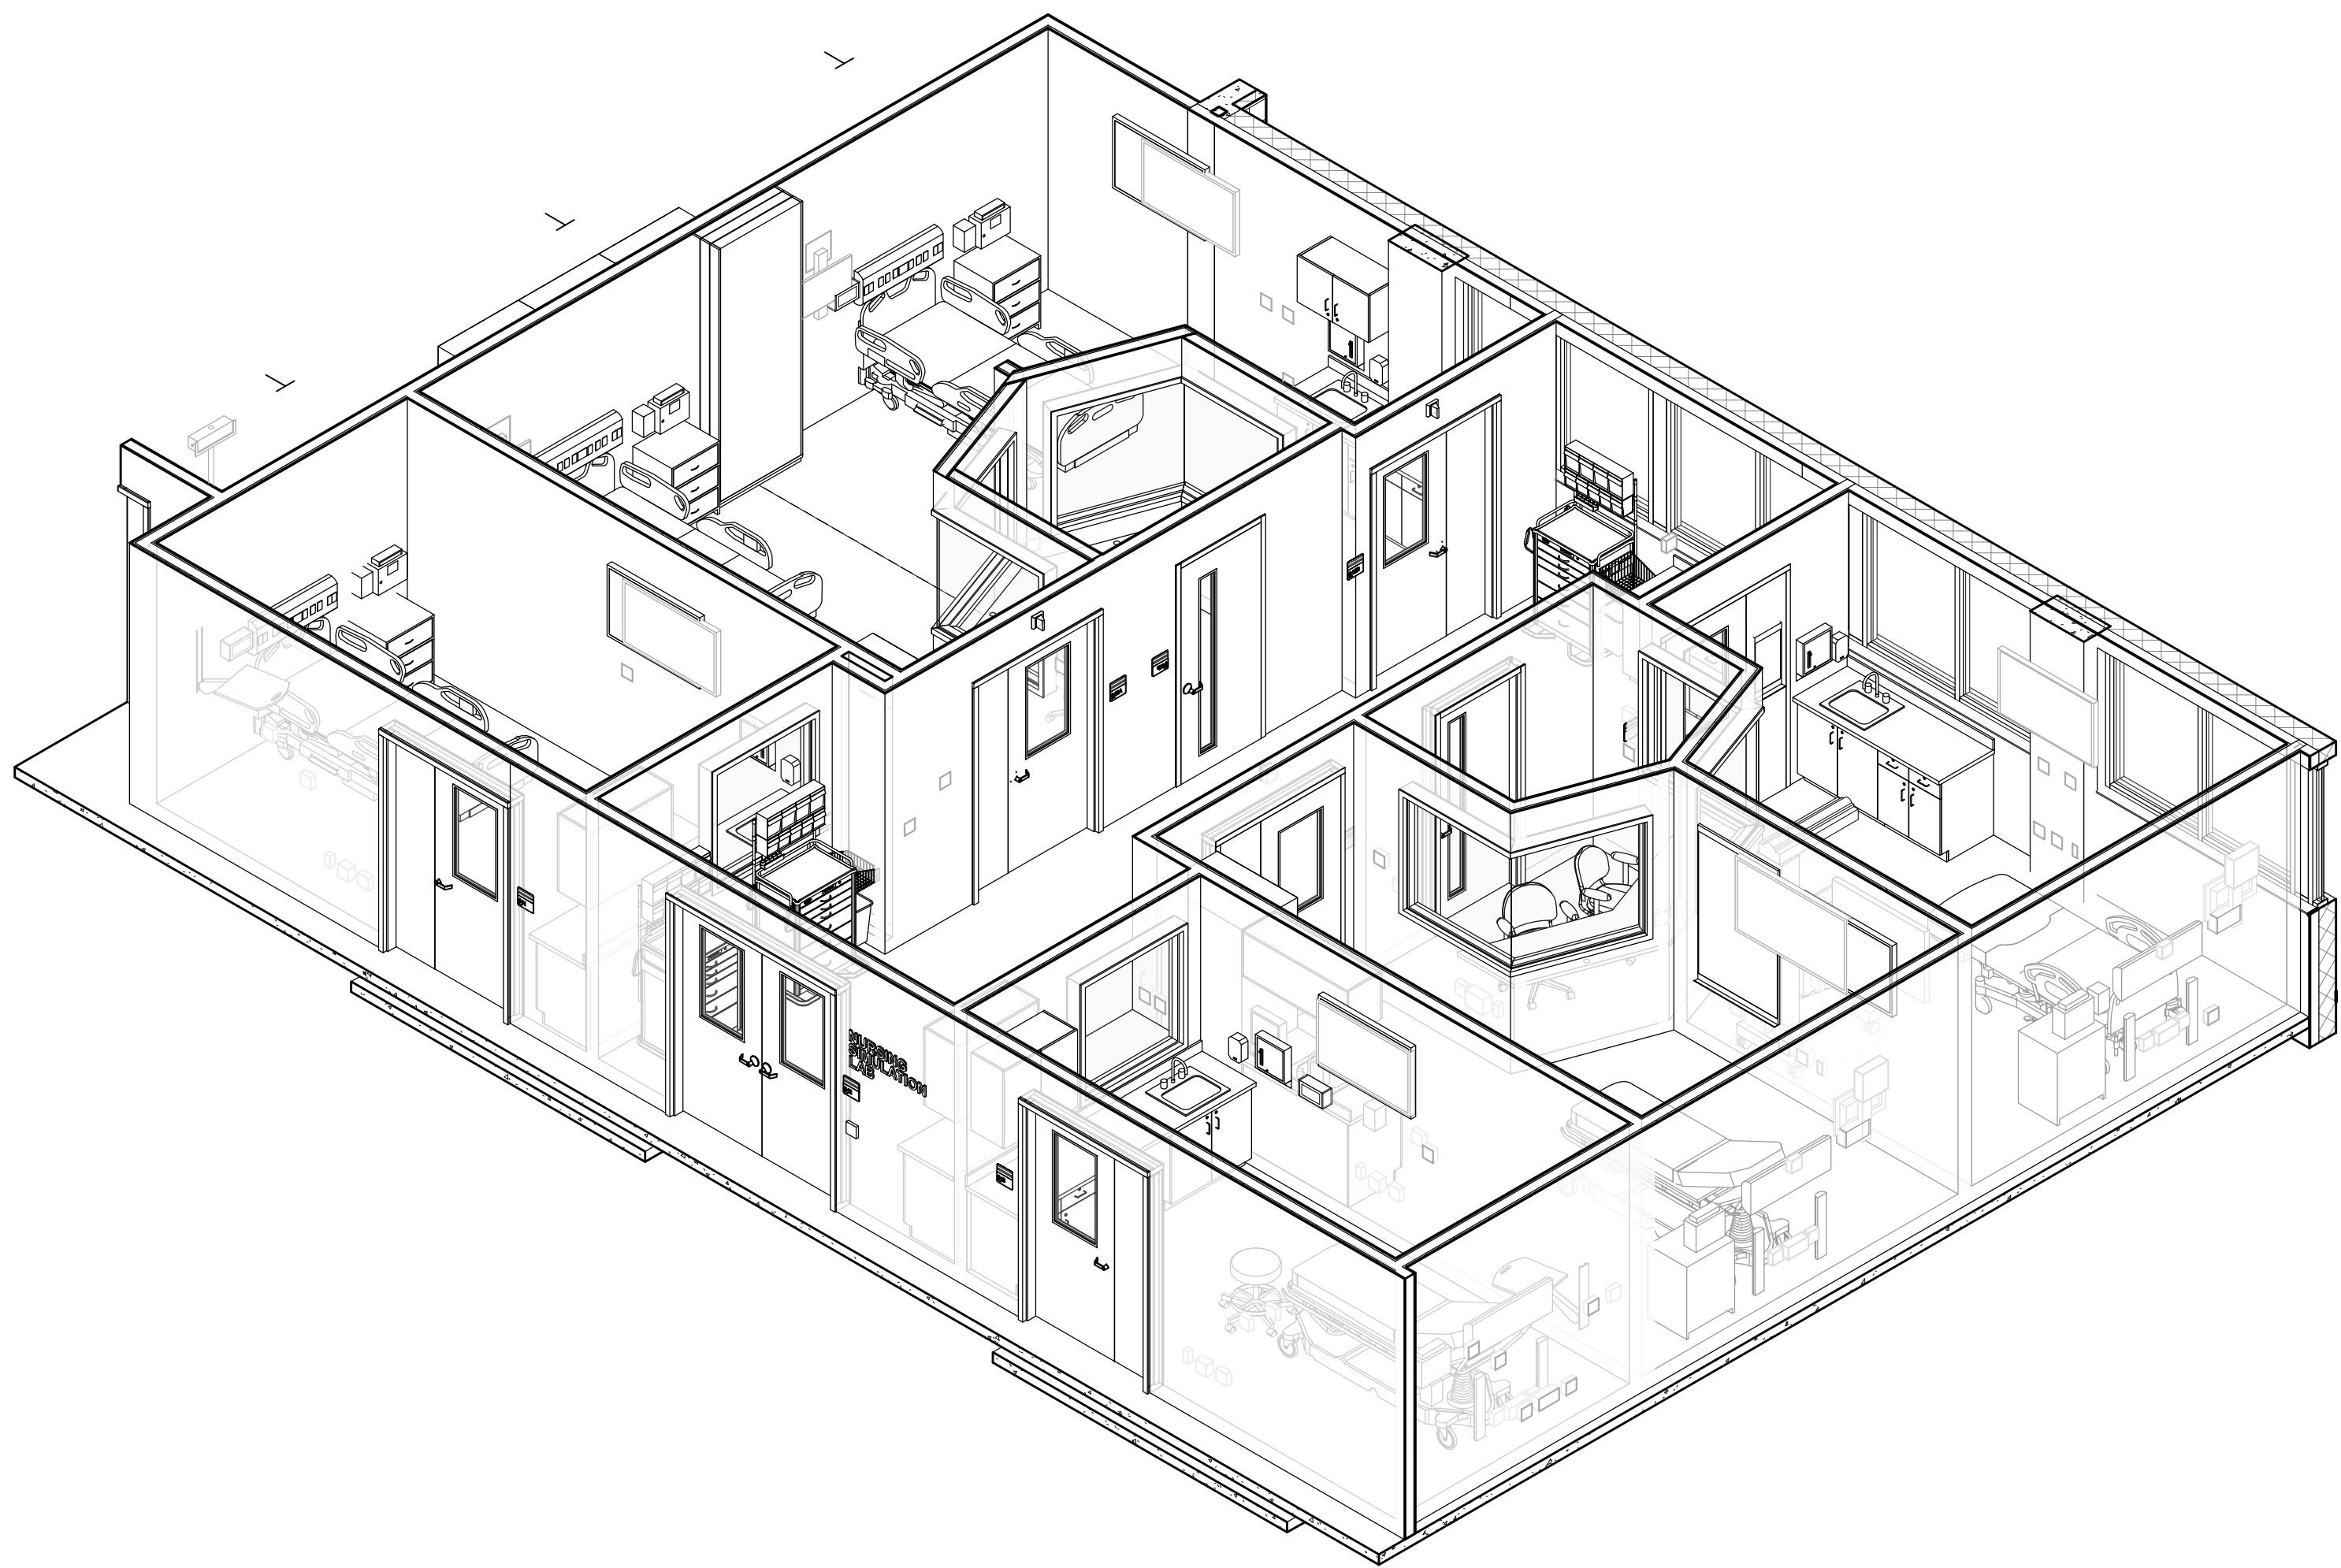

D1 3D VIEW - HIGH FIDELITY SIM LAB

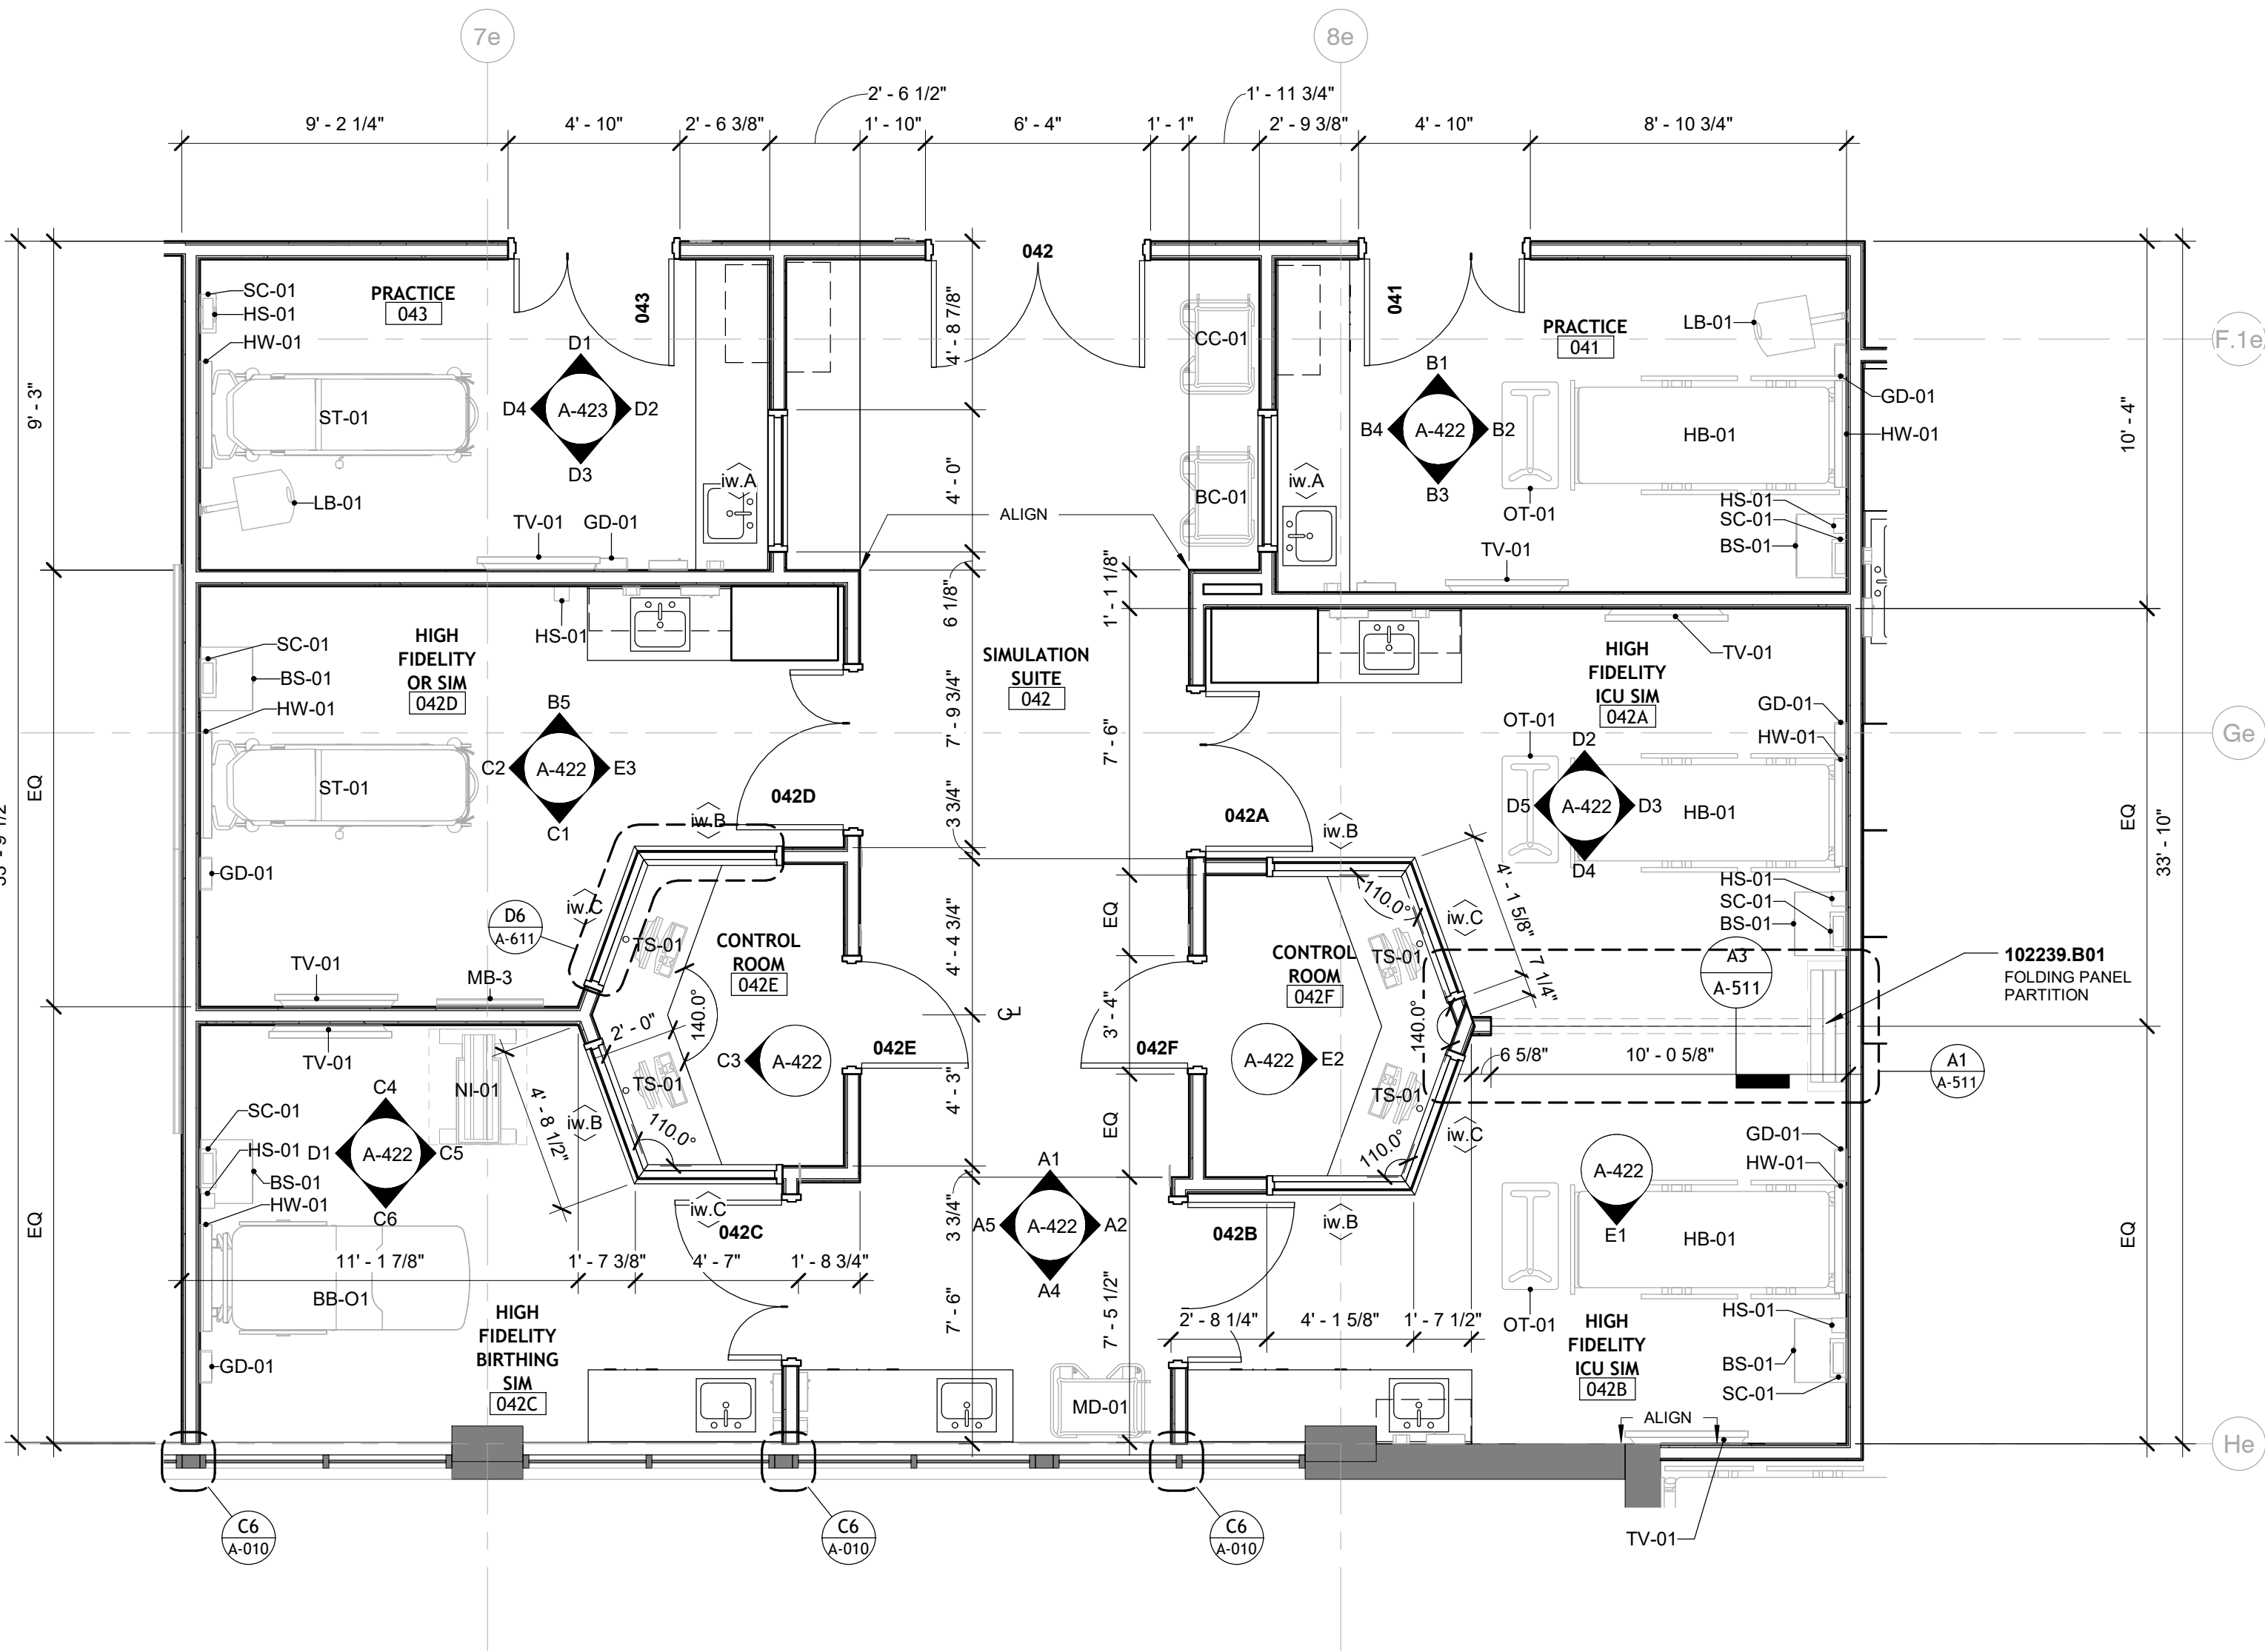

A1 ENLARGED PLAN - SIM SUITE

10/10/2021 5:56:47 PM I:\M\2022\1710.00 CM2 Nursing Sim Renovation\Sim Rooms_Chrome_0201.rvt

ELEVATION GENERAL NOTES

- GENERAL CONTRACTOR TO COORDINATE SCHEDULING OF ALL WORK WITH OWNER.
- GENERAL CONTRACTOR TO FIELD VERIFY ALL EXISTING CONDITIONS & DIMENSIONS. NOTIFY ARCHITECT IF DISCREPANCIES OCCUR.
- DO NOT SCALE DRAWINGS: NOTIFY ARCHITECT IF CRITICAL DIMENSIONS DO NOT APPEAR ON THE DRAWINGS.
- PROVIDE PROTECTION FOR FLOORS, WALLS & CEILINGS AT ALL EXISTING CONDITIONS TO REMAIN, INCLUDING TRAFFIC PATTERN FOR DELIVERY OF NEW CONSTRUCTION MATERIALS IN COMMON BUILDING AREAS. ANY DAMAGE TO EXISTING CONDITIONS SHALL BE REPAIRED AT NO COST TO THE OWNER.
- REFER TO MEP AND AV/IT DRAWINGS FOR ADDITIONAL INFORMATION.
- INTERIOR WALL PARTITION & SOFFIT DIMENSIONS SHOWN ARE TO FACE OF FINISH MATERIALS UNLESS NOTED OTHERWISE.
- ALL HEIGHTS AS SHOWN ARE FROM FINISHED FLOOR, UNLESS NOTED OTHERWISE.
- REFER TO A-140 SHEETS FOR FINISH LEGEND AND PLAN FOR FULL EXTENT OF INTERIOR FINISHES.
- ALL (WARDROBE) CABINETS TO HAVE LOCKS PER SPECIFICATIONS.
- CONTROL JOINTS AT EACH EDGE OF ALL DOOR FRAMES (CORRIDOR SIDE AND ROOM SIDE) AND EVERY 30 LINEAR FEET.
- CONFIRM MOUNTING LOCATIONS OF ALL WALL MOUNTED ACCESSORIES WITH OWNER.

SHEET NOTES - INTERIOR ELEVATIONS

NOTE #	NOTE
1	NEW WINDOW SILL, RE: SECTION DETAIL.
2	(N) WINDOW ROLLER SHADES - RE: FINISH SCHEDULE FOR TYPE AND FINISH.
3	NEW STAIR TREADS & RISERS, RBR-1.
4	NEW PAINT AT RAILING & STRINGER, MATCH EXISTING.
6	(E) WINDOW FRAME AND GLAZING TO REMAIN, PAINT FRAME.
7	WHITERBOARD FINISH ON OPERABLE PARTITION.
8	NURSE CALL STATION, TYP: OUTSIDE SIMULATION ROOMS (4 TOTAL), RE: AV/IT DWGS.


ARCHITECT
Hord Coplan Macht, Inc.
1852 Wazee Street, Suite 450
Denver, CO 80202
ph: 303.607.0877
URL: www.hcm2.com

ME/P ENGINEER
Cator, Ruma and Associates, Co.
896 Tabor Street
Lakewood, CO 80401
p. 303-232-6200
URL: www.catoruma.com

AV / IT
NV5
2650 18th Sty #202
Denver, CO 80211
ph: 303-220-6400
URL: www.nv5.com

COLORADO MOUNTAIN COLLEGE
NURSING RENOVATION
3000 Co Rd 114, Glenwood Springs, CO 81601

hord | coplan | macht
ARCHITECTURE
LANDSCAPE ARCHITECTURE
PLANNING
INTERIOR DESIGN

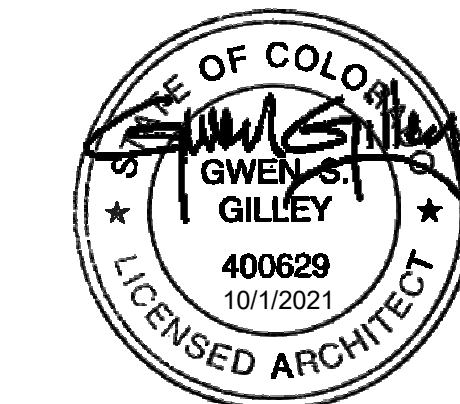

No. Date Revision

Project Name

NURSING RENOVATION

Project Number

22172.00

Date (YYYY/MM/DD)

10-01-2021

Drawn By

CK

Drawing

INTERIOR ELEVATIONS

Checked By


HRM

Interior Elevations

A-421


CONTRACT DOCUMENTS

© Hord Coplan Macht, Inc.

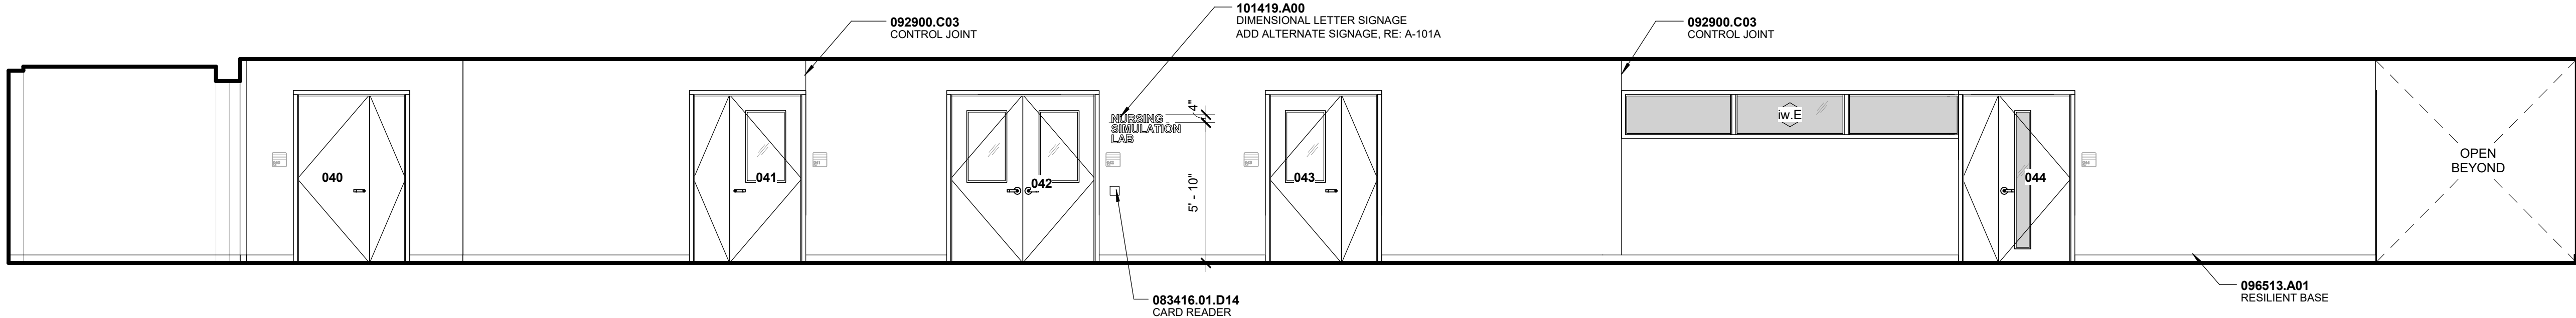


E1 CORRIDOR 047 - SOUTH

A-101 A-421 1/4" = 1'-0"

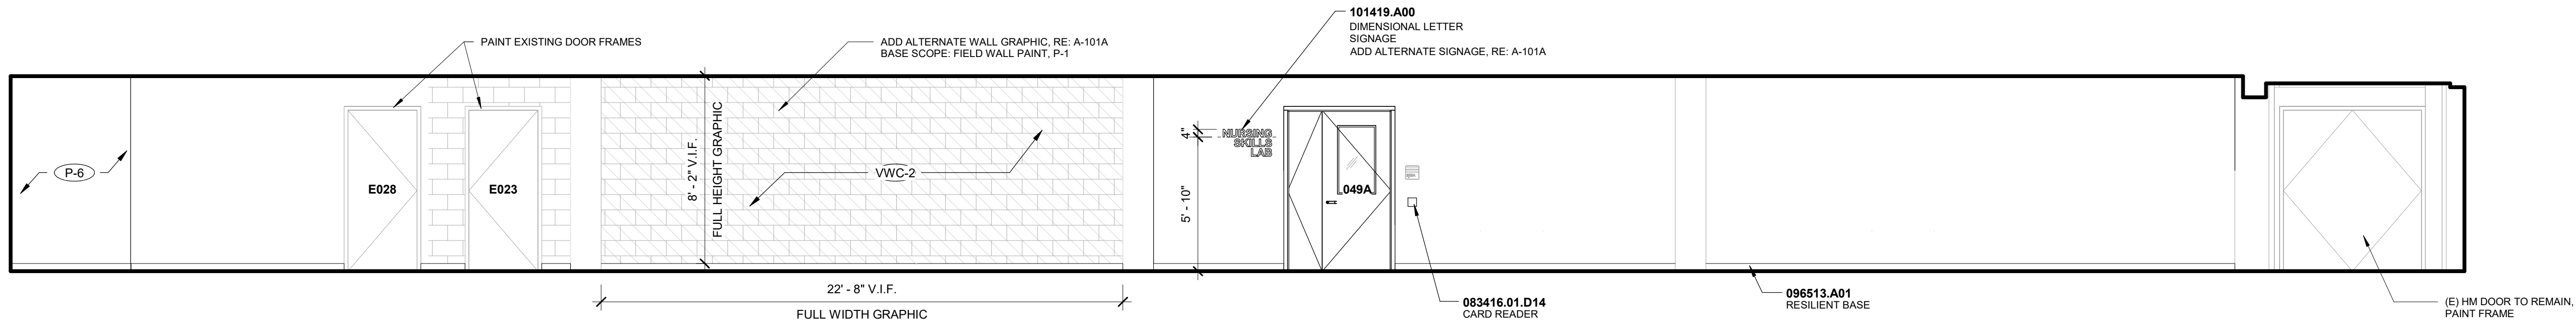


D1 CORRIDOR 047 - NORTH

A-101 A-421 1/4" = 1'-0"

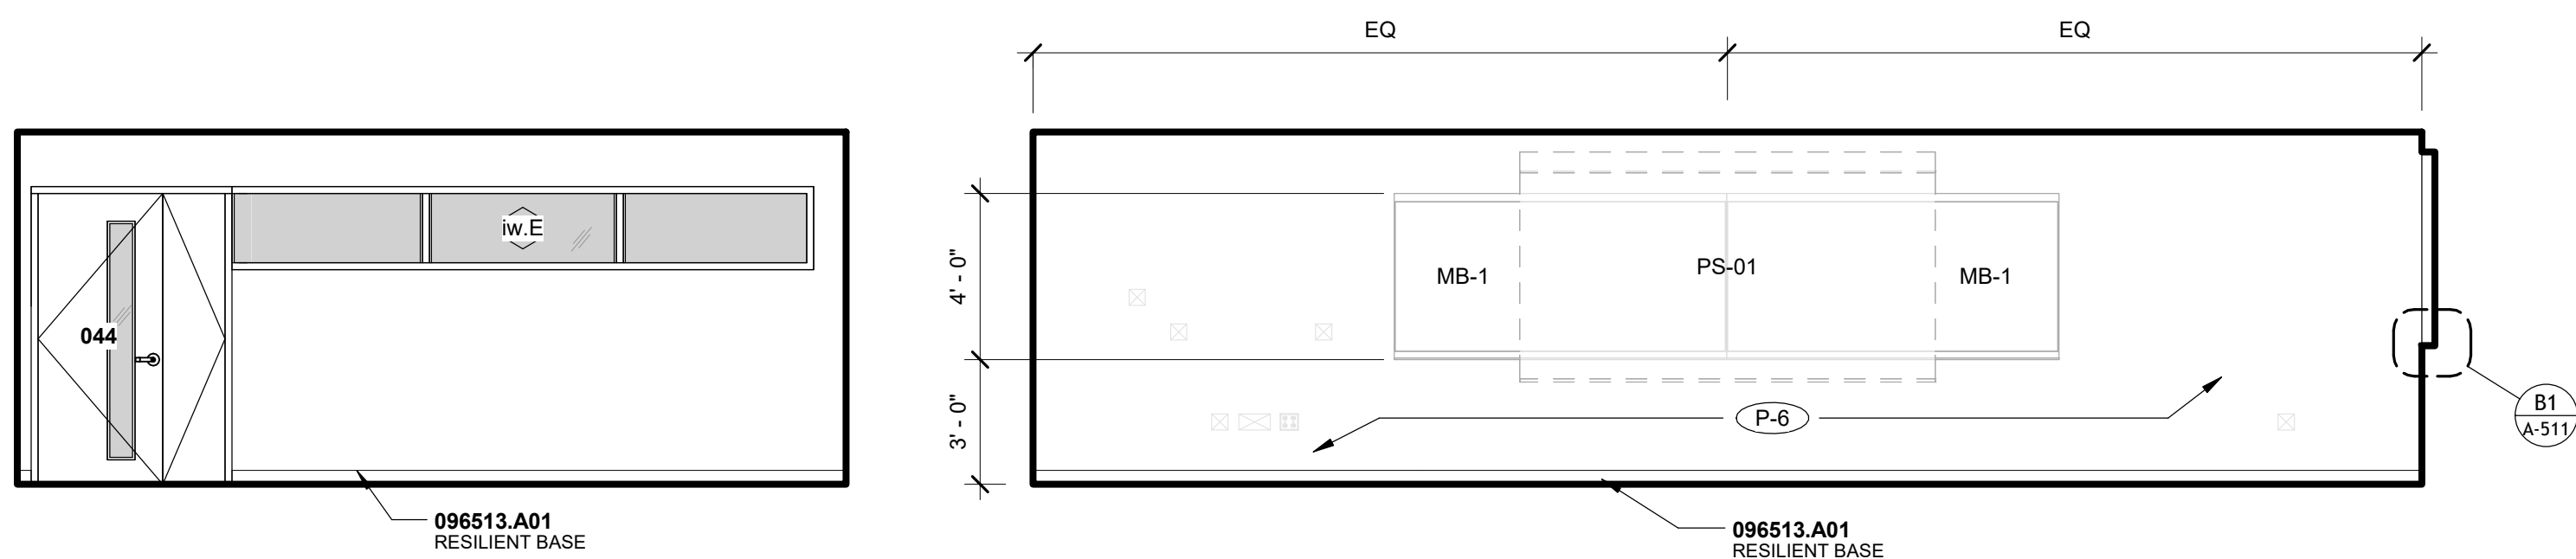


C1 GENERAL PURPOSE CLASSROOM 044 - NORTH

A-101 A-421 1/4" = 1'-0"

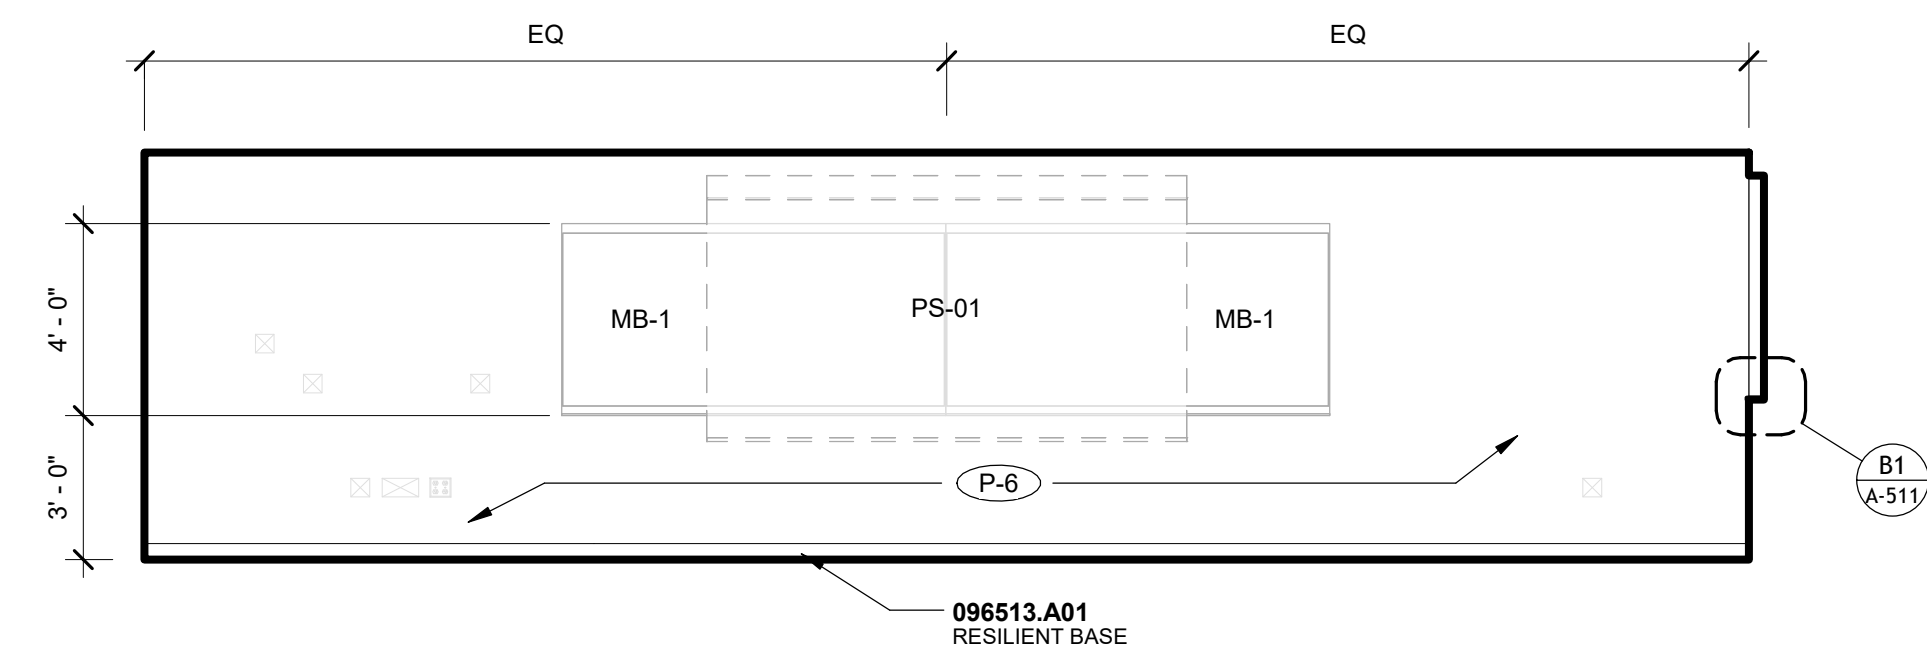


C2 GENERAL PURPOSE CLASSROOM 044 - EAST

A-101 A-421 1/4" = 1'-0"

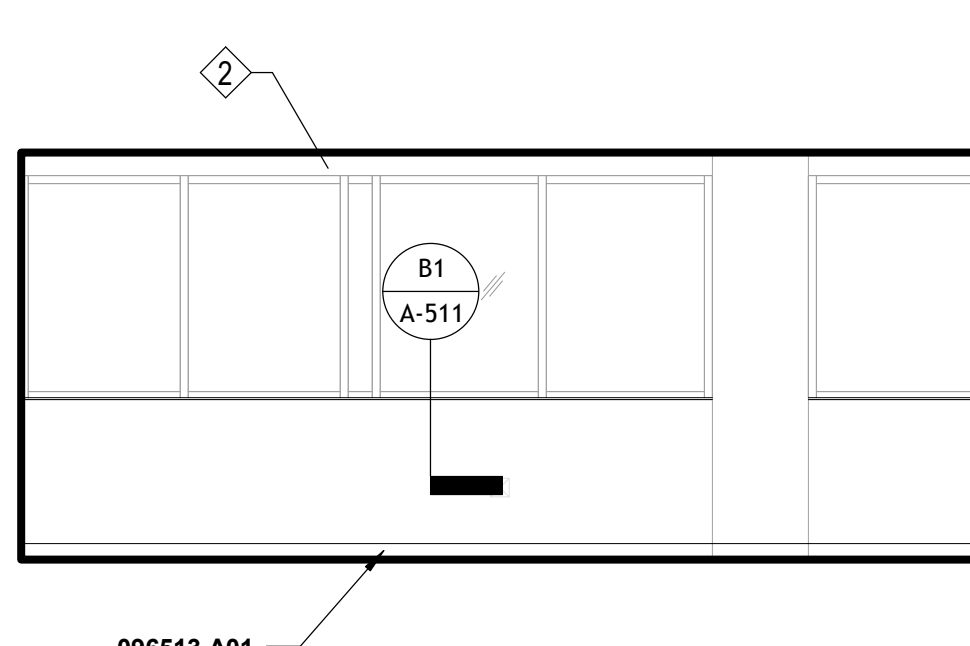


C4 GENERAL PURPOSE CLASSROOM 044 - SOUTH

A-101 A-421 1/4" = 1'-0"

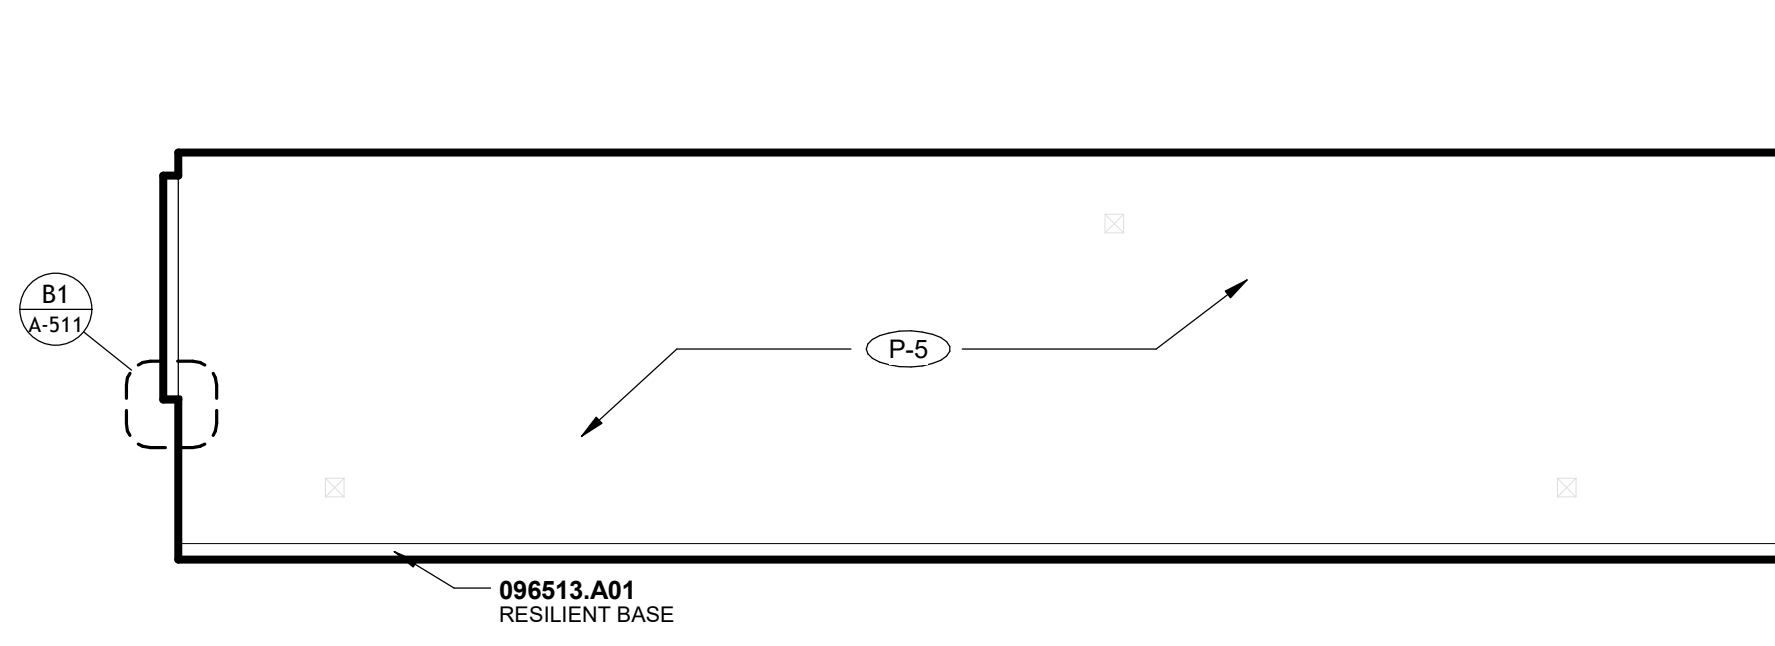


C5 GENERAL PURPOSE CLASSROOM 044 - WEST

A-101 A-421 1/4" = 1'-0"

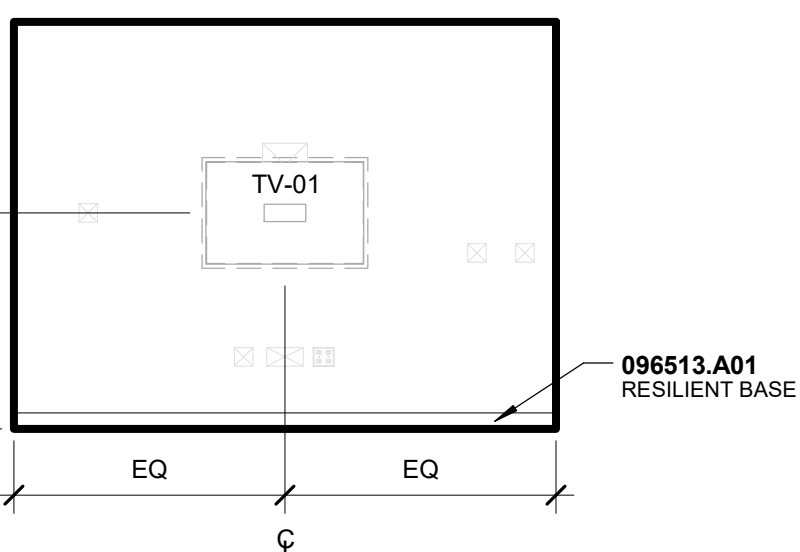


B1 GROUP STUDY 045 - SOUTH

A-101 A-421 1/4" = 1'-0"

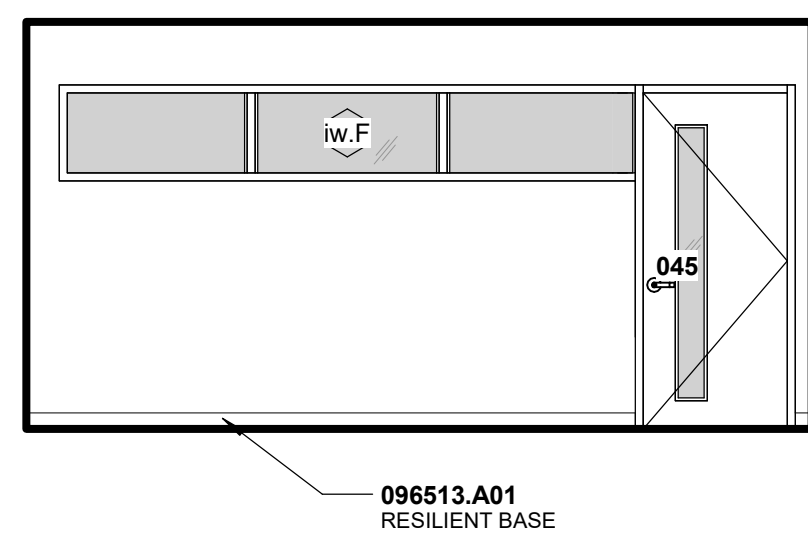


B2 GROUP STUDY 045 - WEST

A-101 A-421 1/4" = 1'-0"

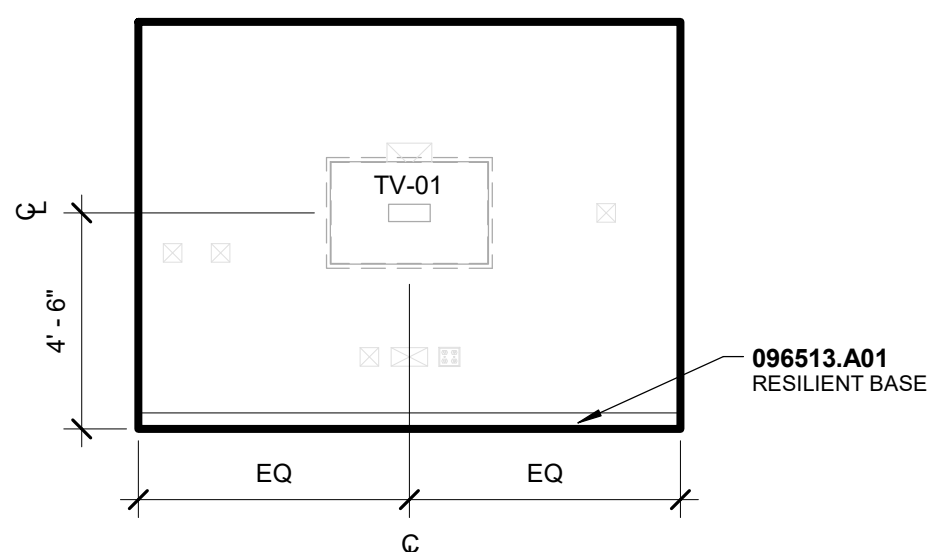


B3 GROUP STUDY 046 - NORTH

A-101 A-421 1/4" = 1'-0"

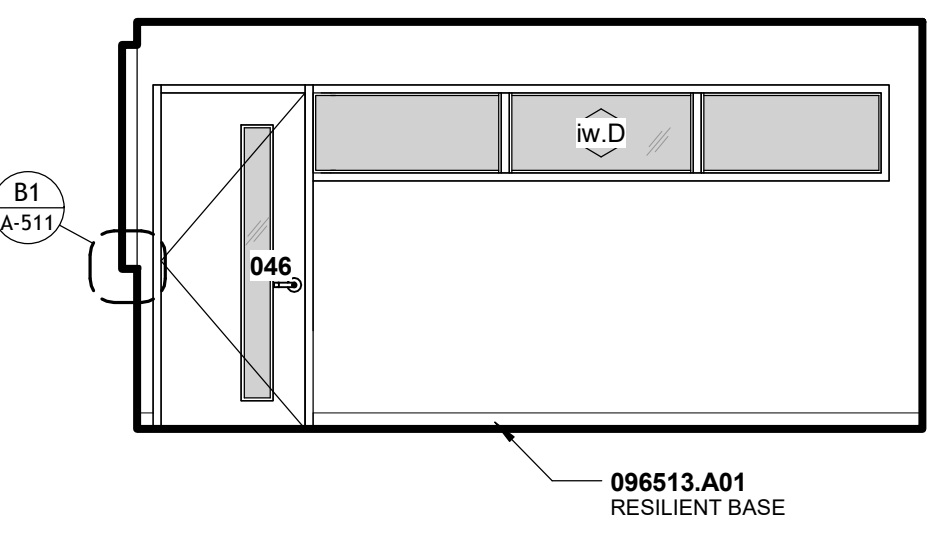


B4 GROUP STUDY 046 - WEST

A-101 A-421 1/4" = 1'-0"

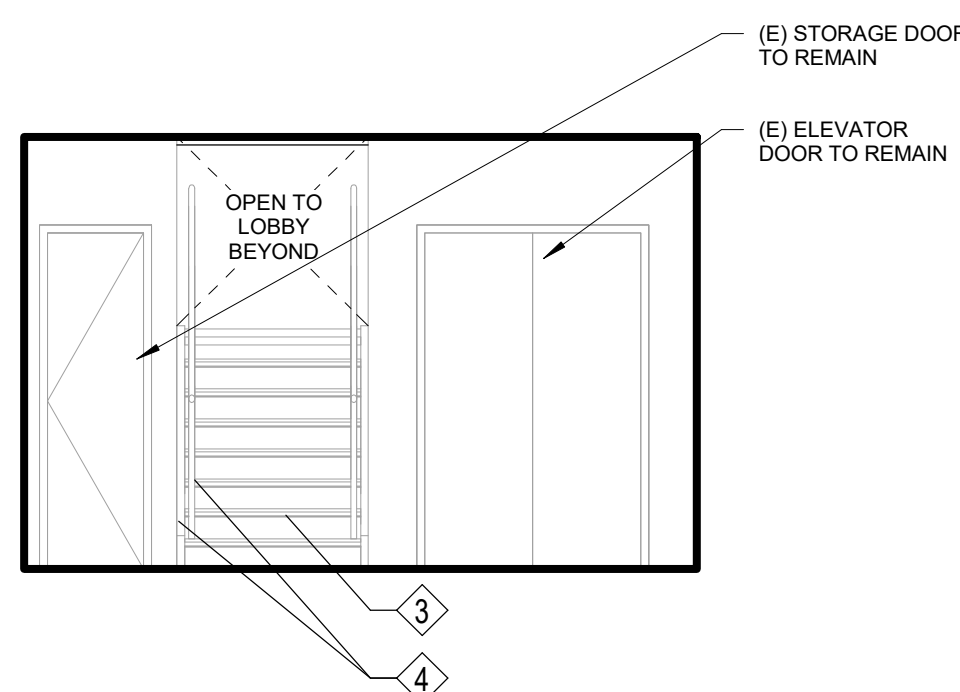


A1 (E) LOBBY - WEST

A-101 A-421 1/4" = 1'-0"

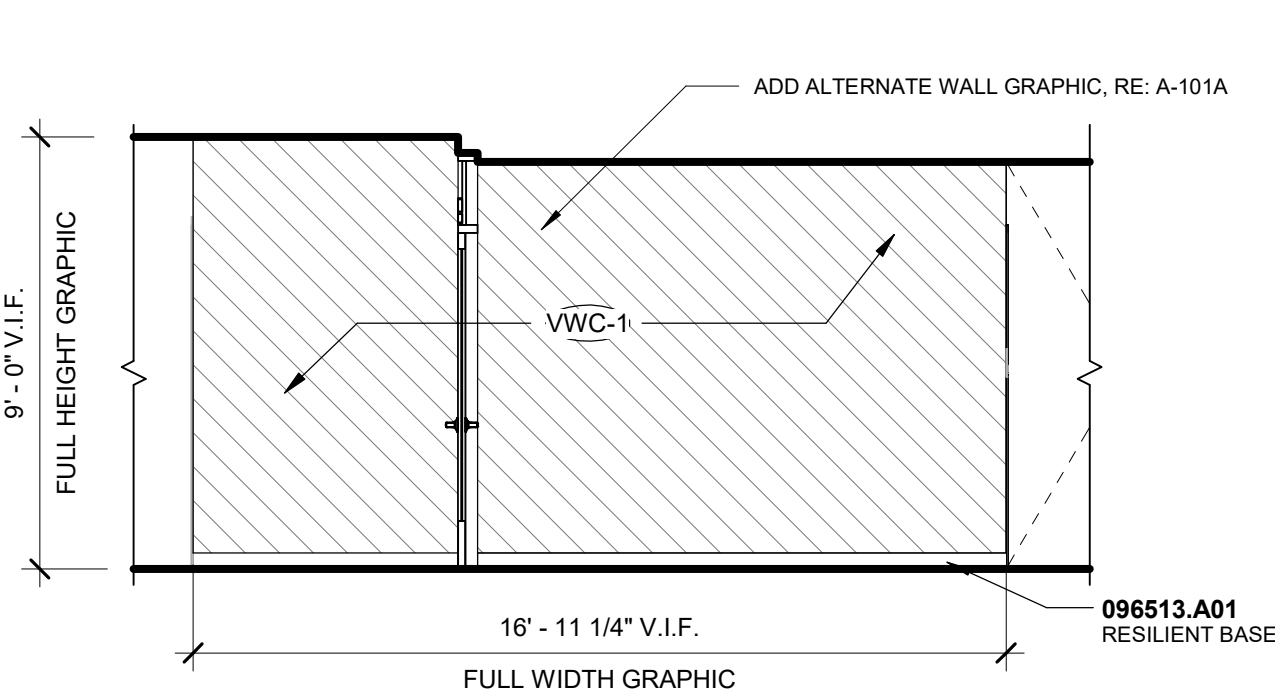


A2 (E) LOBBY - NORTH

A-101 A-421 1/4" = 1'-0"

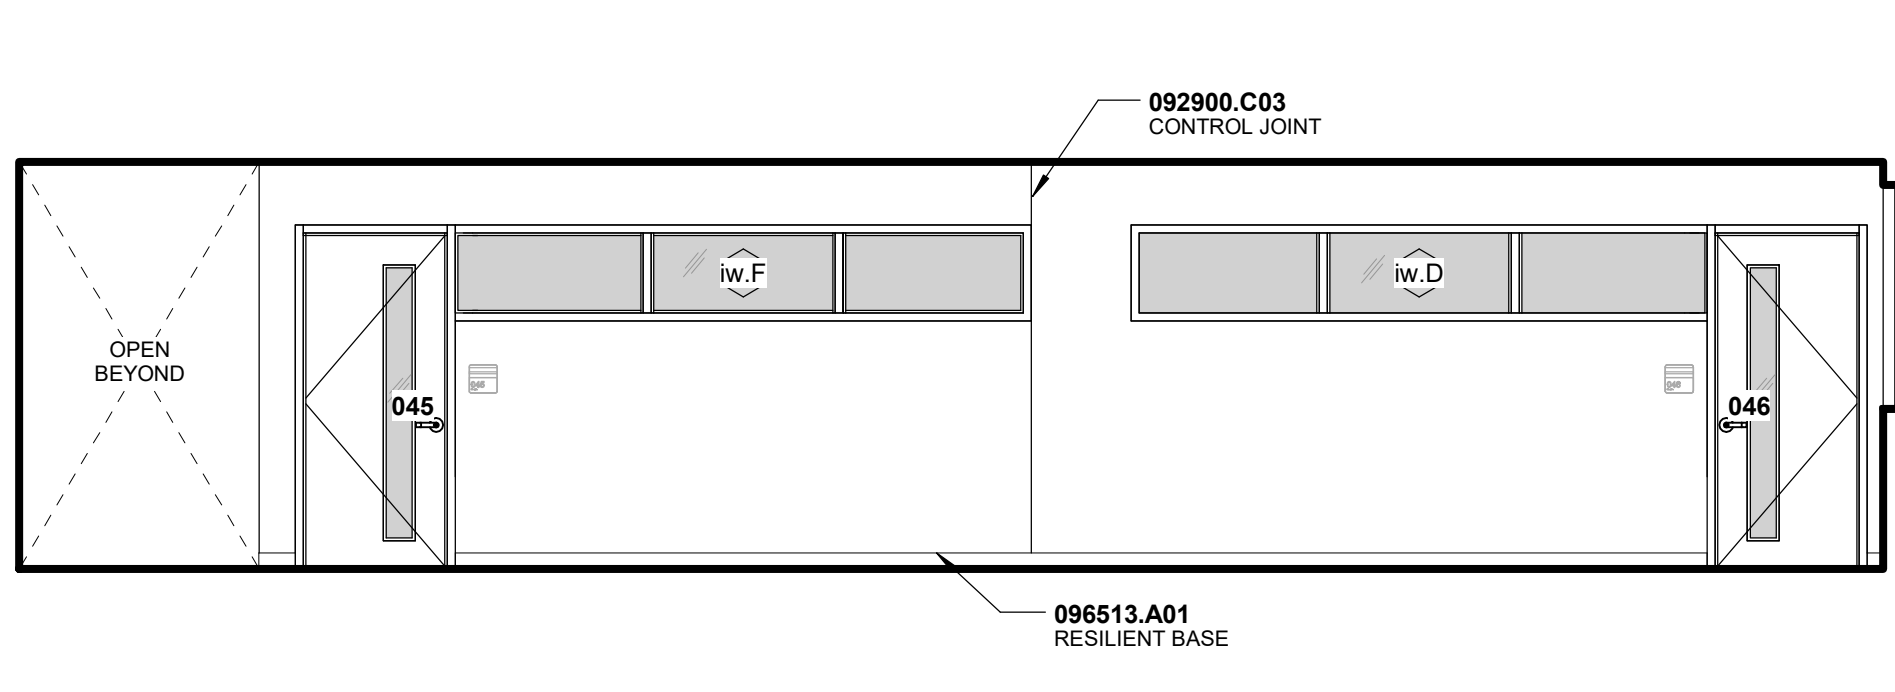

A3 CORRIDOR 047 - EAST

A-101 A-421 1/4" = 1'-0"

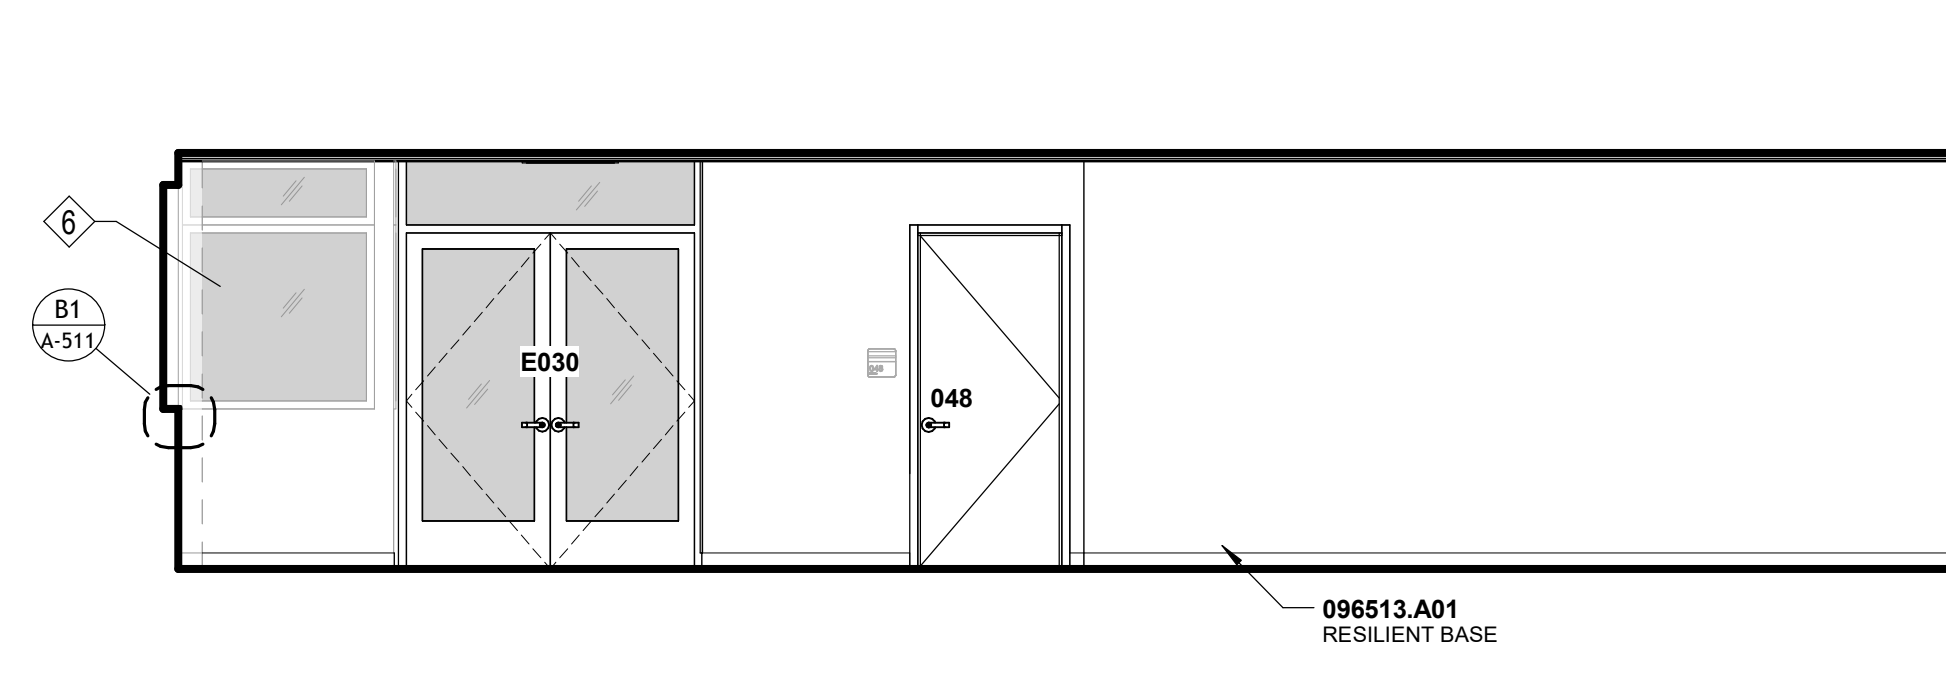

A5 INT ELEV - CORRIDOR 47 - W

A-101 A-421 1/4" = 1'-0"





(E) WOMEN'S RR




(E) MEN'S RR

(E) WALL OPENING TO BE INFILLED. INSTALL AND MATCH (E) PAINT, TILE, AND TILE PATTERN AT ADJACENT WALLS. PHOTO OF (E) RR PROVIDED FOR REFERENCE.

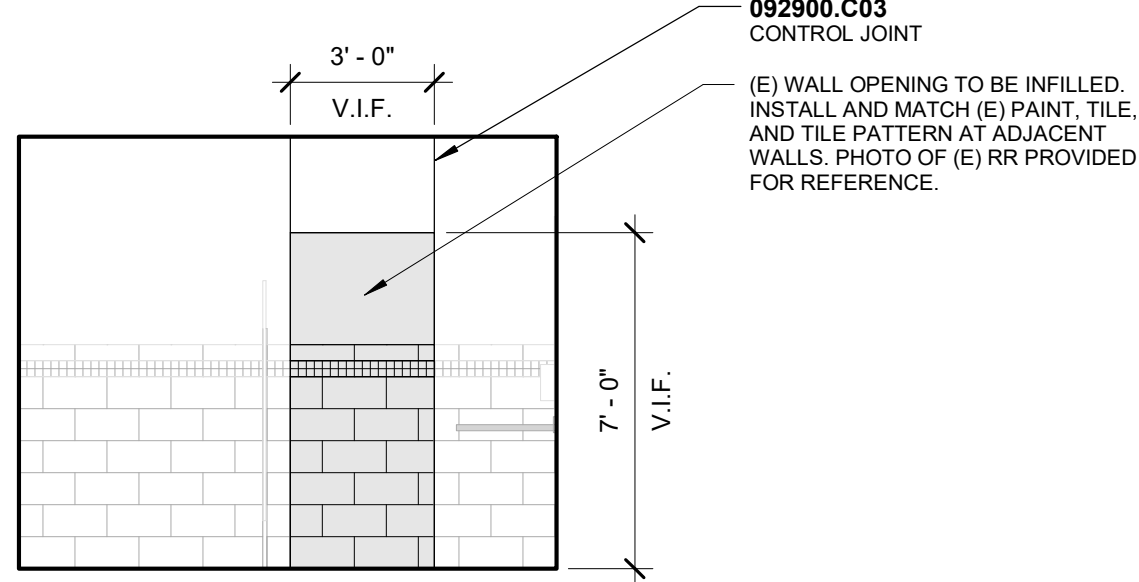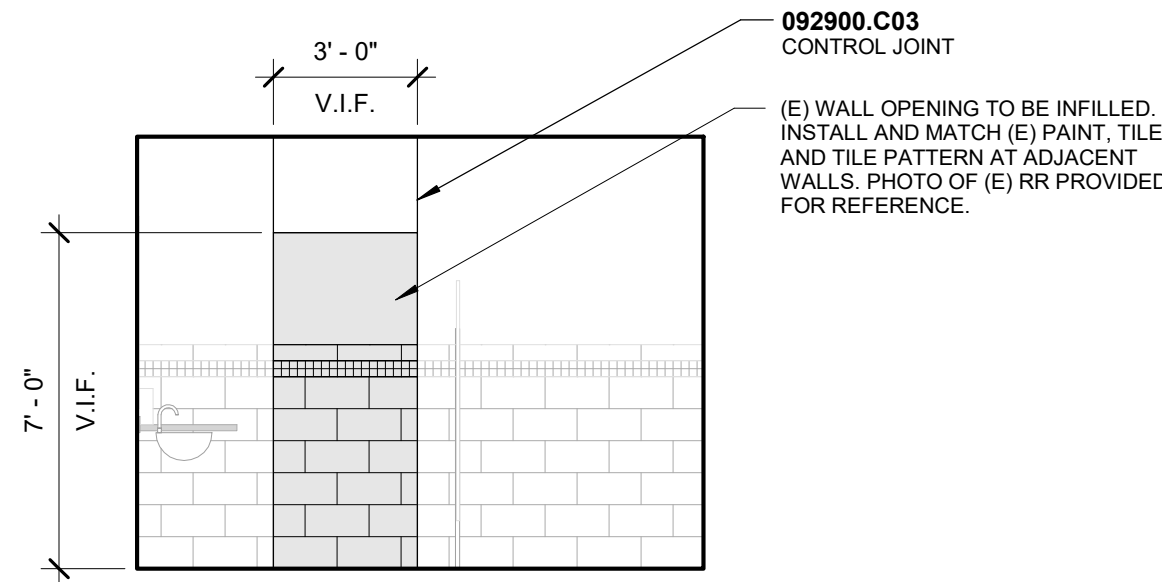


E1 (E) RR OPENING AND FINISHES

A-423 1/4" = 1'-0"

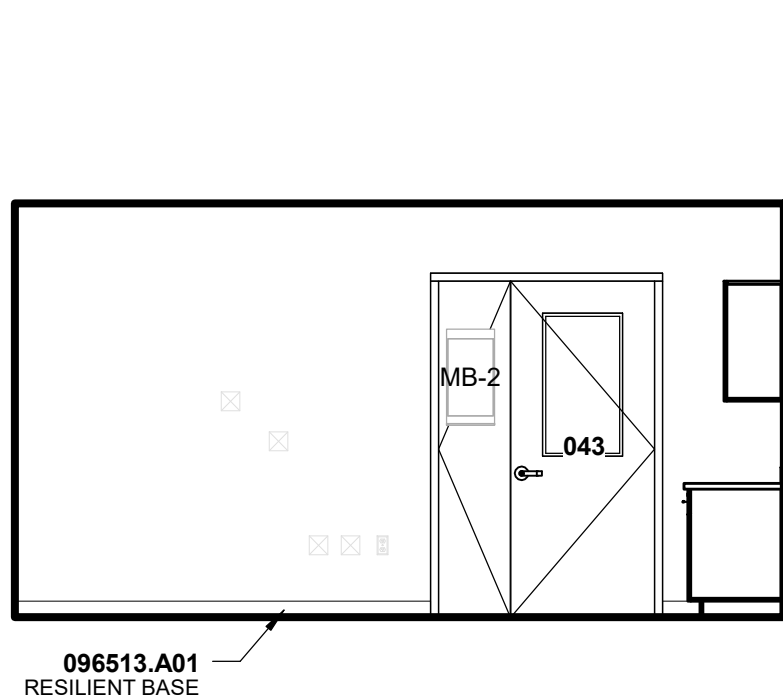

D1 PRACTICE 043 - NORTH

A-142 A-423 1/4" = 1'-0"

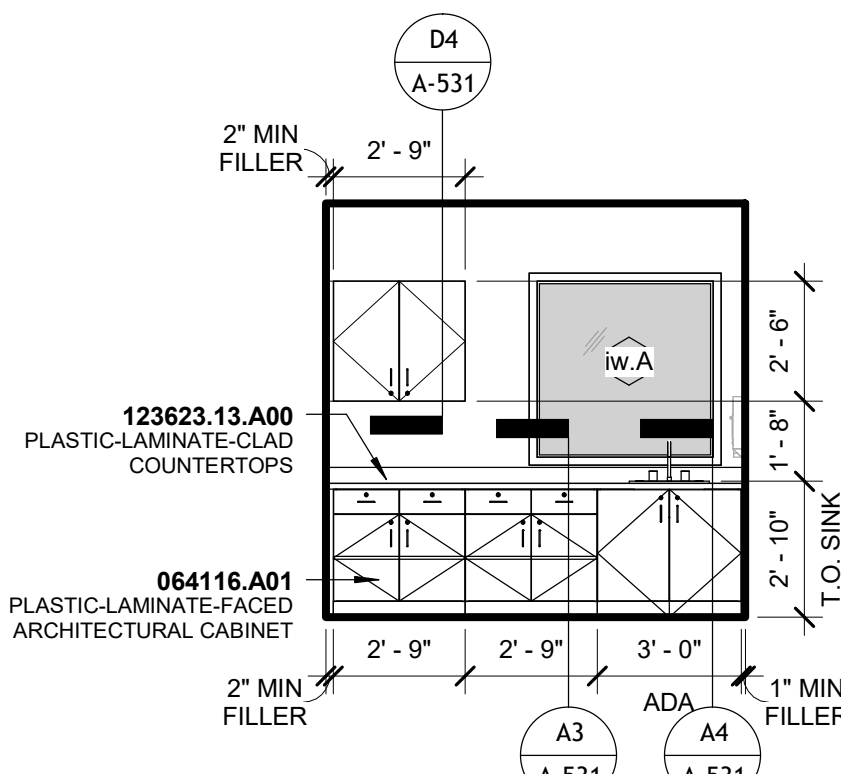


D2 PRACTICE 043 - EAST

A-142 A-423 1/4" = 1'-0"

E3 (E) W RR - EAST

A-101 A-423 1/4" = 1'-0"

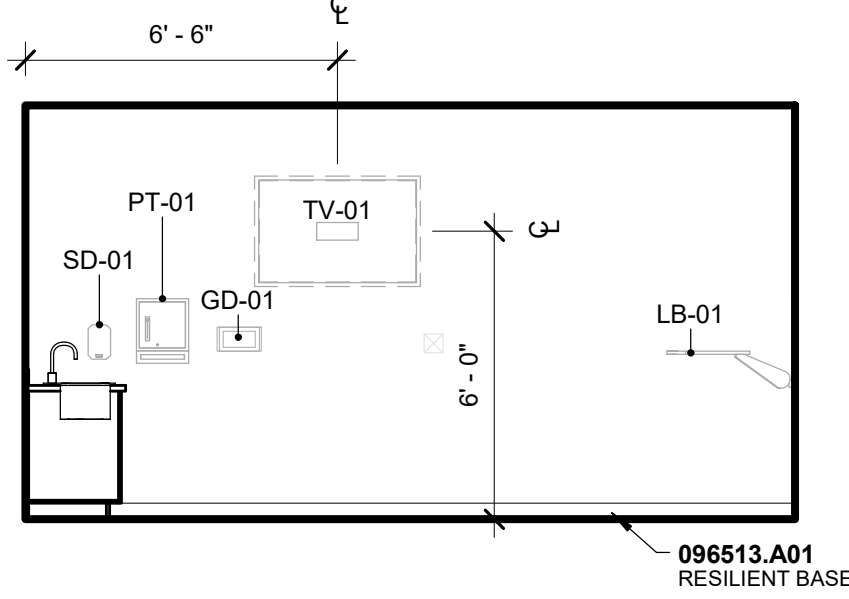


D3 PRACTICE 043 - SOUTH

A-142 A-423 1/4" = 1'-0"


E4 (E) M RR - EAST

A-101 A-423 1/4" = 1'-0"

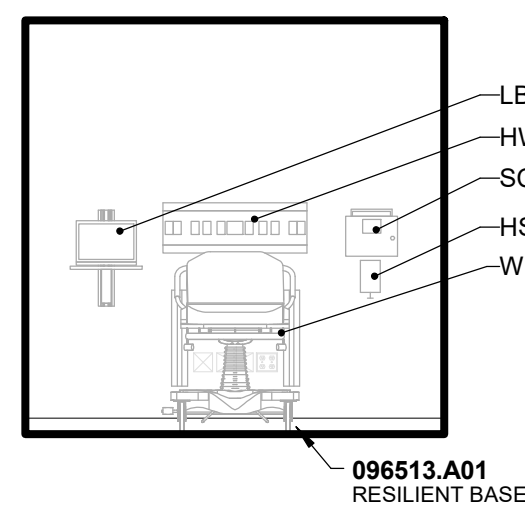


D4 PRACTICE 043 - WEST

A-142 A-423 1/4" = 1'-0"

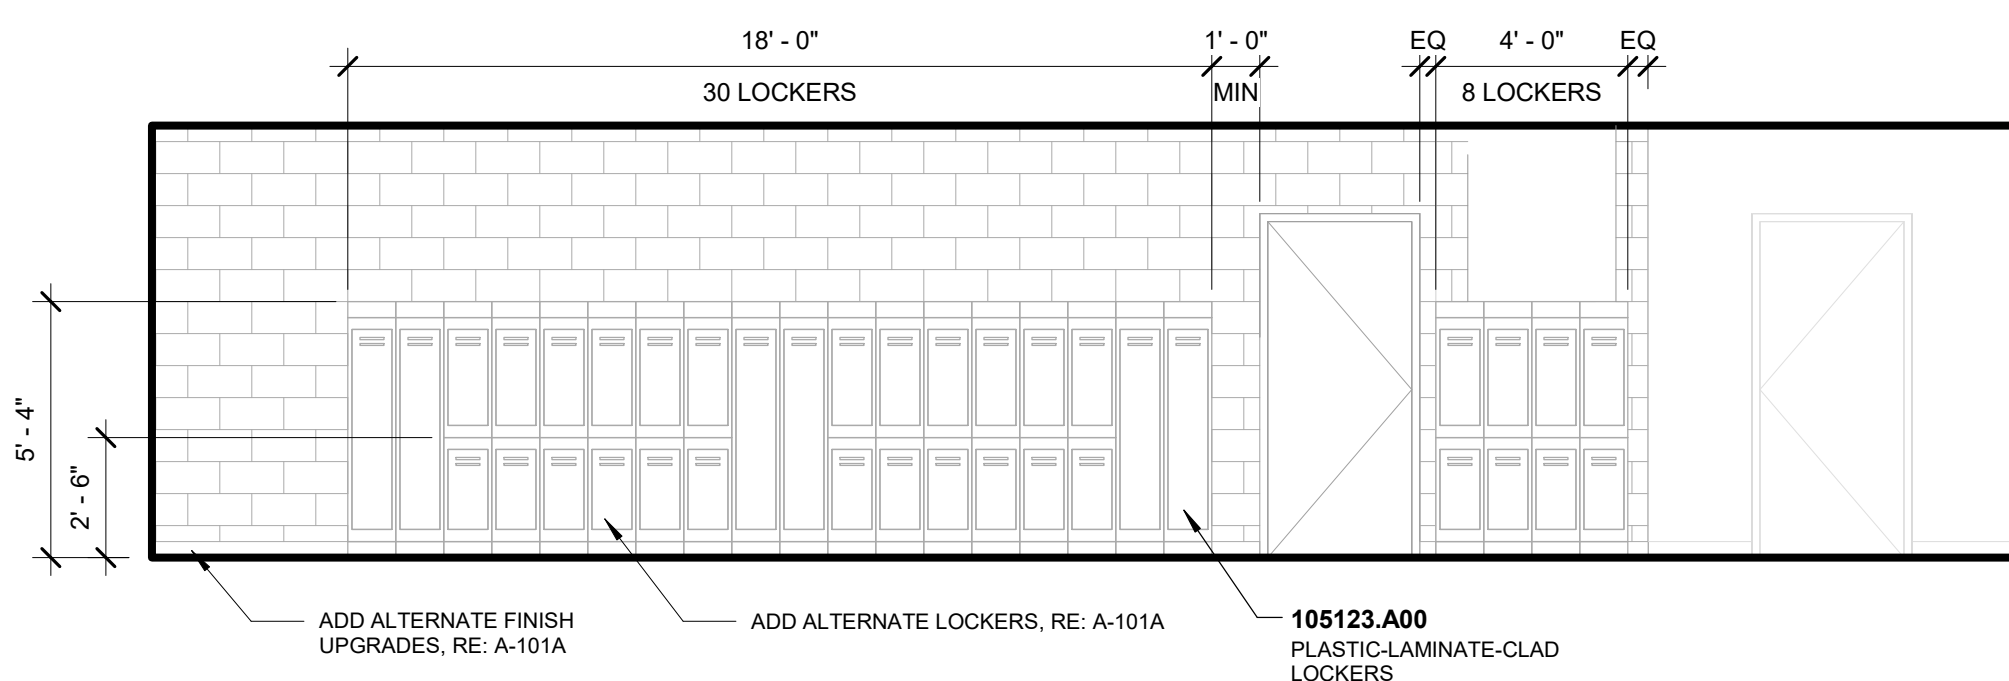


C1 (E) CORRIDOR 016 - WEST

A-101 A-423 1/4" = 1'-0"

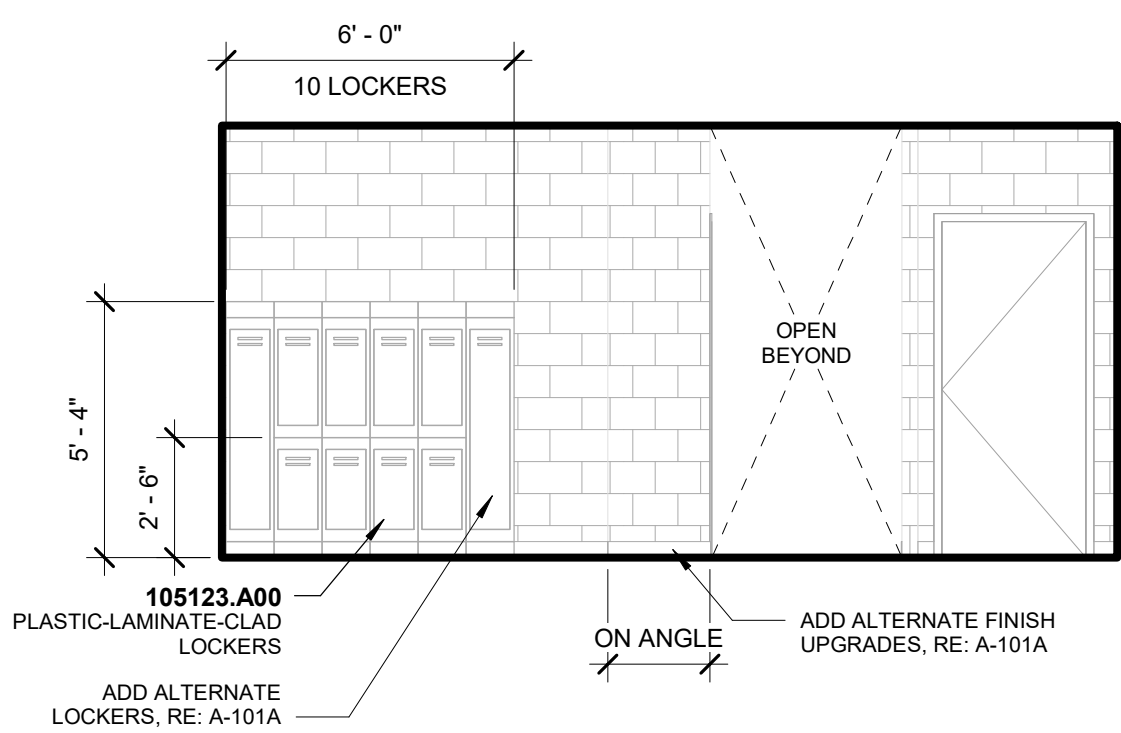


C3 (E) CORRIDOR 016 - EAST

A-101 A-423 1/4" = 1'-0"

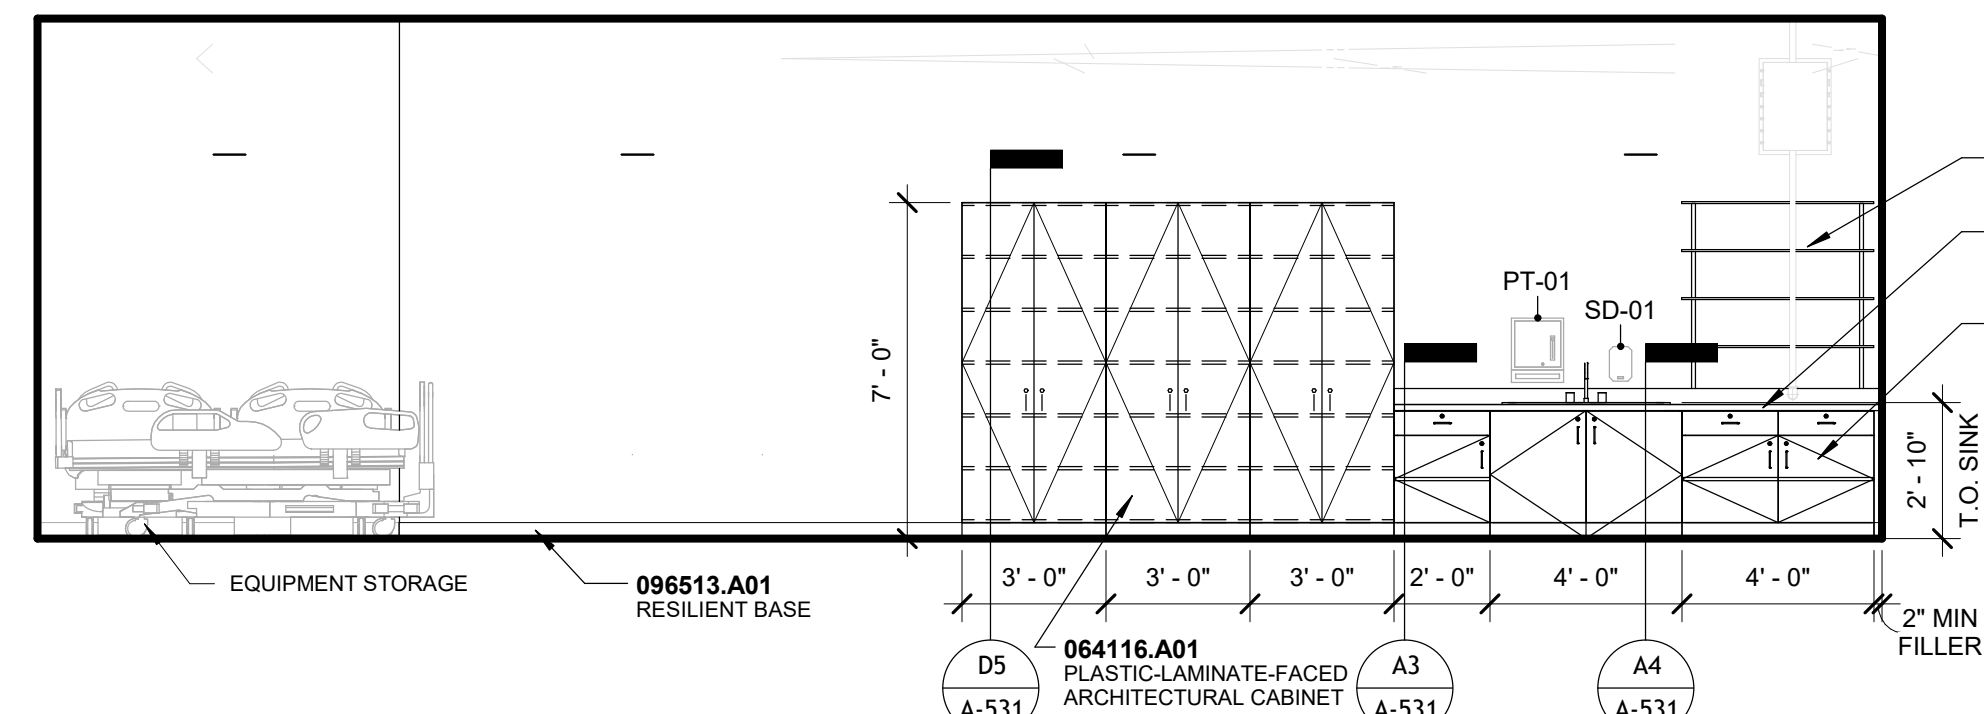


C4 STORAGE 040 - WEST

A-101 A-423 1/4" = 1'-0"

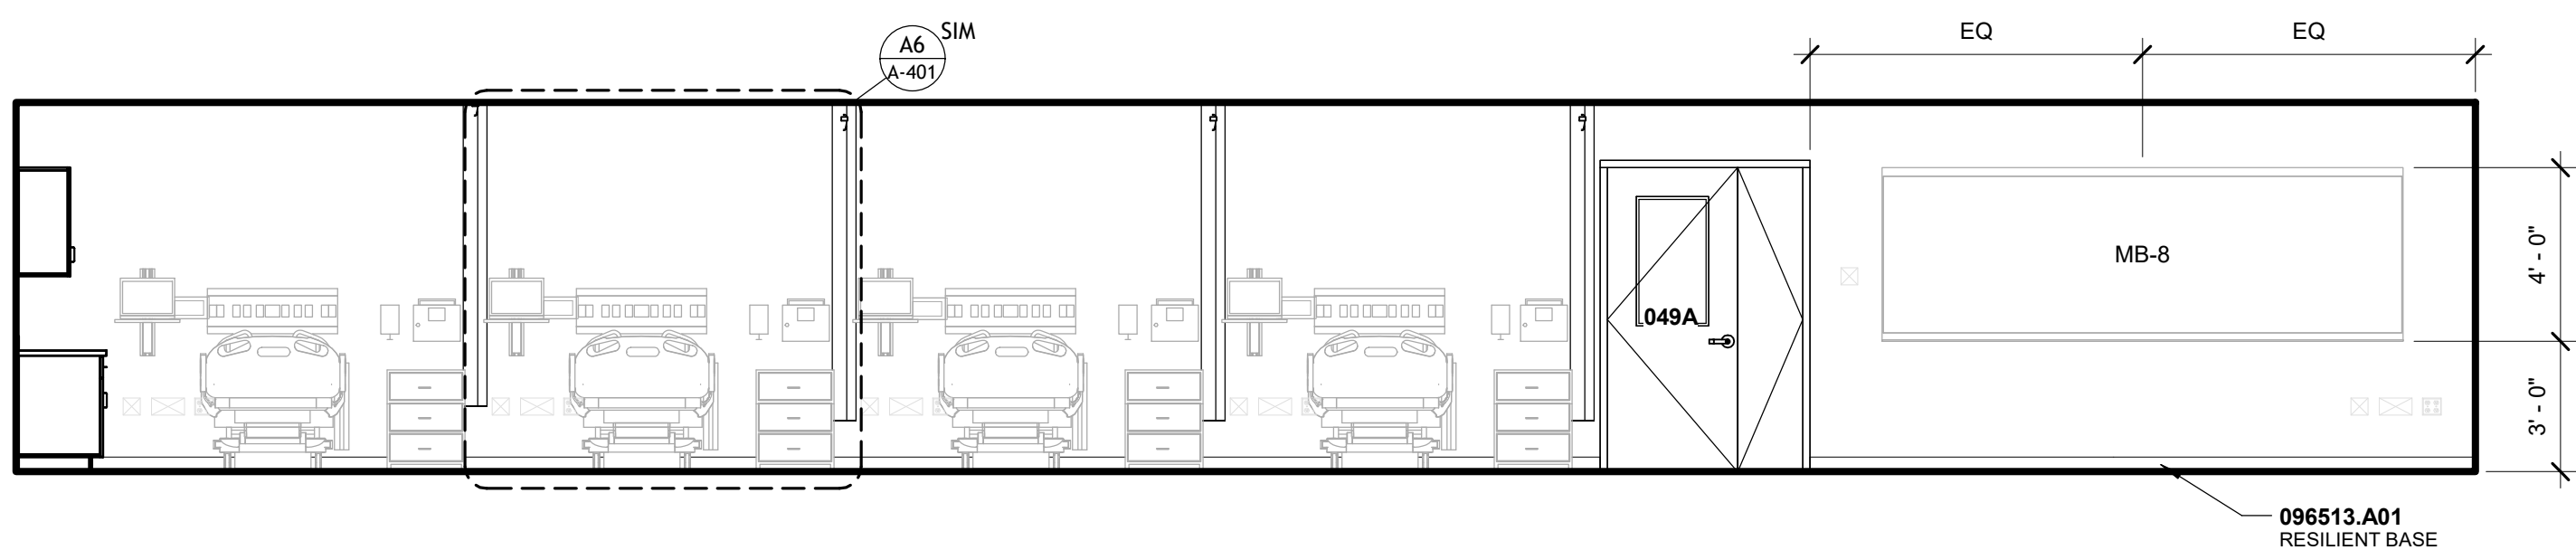


B1 NURSING SKILLS LAB 049- SOUTH

A-142 A-423 1/4" = 1'-0"

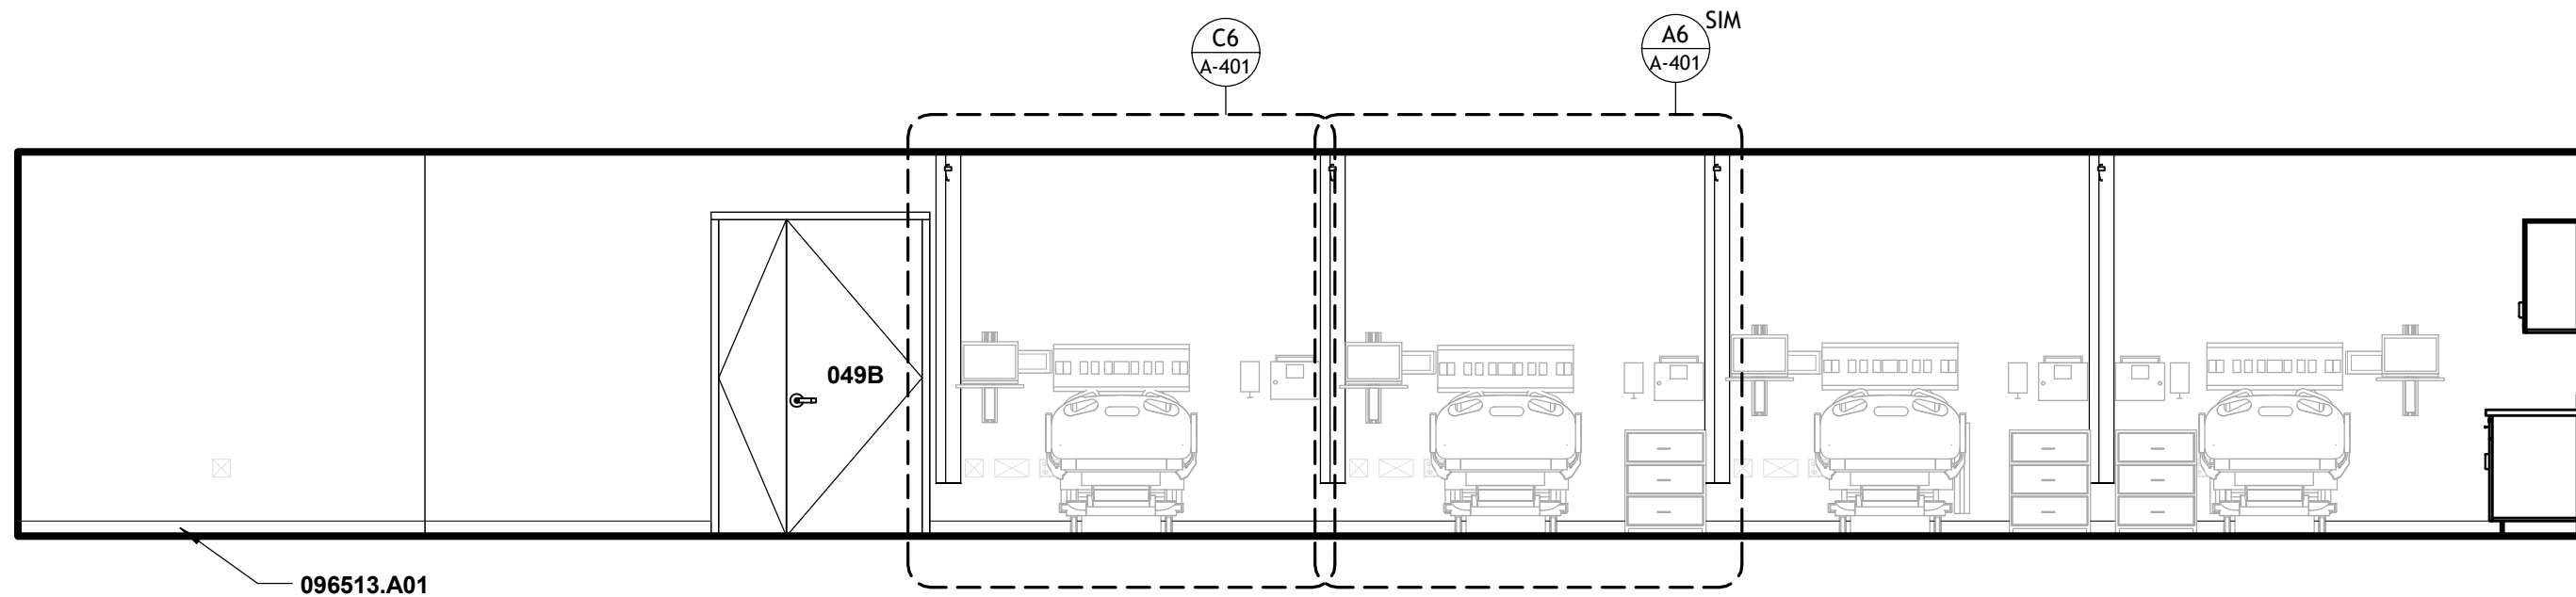


A1 NURSING SKILLS LAB 049 - NORTH

A-142 A-423 1/4" = 1'-0"

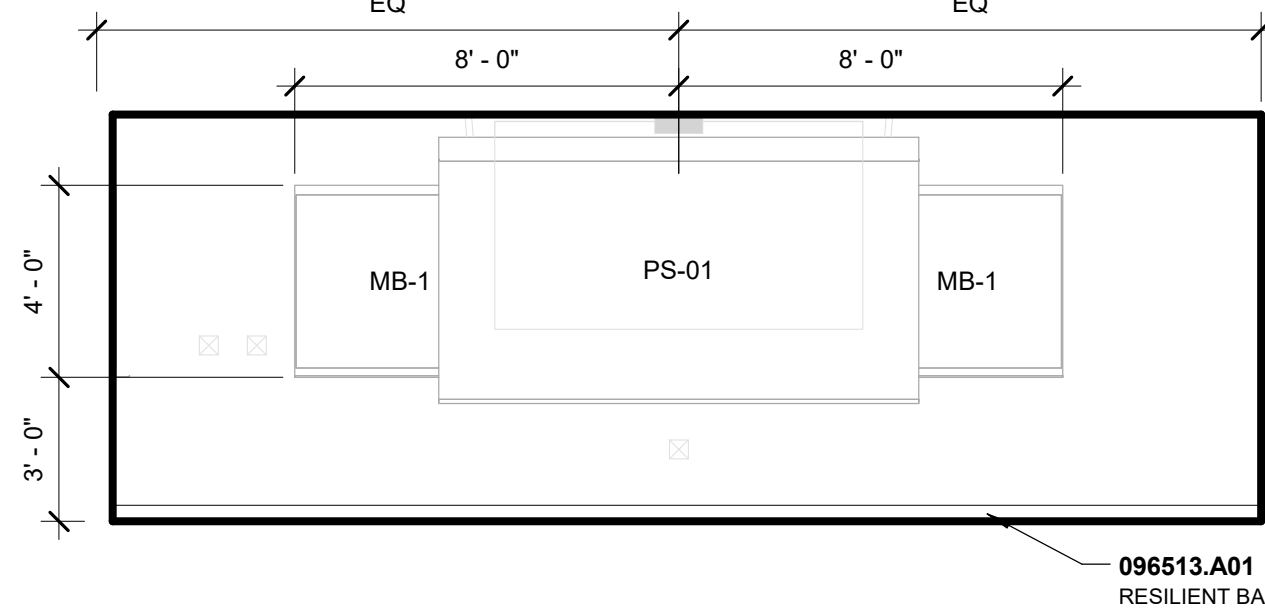

B4 NURSING SKILLS LAB 049 - WEST

A-142 A-423 1/4" = 1'-0"

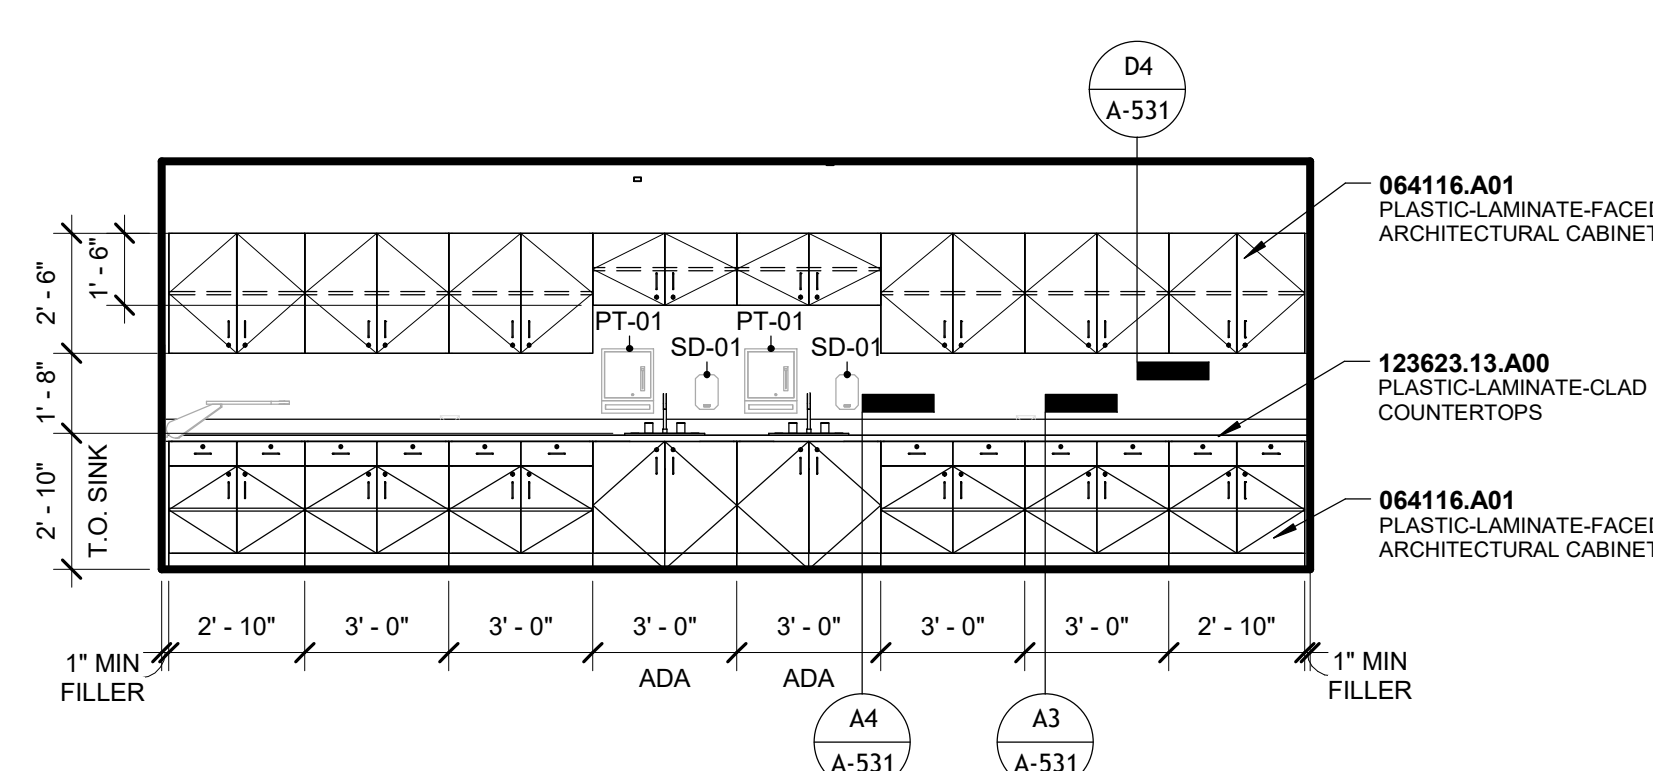

A4 NURSING SKILLS LAB 049 - EAST

A-142 A-423 1/4" = 1'-0"

ELEVATION GENERAL NOTES

- GENERAL CONTRACTOR TO COORDINATE SCHEDULING OF ALL WORK WITH OWNER.
- GENERAL CONTRACTOR TO FIELD VERIFY ALL EXISTING CONDITIONS & DIMENSIONS. NOTIFY ARCHITECT IF DISCREPANCIES OCCUR.
- DO NOT SCALE DRAWINGS. NOTIFY ARCHITECT IF CRITICAL DIMENSIONS DO NOT APPEAR ON THE DRAWINGS.
- PROVIDE PROTECTION FOR FLOORS, WALLS & CEILINGS AT ALL EXISTING CONDITIONS TO REMAIN, INCLUDING TRAFFIC PATTERN FOR DELIVERY OF NEW CONSTRUCTION MATERIALS IN COMMON BUILDING AREAS. ANY DAMAGE TO EXISTING CONDITIONS SHALL BE REPAIRED AT NO COST TO THE OWNER.
- REFER TO MEP AND AV/IT DRAWINGS FOR ADDITIONAL INFORMATION.
- INTERIOR WALL PARTITION & SOFFIT DIMENSIONS SHOWN ARE TO FACE OF FINISH MATERIALS UNLESS NOTED OTHERWISE.
- ALL HEIGHTS AS SHOWN ARE FROM FINISHED FLOOR, UNLESS NOTED OTHERWISE.
- REFER TO A-140 SHEETS FOR FINISH LEGEND AND PLAN FOR FULL EXTENT OF INTERIOR FINISHES
- ALL (WARDROBE) CABINETS TO HAVE LOCKS PER SPECIFICATIONS
- CONTROL JOINTS AT EACH EDGE OF ALL DOOR FRAMES (CORRIDOR SIDE AND ROOM SIDE) AND EVERY 30 LINEAR FEET
- CONFIRM MOUNTING LOCATIONS OF ALL WALL MOUNTED ACCESSORIES WITH OWNER.

SHEET NOTES - INTERIOR ELEVATIONS

NOTE #	NOTE
1	NEW WINDOW SILL, RE: SECTION DETAIL
2	(N) WINDOW ROLLER SHADES - RE: FINISH SCHEDULE FOR TYPE AND FINISH
3	NEW STAIR TREADS & RISERS, RBR-1
4	NEW PAINT AT RAILING & STRINGER, MATCH EXISTING
6	(E) WINDOW FRAME AND GLAZING TO REMAIN, PAINT FRAME.
7	WHITEBOARD FINISH ON OPERABLE PARTITION
8	NURSE CALL STATION, TYP. OUTSIDE SIMULATION ROOMS (4 TOTAL), RE: AV/IT DWGS.


ARCHITECT
Hord Coplan Macht, Inc.
1802 Wazee Street, Suite 450
Denver, CO 80202
ph: 303.607.0977
URL: www.hcm2.com

M/E/P ENGINEER
Cator, Ruma and Associates, Co.
890 Tabor Street
Lakewood, CO 80401
p. 303-232-6200
URL: www.catoruma.com

AV / IT
NV5
2850 18th Sty #202
Denver, CO 80211
ph: 303-222-6400
URL: www.nv5.com

COLORADO MOUNTAIN COLLEGE
NURSING RENOVATION
3000 Co Rd 114, Glenwood Springs, CO 81601

hord | coplan | macht
ARCHITECTURE
LANDSCAPE ARCHITECTURE
PLANNING
INTERIOR DESIGN

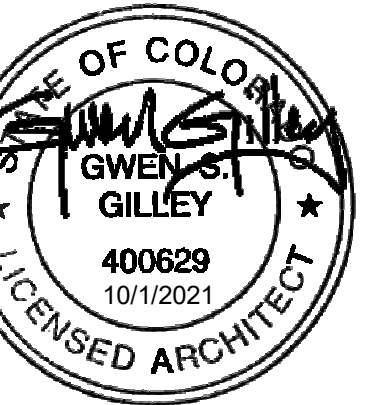

No. Date Revision

Project Name
NURSING RENOVATION

Project Number
22172.00

Date (YYYY/MM/DD)
10-01-2021

Drawn By
CK

 
 
Checked By
HRM

Drawing
INTERIOR ELEVATIONS

A-423

CONTRACT DOCUMENTS

© Hord Coplan Macht, Inc.



CONTRACT DOCUMENTS

